

PROJECT : 139/2022

RAMNAGAR BUS
TERMINAL

CLIENT:

UTTARAKHAND TRANSPORT
CORPORATION

DRAWING TYPE:

STRUCTURE DWG.

CONSTRUCTION WING:

UTTARAKHAND PEYJAL NIGAM
DEHRADUN

MEP CONSULTANT

ONE DESIGN & CONSULTANTS

7/8, LGF, Noida Extension, Kalkaji Extension,
New Delhi-110019
E-MAIL:- onedesignconsultants@gmail.com
web mail:- info@onedesignconsultants.com
MOB:- 99580-79000

PLUMBING LEGEND:

S.NO	SYMBOLS	DESCRIPTION
1	1	1000 SOIL VERTICAL PIPE
2	2	1000 UPVC SOIL VERTICAL A VENT PIPE
3	3	1000 WASTE VERTICAL PIPE
4	4	1000 UPVC WASTE VERTICAL A VENT PIPE
5	5	1000 KITCHEN WASTE VERTICAL PIPE
6	6	DOMESTIC VERTICAL PIPE
7	7	FLUSHING VERTICAL PIPE
8	8	HOT WATER SUPPLY
9	9	HOT WATER RETURN
10	10	DOMESTIC WATER SUPPLY RISER
11	11	FLUSHING WATER SUPPLY RISER
12	12	100 (OD) UPVC RAIN WATER PIPE
13	13	75 (OD) UPVC BALCONY WASTE PIPE
14	14	1000 SOIL PIPE RUN BELOW SLAB
15	15	1000 WASTE PIPE RUN BELOW SLAB
16	16	600 WASTE PIPE RUN UNDER FLOOR
17	17	DOMESTIC WATER SUPPLY PIPE
18	18	FLUSHING WATER SUPPLY PIPE
19	19	HOT WATER SUPPLY PIPE
20	20	HOT WATER SUPPLY RETURN PIPE
21	21	BALL VALVE
22	22	NON RETURN VALVE
23	23	FLOOR TRAP
24	24	FLOOR DRAIN
25	25	100X100 CUT OUT

PLUMBING LEGENDS:

S.N.	SYMBOLS	DESCRIPTION
01	1	SEWER LINE
02	2	SEWER MANHOLE
03	3	GULLY TRAP

S.N. LEGENDS

S.N.	LEGENDS
01	FOREST AREA

REVISION:

SR. NO.	DATE	DESCRIPTION
01	30-05-2023	FIRST ISSUED

PURPOSE OF DRAWING:

☐	☐	☐	☐
PRESL	ADVANCE	TENDER	G.P.C.

DRAWING TITLE:

SITE PLAN MEP LAYOUT

NORTH	DESIGNED BY: J.P.
	STRUCTURE DESIGNED BY: DR. NARAYAN K.J.
	DRAWN BY: S.K.
	CHECKED BY: J.P.
	DATE: 01-08-2023

ARCHITECT & ENGINEERS:


Accurate & Associates Infra Pvt.Ltd.

ARCHITECTS, ENGINEERS & INTERIORS

PHASE 1: 10/14, G.F. PHASE 2: 10/14, G.F. PHASE 3: 10/14, G.F.

PHASE 4: 10/14, G.F. PHASE 5: 10/14, G.F. PHASE 6: 10/14, G.F.

REVISION: 01

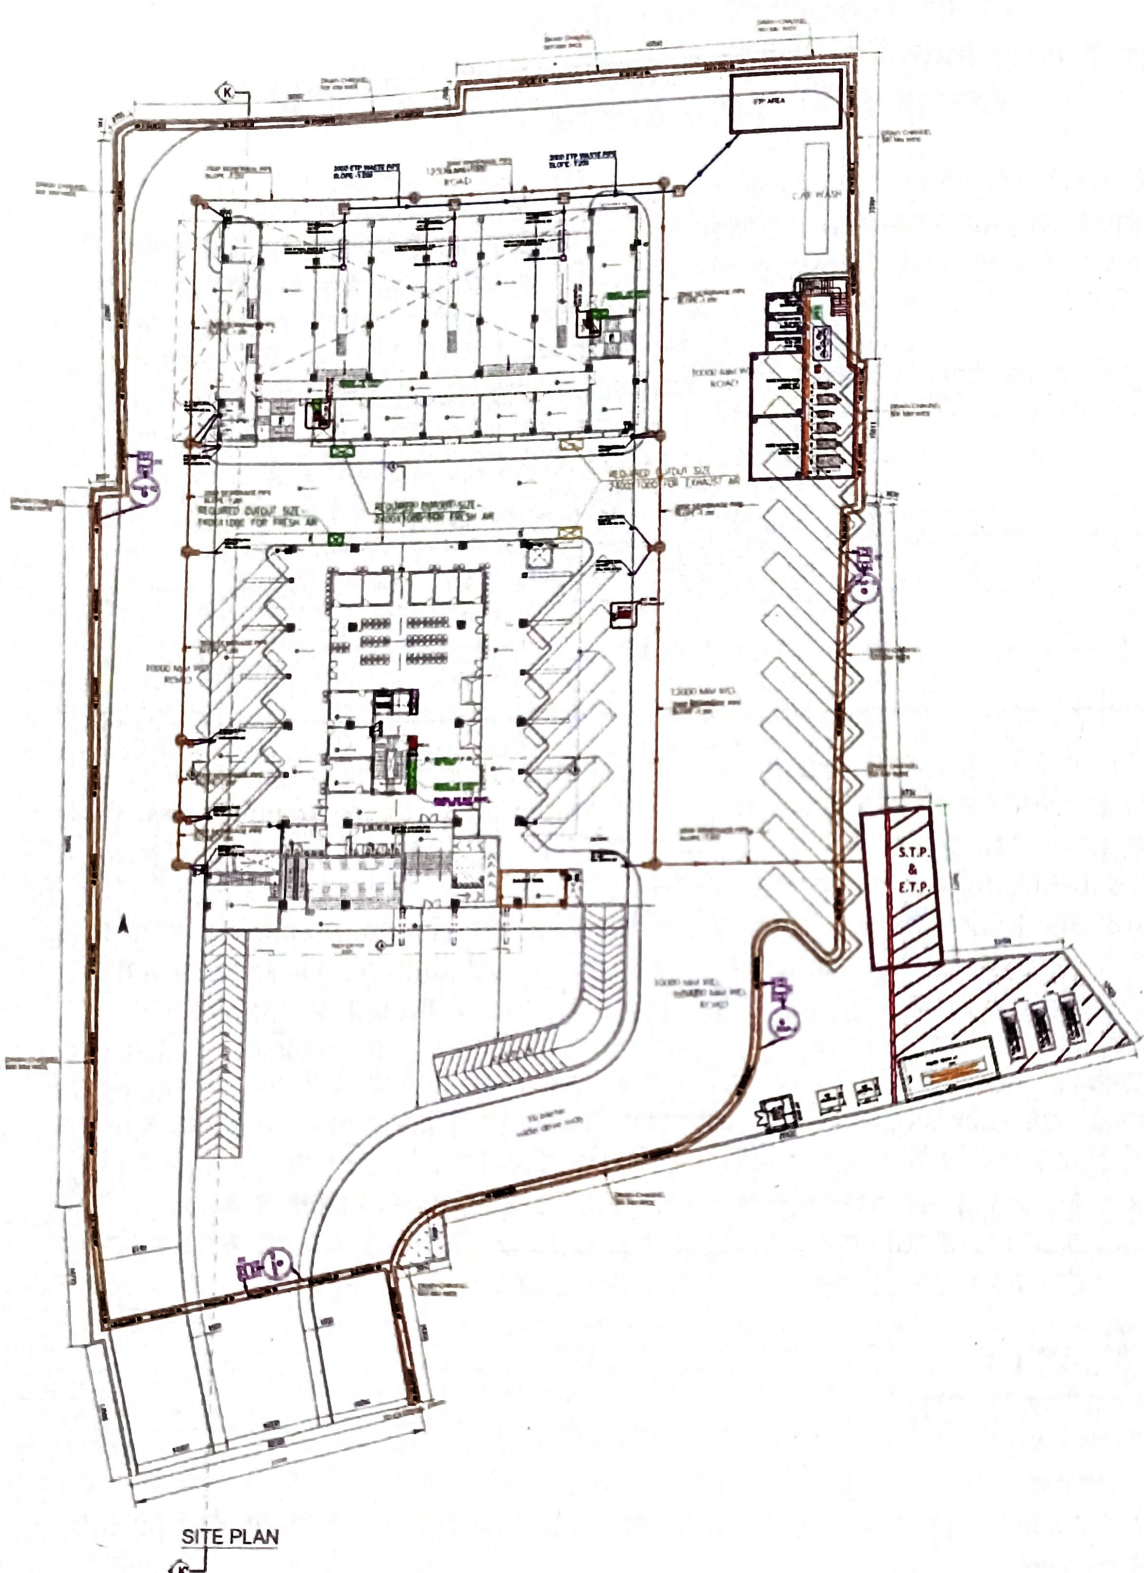

SITE PLAN

मण्डलीय प्रबन्धक (संचालन)
उत्तराखण्ड परिवहन निगम
काठगोदाम

मण्डलीय प्रबन्धक (संचालन)
उत्तराखण्ड परिवहन निगम
काठगोदाम