



Provisionally granted NOC vide
Letter No. RW/JM/RJ/PS/2012/815/1008
dated 22/02/2018

मुख्य अभियन्ता-रेजियनल/Chief Engineer-RO
सड़क परिवहन और राजमार्ग मंत्रालय
Ministry of Road Transport & Highways
भारत सरकार Government of India
क्षेत्रीय कार्यालय Regional Office
डी.सी.एम./DCM, राजमार्ग 15/अजर रोड
जोधपुर-342009/JODHPUR-302019

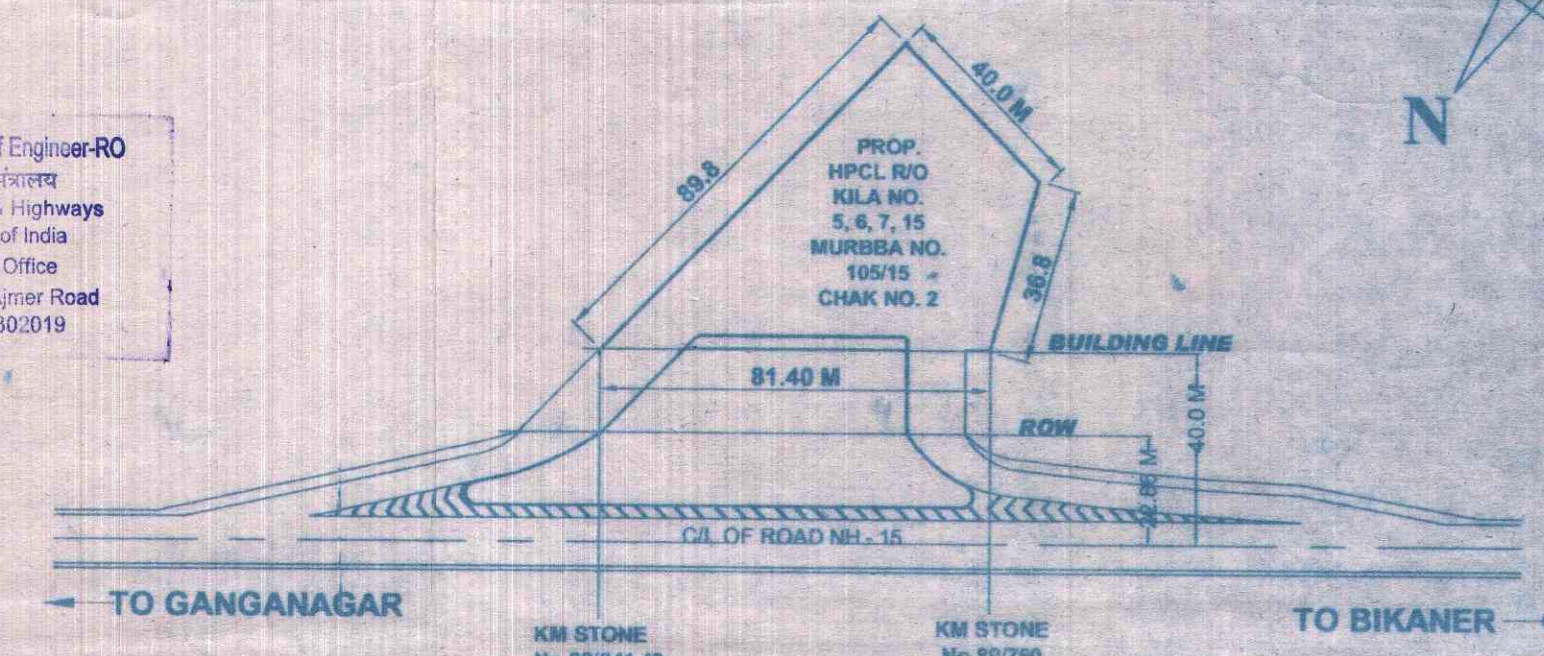


SITE PLAN
SCALE:-1CM = M

(A) FUEL STATION AHEAD AT 1 KM & 500M	(B) FUEL STATION	(C) FUEL STATION AHEAD	(D) ONWAY	(E) ONWAY	(F) NO ENTRY
(G) COMPULSORY DIRECTION CONTROL	(H) NO RIGHT TURN	(I) NO LEFT TURN	(J) HPCL SIGN BOARD	(K) PUBLIC TOILET	(L) PUBLIC DRINKING WATER M/C

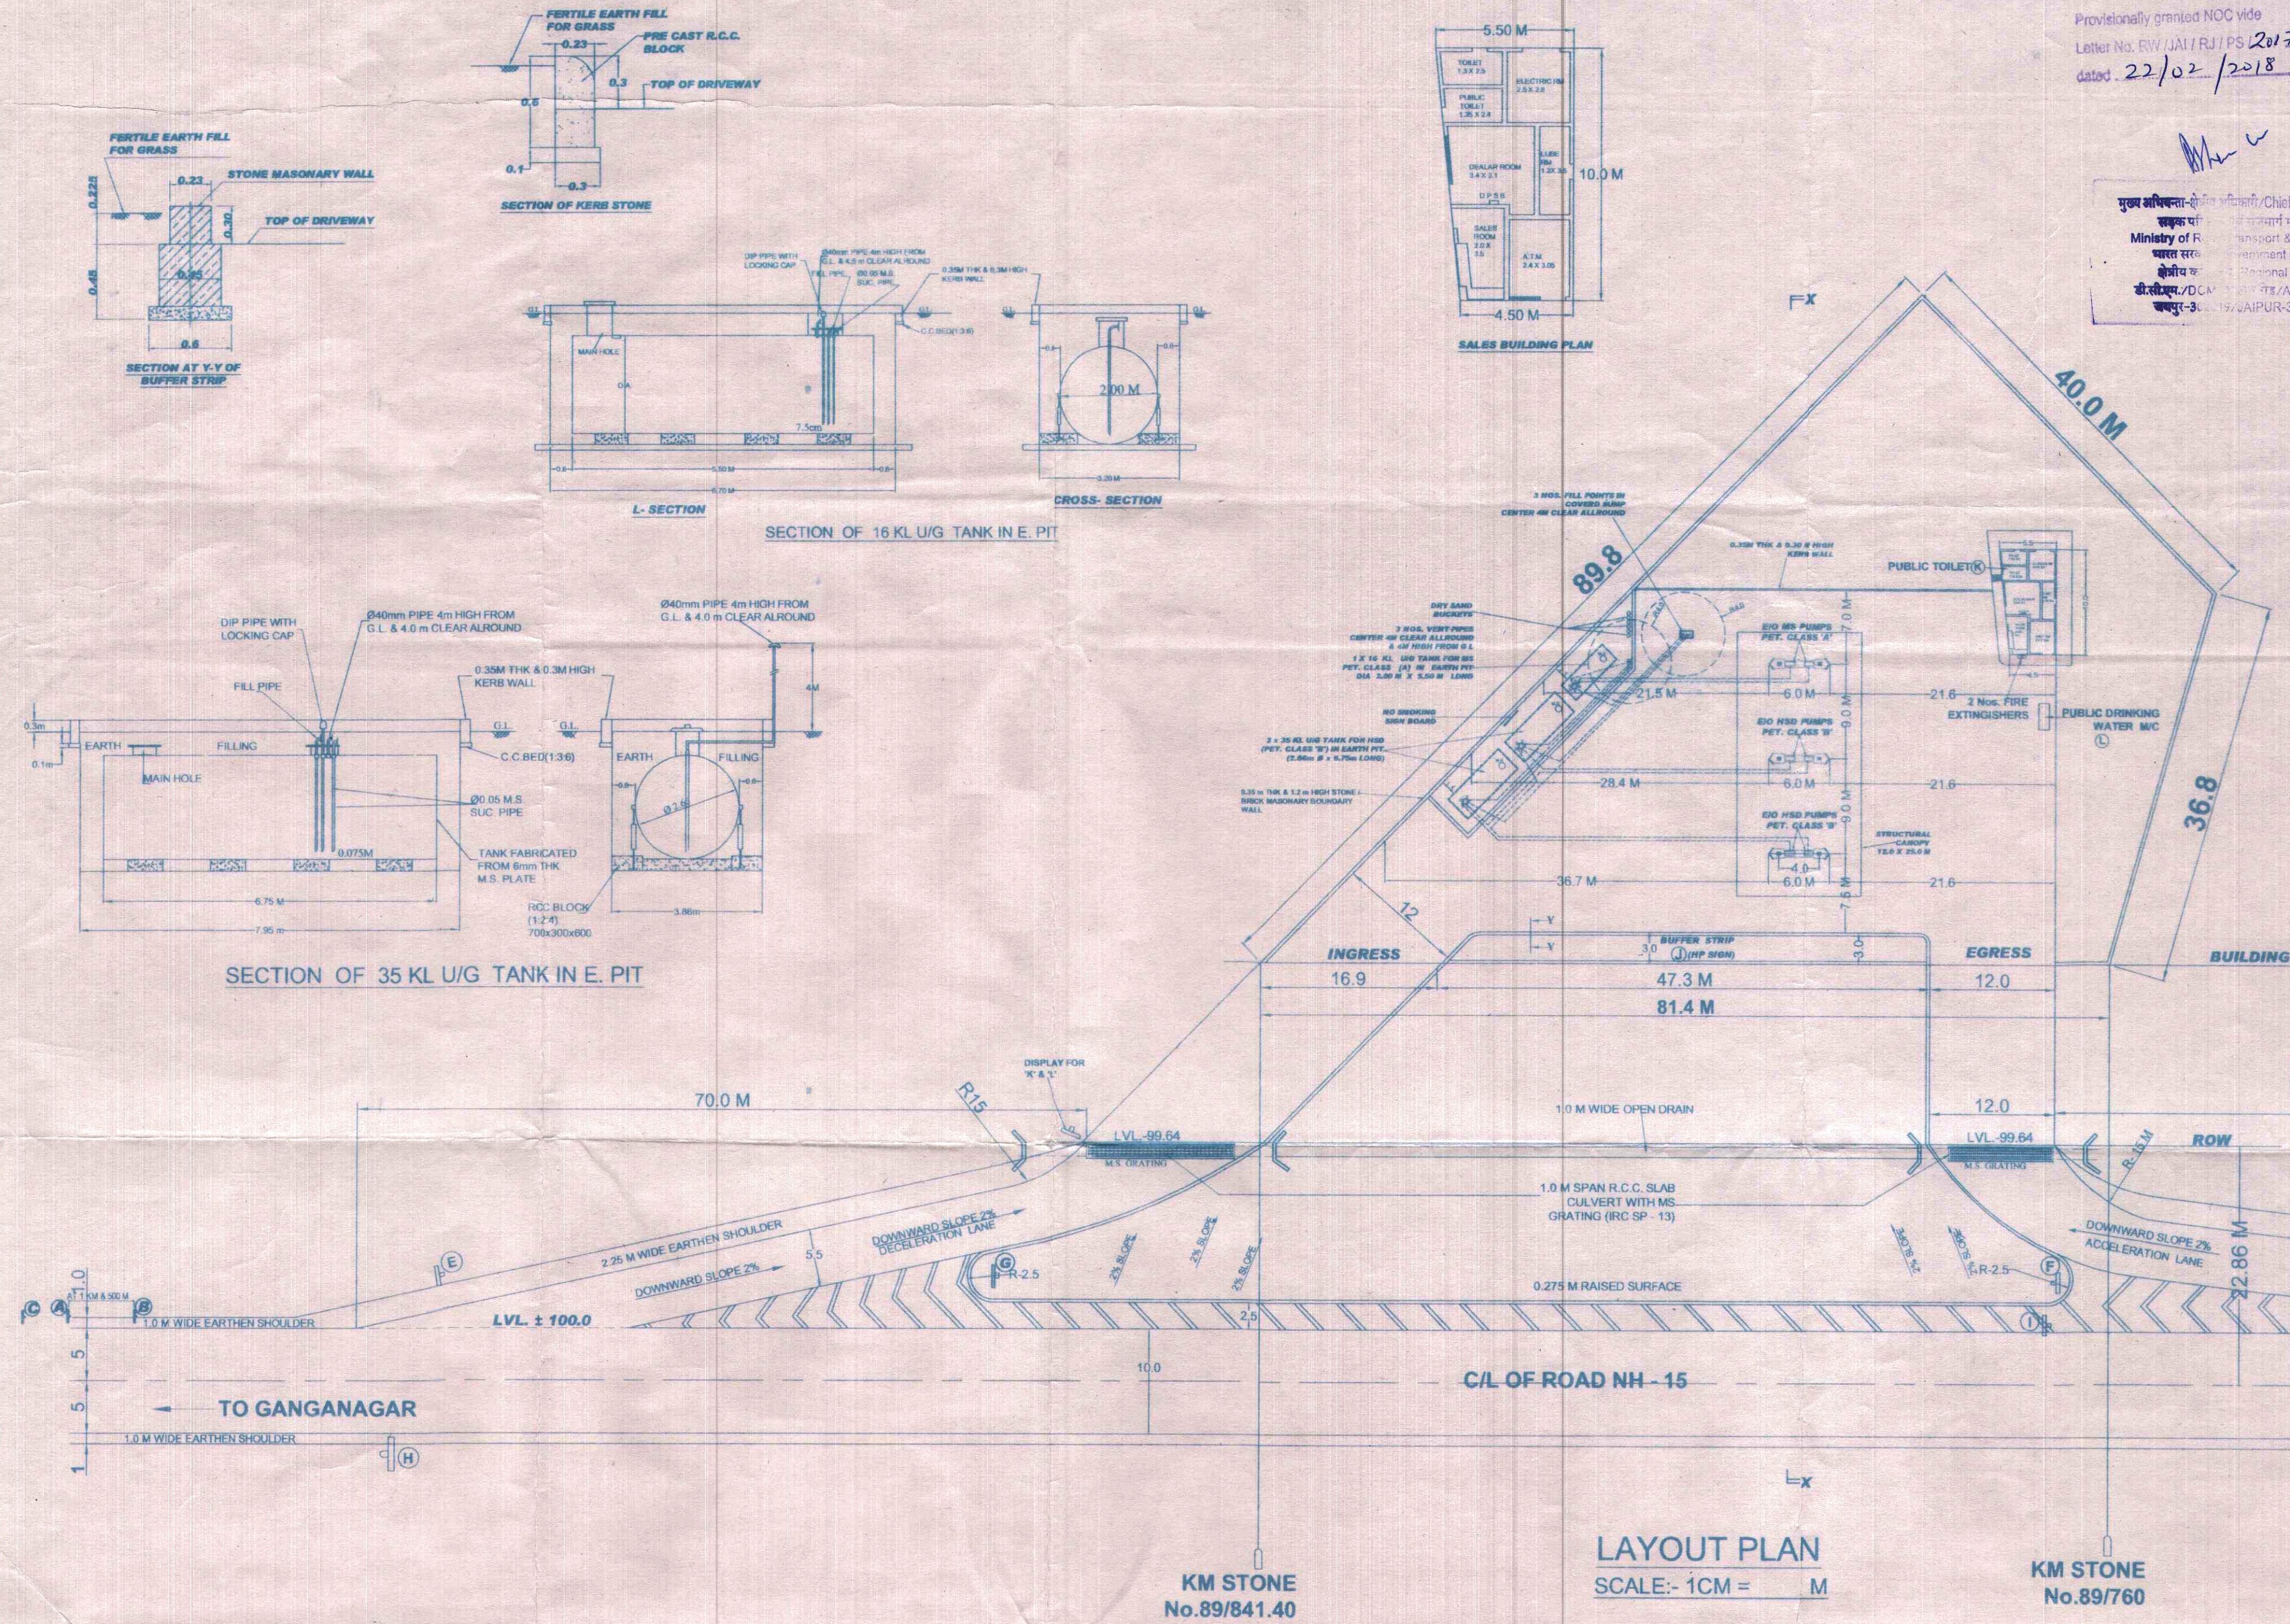

LAYOUT PLAN
SCALE:- 1CM = M

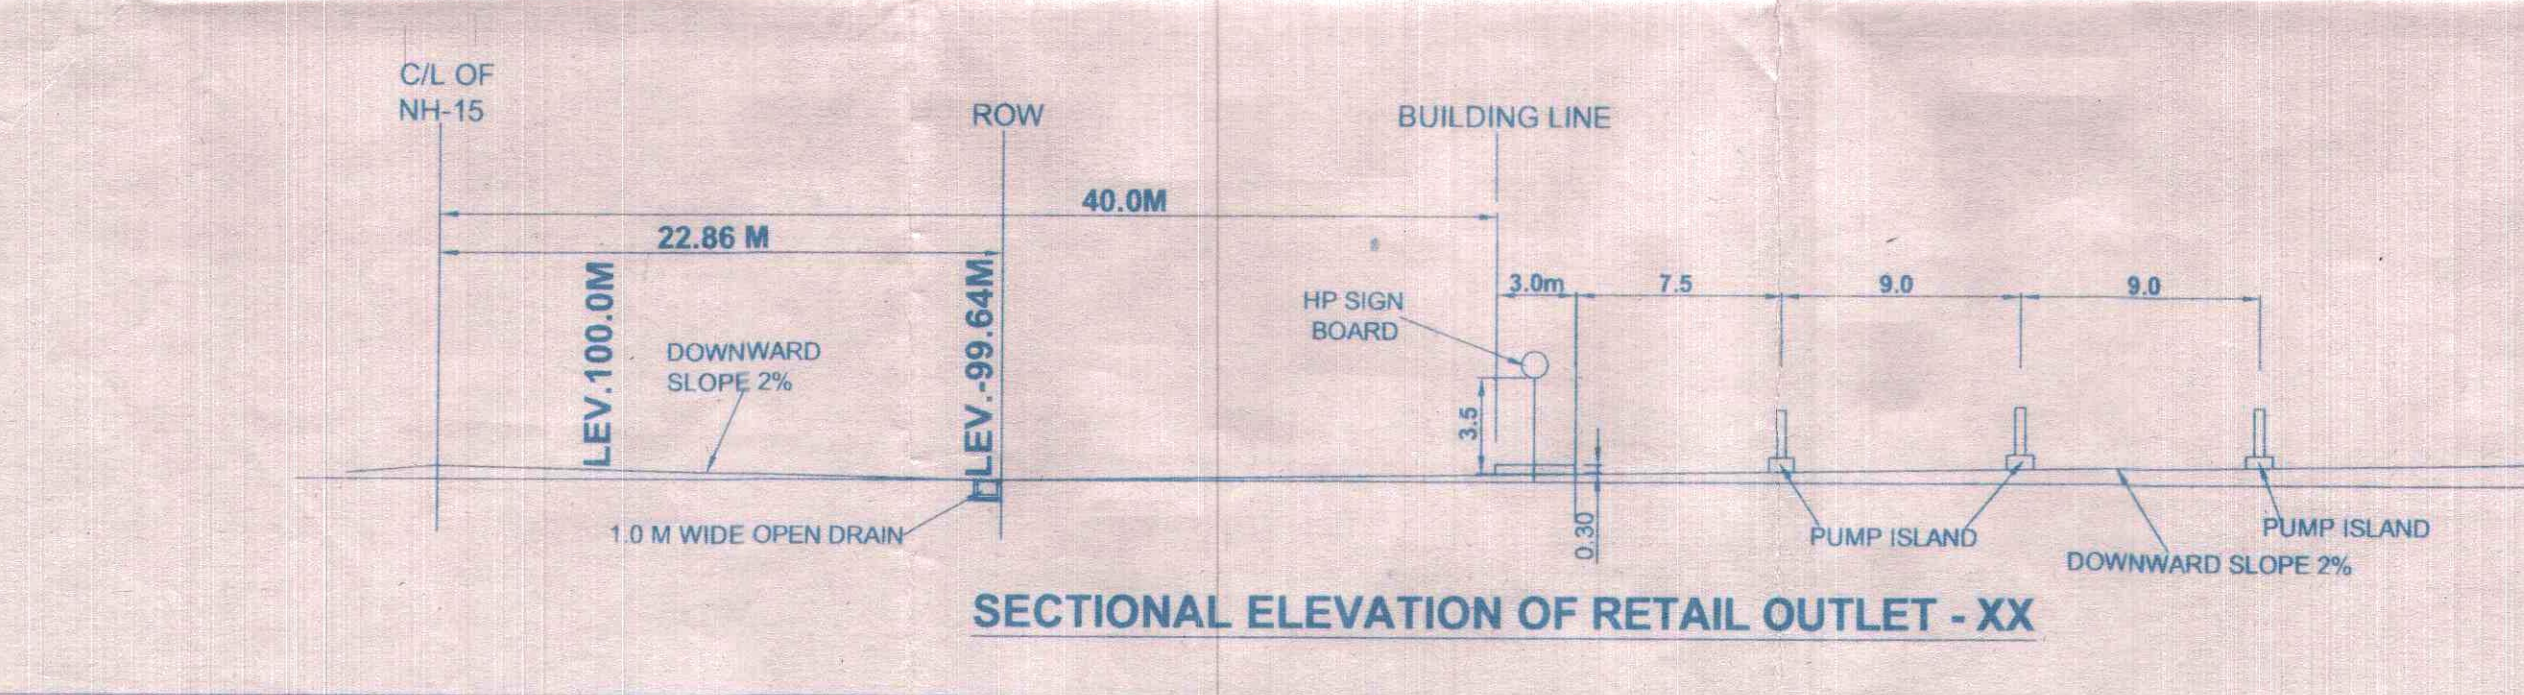

SECTIONAL ELEVATION OF RETAIL OUTLET - XX

Empaneled Consultant
Ministry Of Road Transport & Highways
F.No.RW/NH-33023/18/99-DOM S&R (R)
Dt 20-02-2014

CAP.	PRODUCT	CLASS	QTY.	SIZE	C. C. O. E. APPROVAL NO.
35 KL	HSD	(B)	1 No.	Ø 2.66M X 6.75M	HPCL - 35 KL No. P-6 (3) 60 Dt. 18-10-2010
16 KL	MS	(A)	1 No.	Ø 2.0M X 5.50M	HPCL - 16 KL No. P-6 (3) 60 Dt. 18-10-2010

D. UNIT	CLASS	QTY.
HSD	(B)	4 No.
MS	(A)	2 No.

DRAWN BY	PLOT SIZE	AS SHOWN
KILA NO. 5, 6, 7, 15	MURBBA NO. 105 / 15, CHAK NO. 2	NEAREST RAILWAY STATION:- LUNKARANSAR

DATE	REV. NO.	BRIEF RECORD	INITIAL

SCALE	SCALE AS SHOWN	NO CROSSED OUT ARE SUPERSEDED DRAWING
DRG NO:- JDR/BIK/NEW/CHAK 2 BHM/397		

Duly Constituted Attorney
For Hindustan Petroleum Corp. Ltd.
Shalabh Raj Gupta
Senior Regional Manager

HINDUSTAN PETROLEUM CORP. LTD.
REGIONAL OFFICE, JODHPUR

SITE & LAYOUT PLAN OF H.P.C.I. RETAIL OUTLET ON GANGANAGAR - BIKANER ROAD AT

VILLAGE :- CHAK 2 BHM
TEHSIL :- LUNKARANSAR
DISTRICT :- BIKANER