


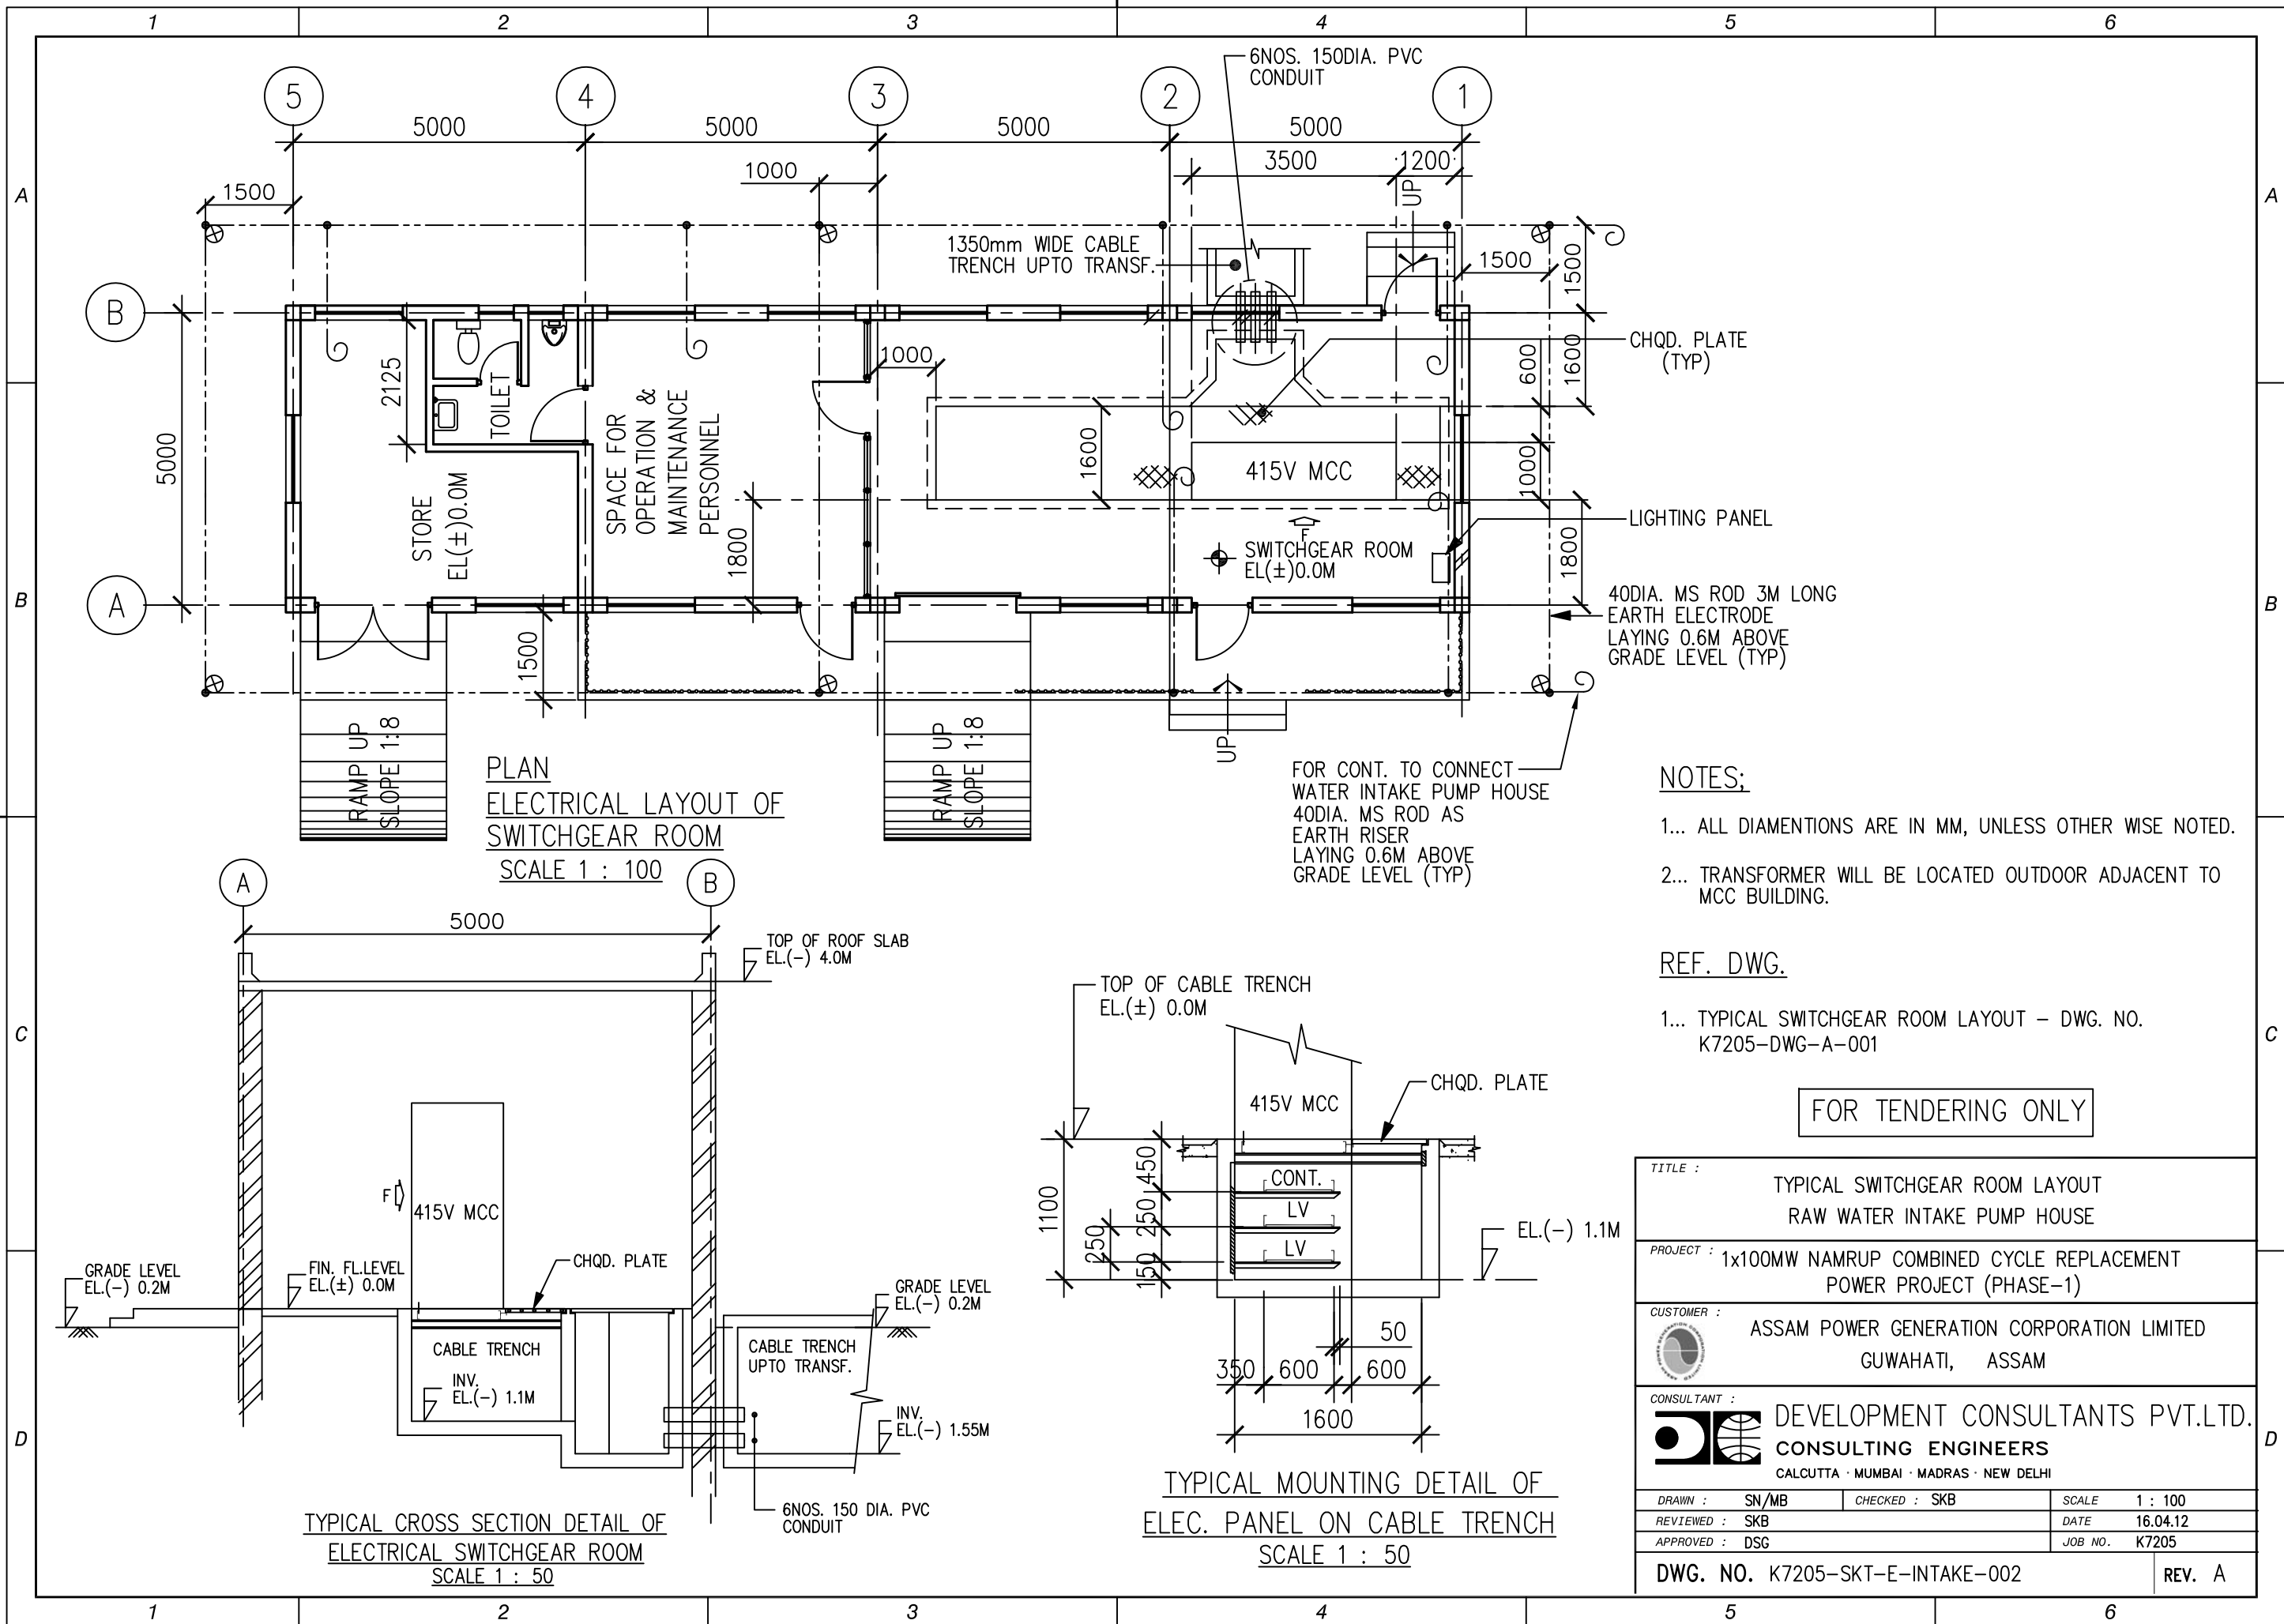

PLAN
ELECTRICAL LAYOUT OF
SWITCHGEAR ROOM
SCALE 1 : 100

- NOTES:
- 1... ALL DIAMENTIONS ARE IN MM, UNLESS OTHER WISE NOTED.
 - 2... TRANSFORMER WILL BE LOCATED OUTDOOR ADJACENT TO MCC BUILDING.

- REF. DWG.
- 1... TYPICAL SWITCHGEAR ROOM LAYOUT – DWG. NO. K7205–DWG–A–001

FOR TENDERING ONLY

TITLE : TYPICAL SWITCHGEAR ROOM LAYOUT RAW WATER INTAKE PUMP HOUSE		
PROJECT : 1x100MW NAMRUP COMBINED CYCLE REPLACEMENT POWER PROJECT (PHASE-1)		
CUSTOMER : ASSAM POWER GENERATION CORPORATION LIMITED GUWAHATI, ASSAM		
CONSULTANT : DEVELOPMENT CONSULTANTS PVT.LTD. CONSULTING ENGINEERS CALCUTTA · MUMBAI · MADRAS · NEW DELHI		
DRAWN : SN/MB	CHECKED : SKB	SCALE : 1 : 100
REVIEWED : SKB		DATE : 16.04.12
APPROVED : DSG		JOB NO. : K7205
DWG. NO. K7205–SKT–E–INTAKE–002		REV. A

TYPICAL CROSS SECTION DETAIL OF
ELECTRICAL SWITCHGEAR ROOM
SCALE 1 : 50

TYPICAL MOUNTING DETAIL OF
ELEC. PANEL ON CABLE TRENCH
SCALE 1 : 50