

SITE PLAN
SCALE : N.T.S.

AREA DETAIL	
TOTAL PLOT AREA	= 1364.47 SQM.
TOTAL BUILDING AREA	= 44.93 SQM.
KHEWAT NO = 415	
KHATONI NO. = 484	
KHASRA NO. = 361//5/2 MIN, 360//1	
VILLAGE = BITHMARA	
NEAREST POLICE STATION = UKLANA	
NEAREST RAILWAY STATION = UKLANA	
TEHSIL = UKLANA	
DISTRICT = HISSAR (HARYANA)	
APPROACH ROAD AREA	
1. AREA-A+A'	= 2 (6.0x8.30) = 99.60 SQM.
2. AREA-B+B'	= 2 (1/2x5.0x5.0 - 2/3x7.07x1.46) = 11.24 SQM.
TOTAL AREA	= 99.60+11.24 = 110.84 SQM. = 0.0110 HAC.





- NOTES**
- NO ROAD CROSSING WITHIN 100.0M ON EITHER SIDES OF THE PLOT .
 - NO DRAIN SEWER OR STRUCTURE WITHIN 1.5 M FROM THE UNDER GROUND TANKS .
 - SUCTION, FILL & VENT PIPES UNDER THE DRIVEWAY TO BE HOUSED UNDER PIPE SLEEVES .
 - VENT PIPES 40MM DIA AND 80MM DIA 4.0M HIGH FROM THE GROUND LEVEL AND 4.0MTR. CLEAR ALLROUND WITHIN THE PLOT FITTED WITH INVERTED 'U' TYPE VENT HOOD COVERED WITH TWO LAYERS OF NON CORRODABLE METAL WIRE GAUZE OF 11 MESH PER LINEAR CENTIMETER AT ITS OPEN ENDS .
 - D.P.S BOARD FIXED ON THE WALL OF ROOM 1.50MTR HIGH FROM ITS FLOOR LEVEL AND SHALL NOT BE KEPT UNDER LOCK AND KEY .
 - FILL POINTS ARE KEPT 3.65M CLEAR ALLROUND .
 - "NO SMOKING" SIGN SHALL BE DISPLAYED AT THE PETROL PUMP .
 - 12 NO FOAM TYPE FIRE EXTINGUISHERS OF CAPACITY 9 LTRS EACH FOR PETROLEUM FIRE, 2 NO CO TYPE FIRE EXTINGUISHERS OF CAPACITY 3 KGS. EACH FOR ELECTRIC FIRE AND 6 NO. FIRE BUCKETS FILLED WITH DRY SAND SHALL BE PROVIDED AT THE PETROL PUMP .
 - TANKS, FED BY TANK LORRY .
 - BOTH THE TANKS NOT BE REPLENISHED AT THE SAME TIME .
 - FILL PIPES AND DIP PIPES ARE FITTED WITH LOCKING CAP.
 - ELRCTIC FITTING CONFORM TO ISS CODE NO. 2148.

- SPECIFICATIONS**
- MS TANK OF 20KL CAPACITY FABRICATED AS PER DRG. APPROVED BY C.C.E. NAGPUR VIDE LETTER NO P-6 (3) 51 DT 23-01-2007
- NOTE**
- CERTIFIED THAT THIS IS A NEW RETAIL OUTLET & NOT RESITEMENT CASE.
 - CERTIFIED THAT NO COURT CASE PENDING IN ANY COURT OF INDIA AGAINST THIS SITE / DEALERSHIP .
 - CERTIFIED THAT ALL THE CLEARANCES/APPROVALS FROM MCP/IRC AND OTHER RELEVANT GOVT. DEPTT. SHALL BE OBTAINED .
 - CERTIFIED THAT ALL FACILITIES AS SHOWN IN THE DRAWING ARE INSTALLED/PROVIDED AT ABOVE R/O.
 - CERTIFIED THAT M.S. CANOPY OF MEASURING 12.00M X 16.00M SHALL CONFORM TO SOUND ENGG. SPEC. AND THERE IS NO CHANCE OF ITS EVER CAVING-IN UNDER NORMAL CIRCUMSTANCES .

- LEGEND**
- PROPOSED FACILITIES SHOWN THUS
 - DISMNTLED WORK SHOWN THUS

LAYOUT PLAN
SCALE : 1:150

TANK	SIZE OF TANK	SHELL	MS PLATES	END	NO OF H.D.B.	VENT PIPE DIA.	SLAB TH. IN MM	TANKS	PUMPS	
								MS	HSD	
20 KL	2.1M X 6.25M. LONG	6mm	8mm	8	40	325	1	2	2	4

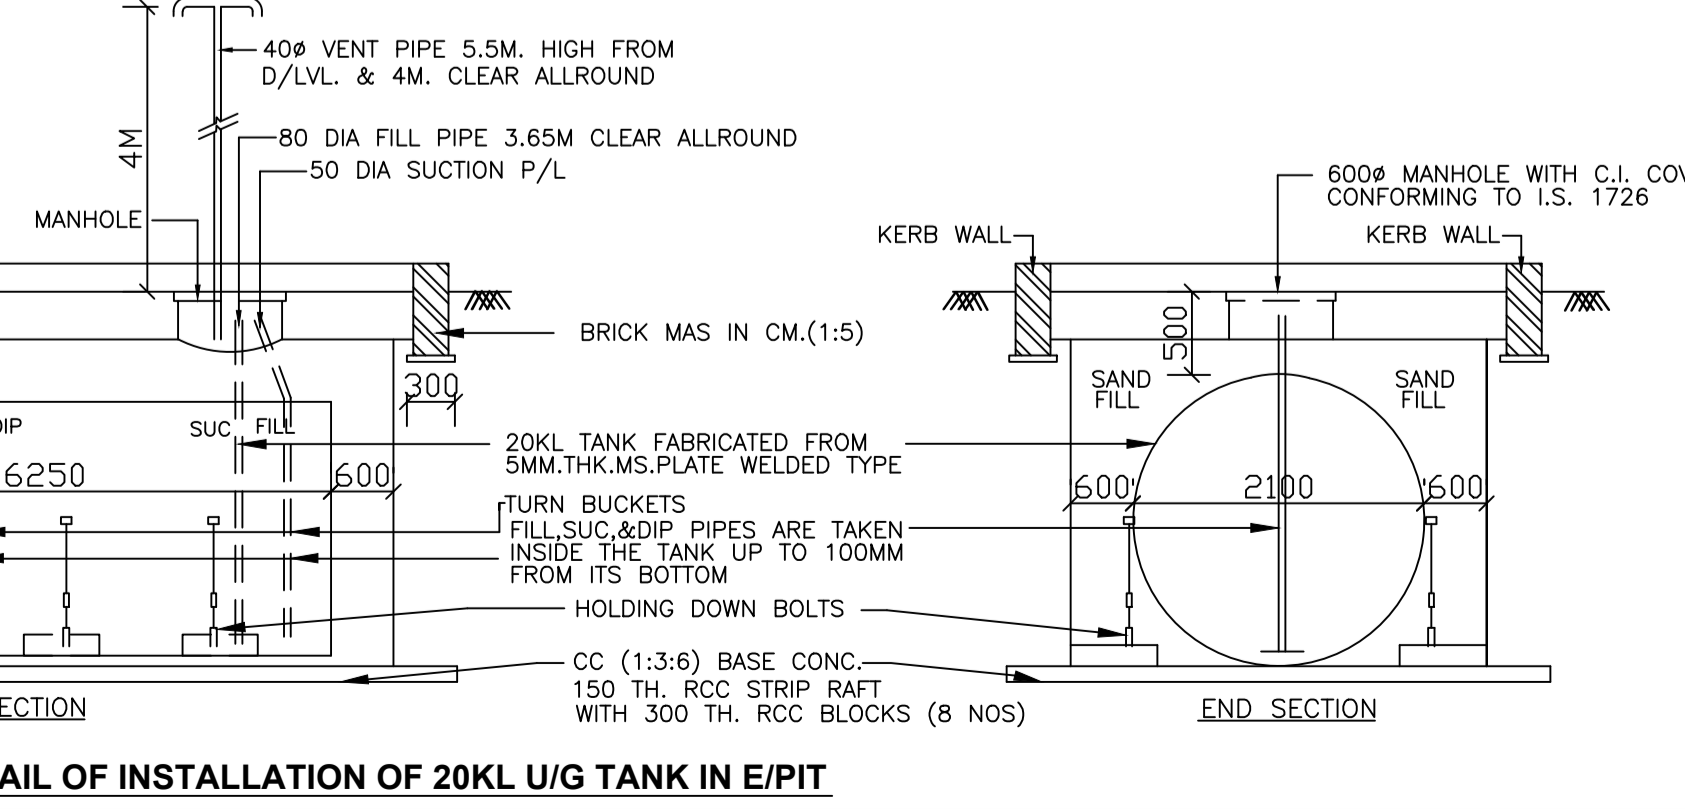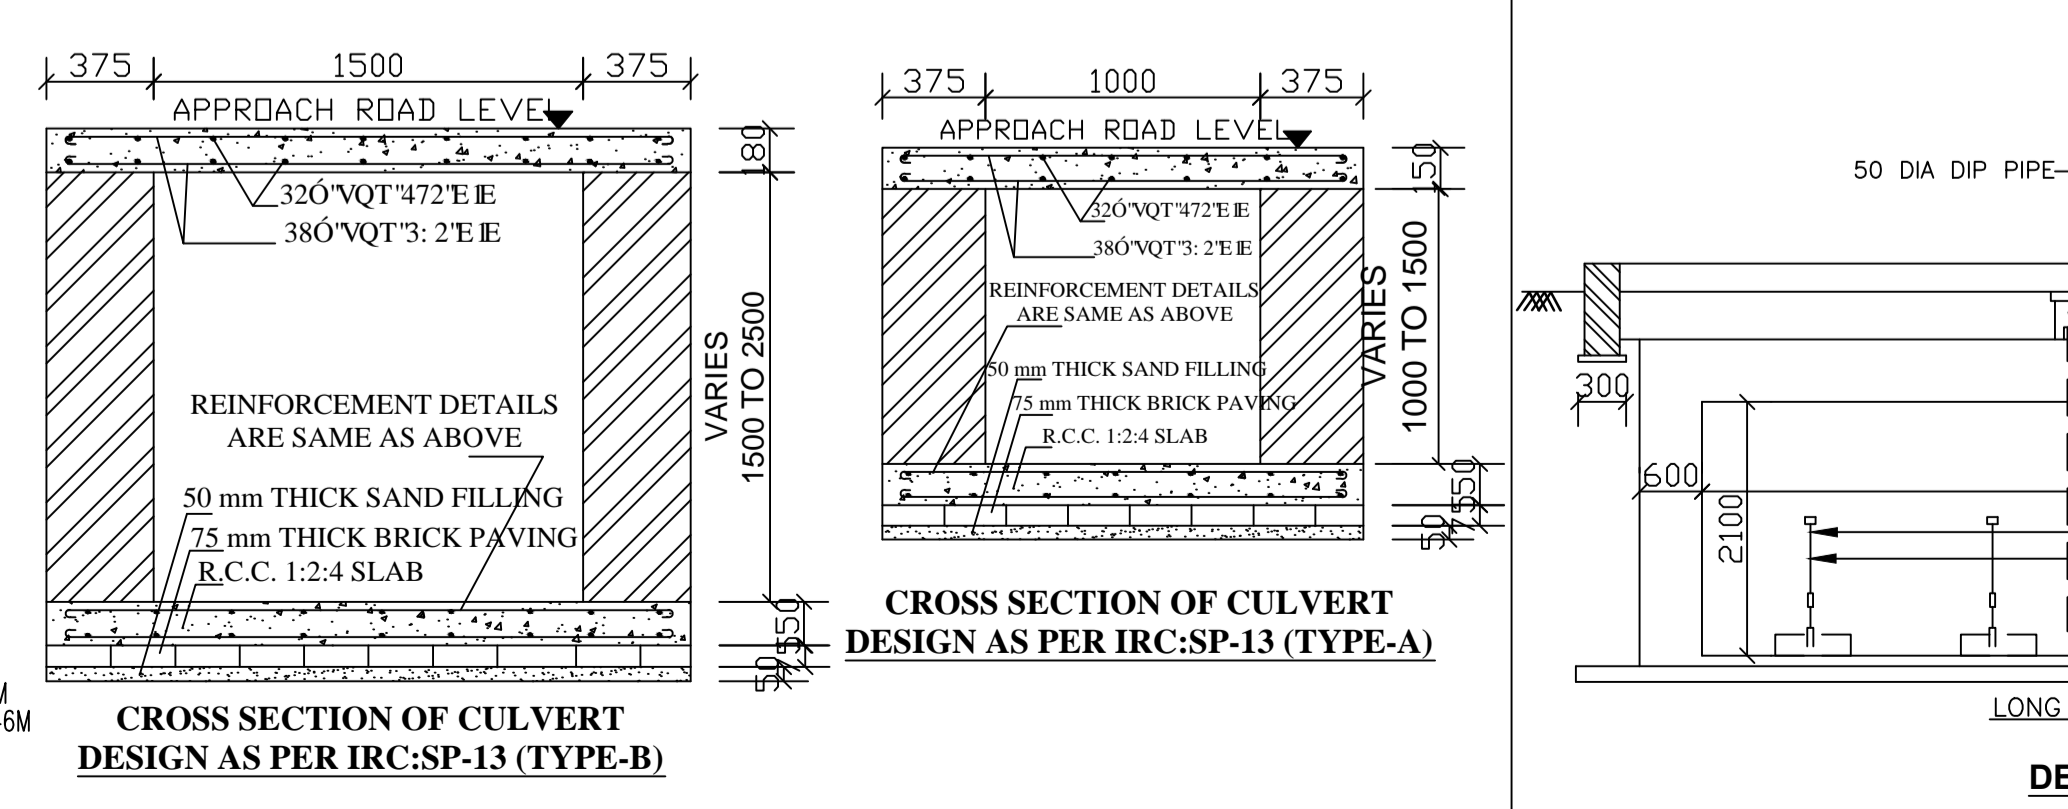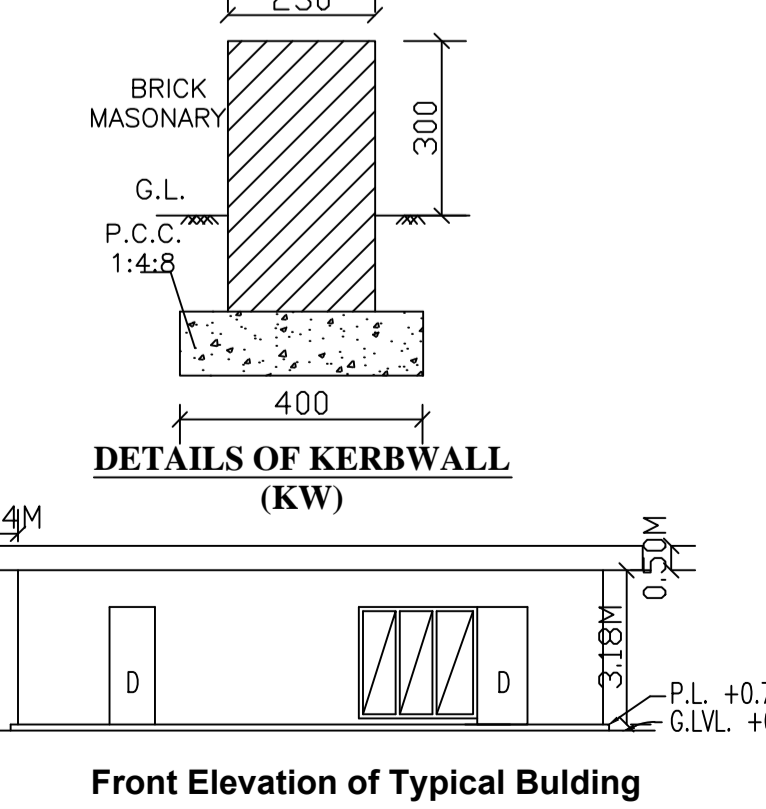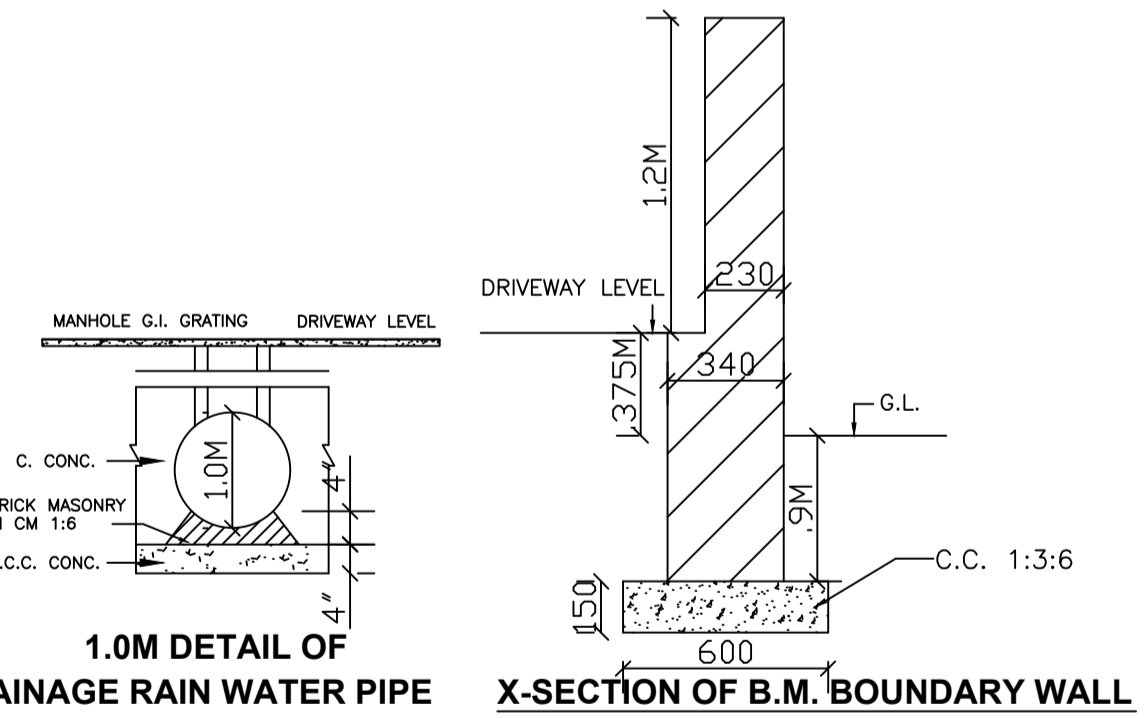

DATE	REV. No.	BRIEF DESCRIPTION OF REVISIONS MADE	CHECKED
	REV-1	NEW PERPOSAL	
	REV-2		
	REV-3		

Indian Oil Corporation Limited (Marketing Division) Divisional Office, Hissar DELHI & HARAYANA STATE OFFICE		
RETAIL OUTLET MS/HSD FUELS ROAD NAME HISSAR-TOHANA (SH-17)	POLICE STATION UKLANA TEHSIL UKLANA ROAD No./CHAINAGE Near KMS- 48	KHASRA No. 361//5/2 MIN, 360//1 MAUZA BITHMARA DISTRICT HISSAR STATE HARYANA
RAILWAY STATION UKLANA NAME OF RETAIL OUTLET -	DATE 20.10.12 PREPARATION: TECHNO ENGINEERS	EXPLOSIVE LICENSE No. New DRAWING No. HDO/PK20022012