

NOTES FOR EXPLOSIVES :-

1. NO ROAD CROSSING WITHIN 100M ON EITHER SIDE OF THE PLOT.
2. NO OPEN DRAIN SEWER OR STRUCTURE WITHIN 6.0M FROM U/G TANKS.
3. MORE THAN ONE TANK IS NOT TO BE REPLACED AT ONE TIME.
4. TANKS FED BY TANK LORRY.
5. ALL ELECTRIC FITTINGS ARE CONFIRMED TO IS :2148.
6. FILL POINTS 3.65M CLEAR AROUND.
7. 50MM DIA. VENT PIPES 4.0M HIGH FROM G.L. AND 4M CLEAR AROUND AND OPEN ENDS COVERED WITH 2 LAYERS OF NON CORRISIBLE METAL WIRE GAUZE OF 11 MESH PER LINEAR C.M.
8. 50MM DIA. SUCTION PIPES UNDER DRIVE WAY IS TO BE HOUSED IN 70MM DIA. PIPE SLEEVES.
9. NO SMOKING SIGN SHALL BE DISPLAYED IN THE LICENCE PREMISES.
10. 2No. FIRE EXTINGUISHER ABC TYPE, 10Kgs. CAPACITY SHALL BE PROVIDED ON EACH ISLAND AND 2No. OUTSIDE THE SALES BUILDING, 4 No. DRY SAND BUCKETS SHALL BE KEPT WITH LID IN THE LIC. PREMISES.
11. DPS BOARD 1.50M HIGH FROM FLOOR LEV. & SHOULD NOT BE KEPT UNDER LOCK & KEY.
12. 20KL TANK INSTALLATIONS AS PER APPROVAL OF C.C.E. NAGPUR VIDE HIS LETTER NUMBER P-6 (3) 51 DATED - 04.05.2006
13. 10KL TANK INSTALLATIONS AS PER APPROVAL OF C.C.E. NAGPUR VIDE HIS LETTER NUMBER P-6 (3) 51 DATED 23-01-2007 OF DRAWING NO. ENG/302-1/2 & ENG/302-2/2
14. 1 X 4.50KG. CO₂ FIRE EXTINGUISHER TO BE PLACED NEAR ELECTRIC ROOM.

CERTIFICATES :-

1. CERTIFIED THAT ALL FACILITIES WILL BE/HAVE BEEN INSTALLED ARE EXACTLY AS PER THIS DRAWING.
2. CERTIFIED THAT THIS IS NOT A RESITEMENT CASE.
3. CERTIFIED THAT NO COURT CASE IS PENDING IN ANY COURT OF INDIA AGAINST THIS PREMISES.
4. CERTIFIED THAT THE FABRICATION OF UNDER GROUND TANKS IS CONFIRMING TO COOE APPROVAL NUMBER P-6(3) 51 DATED 23/01/2007.
5. CERTIFIED THAT WE ARE USING COOE APPROVED DISPENSING UNITS IN OUR RETAIL OUTLET AND THE MAKE & MODEL NUMBER OF EACH DISPENSER COMMISSIONED IN THE PREMISES SHALL BE PROVIDED AT THE TIME OF GRANT OF LICENSE.
6. CERTIFIED THAT ALL THE CLEARANCES/APPROVALS FROM MOP, IRC & OTHER RELEVANT GOVT. DEPTT. HAVE ALREADY BEEN OBTAINED.
7. CERTIFIED THAT CANOPY MEASURING 11.00M X 17.00M IS CONFIRMS TO SOUND ENGS. SPECIFICATIONS & THERE IS NO CHANCE OF ITS OVER CAVING IN UNDER NORMAL CIRCUMSTANCES.

NOTE FOR AUTOMATION (ATG):-


1. AUTOMATION FACILITIES SHOWN UNDER THE CCE NO. VIDE LETTER NO. A/P/HQ/M/2208 DT. 16.10.2015

NATIONAL HIGHWAYS NOTES:-

1. DRAWING PREPARED AS PER MORT&H GUIDELINES RW / NH-33032/01/2017-S&R DATED 26.06.2020
2. ALL PAVEMENT MARKINGS SHOULD BE AS PER IRC:35-1997.
3. ACCESS ROAD SHOULD HAVE MIN. PAVEMENT COMPOSITION OF 150MM GSB WBM CR I, II, III OF 75MM EACH 50MM BM & 25MM SDC.
4. ALL TRAFFIC SIGNS SHOULD BE AS PER IRC: 67- 2001 & IRC:SP-55-2001 IN CASE OF A FUEL STATION LOCATED ON THE OTHER SIDE OF TRAVEL DIRECTION THE USER SHOULD BE INFORMED OF THE LOCATION OF THE FUEL STATION IN HIS/HER DIRECTION OF TRAVEL THROUGH INFORMATION SIGN AS AT "C" OF THE TABLE OF THIS DRAWING.
5. THE LENGTH OF SEPARATOR ISLAND SHALL BE DETERMINED AS PER SITE CONDITION ITS MIN. WIDTH SHOULD BE 3.0M.
6. CULVERTS TO BE PROVIDED IN THE LINE OF STROM WATER DRAIN ON ENTRY & EXIT APPROACHES TO CATER TO THE EXPECTED DISCHARGE.

LOCATION DETAILS :-


KILA No : 9 & 10
MURBBA NO : 11
VILLAGE : 17 STB
TEHSIL : SURATGARH
DISTRICT : SRIGANGANAGAR
POLICE STATION : SURATGARH
RAILWAY STATION : BHAGWANSAR
STATE : RAJASTHAN
PIN CODE : 335804

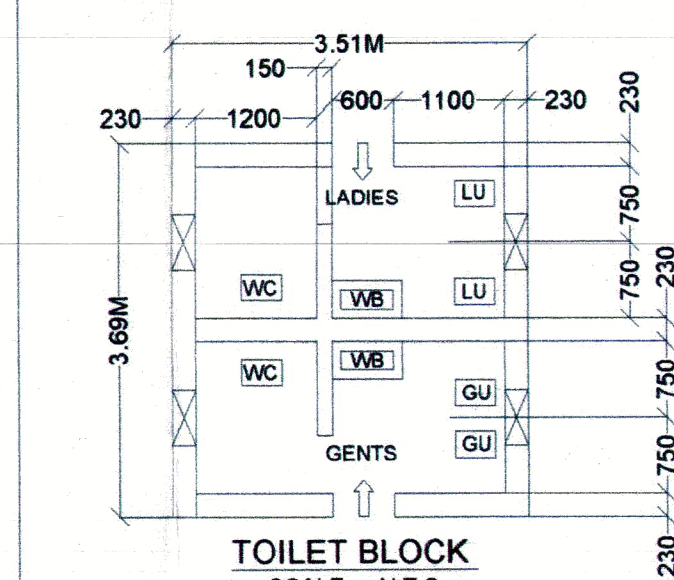

DETAILS OF STEEL STRUCTURE OF STEEL CANOPY N.T.S.

TOP OF PARAPET-1.79 M
TOP OF SLAB-3.485 M
BOTTOM OF BEAM-3.04 M
WIN. SILL +0.53 M
G.F. FIN. LVL. +0.30 M
DRIVE WAY LVL. +0.30 M


ELEVATION OF BUILDING

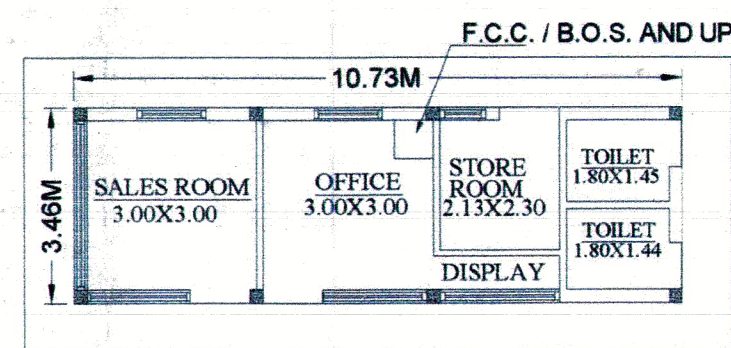

BUILDING PLAN


SECTIONAL ELEVATION WITH RESPECT TO SH (SECTION AT A-A)

SCALE - 1:250

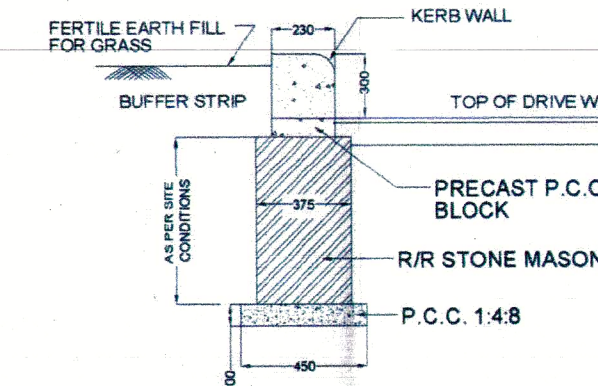


SECTION OF KERB WALL & BUFFER STRIP

SCALE - N.T.S. (DIMENSION SHOW IN MM.)

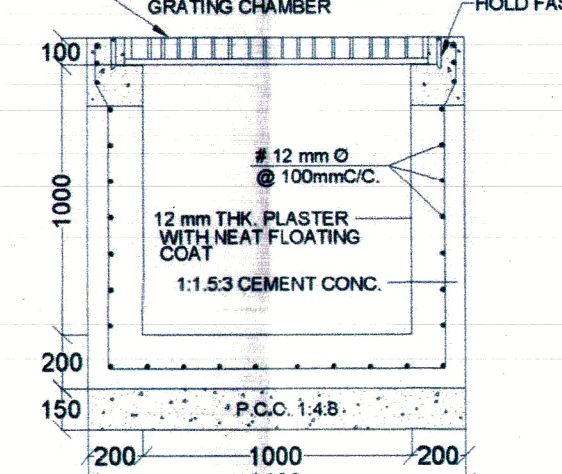


TYPICAL SECTION OF R.C.C.

CULVERTS AS PER IRC SP - 13

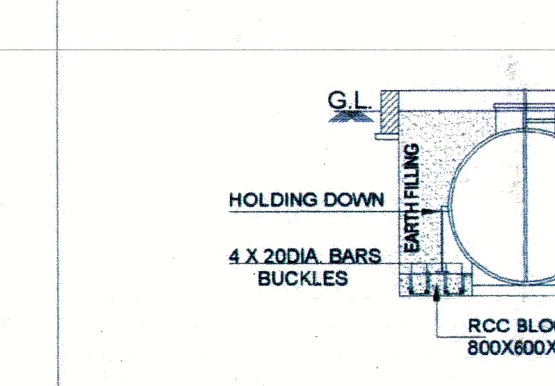


SECTIONAL DETAIL OF 20 KL U/G. TANK

(NOT TO SCALE)

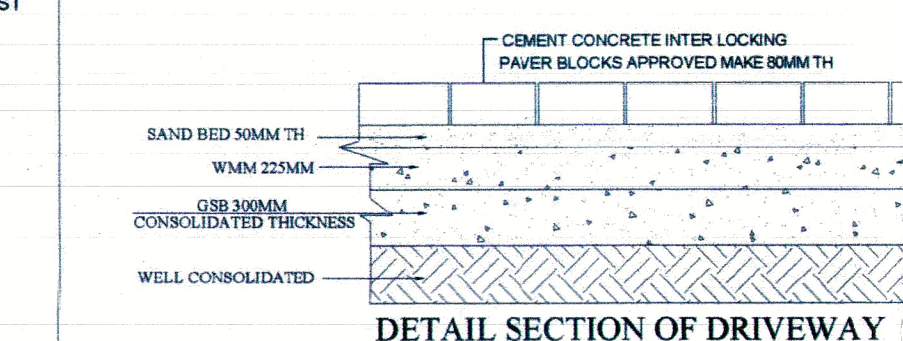


DETAIL SECTION OF DRIVEWAY

- | Symbol | Description |
|--------|--|
| A | FUEL STATION AHEAD AT 500M & 1KM |
| B | FUEL STATION |
| C | FUEL STATION AHEAD (2.0KM) |
| D | GIVE WAY |
| E | ONE WAY |
| F | NO ENTRY |
| G | COMPULSORY DIRECTION CONTROL |
| H | NO RIGHT TURN |
| I | NO LEFT TURN |
| J | FUEL STATION BOARD |
| K | PUBLIC FACILITY AS DRINKING WATER & TOILET |

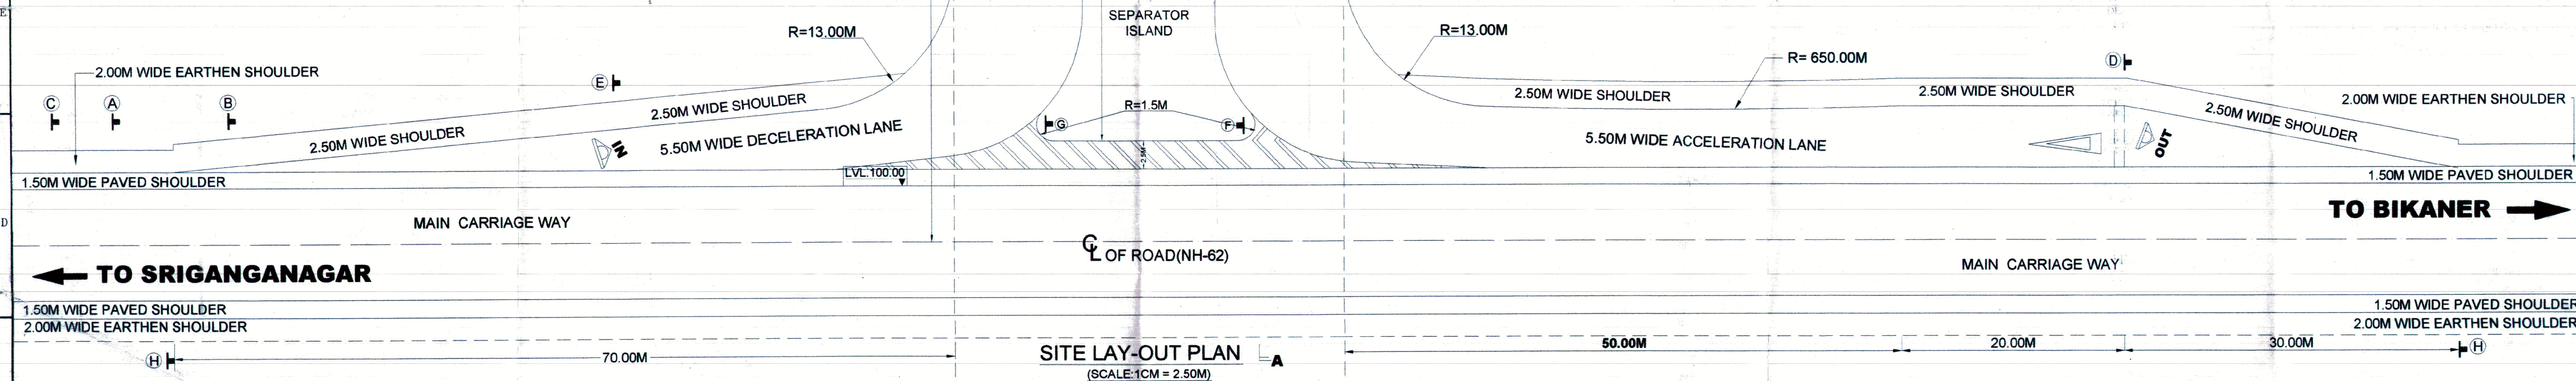

SITE LAY-OUT PLAN (SCALE: 1CM = 2.50M)

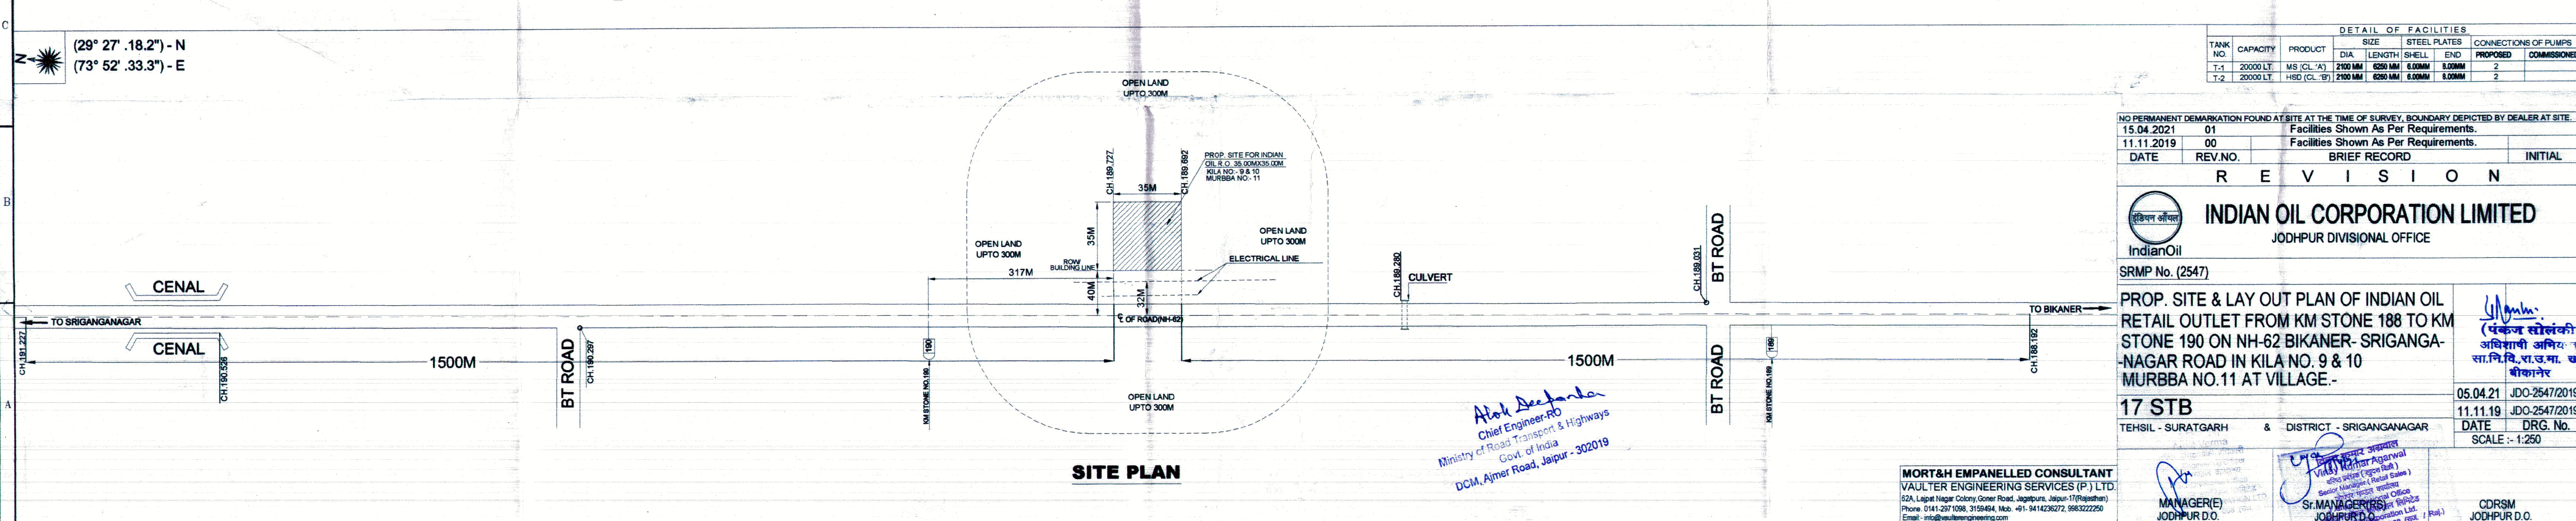

SITE PLAN

DETAIL OF FACILITIES									
TANK NO.	CAPACITY	PRODUCT	SIZE	STEEL PLATES	CONNECTIONS OF PUMPS				
						PROPOSED	COMMISSIONED		
T-1	20000 LT.	MS (CL. A)	2100 MM	6250 MM	0.00MM	0.00MM	0.00MM		
T-2	20000 LT.	MSD (CL. B)	2100 MM	6250 MM	0.00MM	0.00MM	0.00MM		

NO PERMANENT DEMARCATION FOUND AT SITE AT THE TIME OF SURVEY. BOUNDARY DERIVED BY DEALER AT SITE.
15.04.2021 01 Facilities Shown As Per Requirements.
11.11.2019 00 Facilities Shown As Per Requirements.

DATE REV. NO. BRIEF RECORD INITIAL

R E V I S I O N

IndianOil
SRMP No. (2547)

PROP. SITE & LAY OUT PLAN OF INDIAN OIL RETAIL OUTLET FROM KM STONE 188 TO KM STONE 190 ON NH-62 BIKANER- SRIGANGANAGAR ROAD IN KILA NO. 9 & 10 MURBBA NO. 11 AT VILLAGE -

17 STB
TEHSIL - SURATGARH & DISTRICT - SRIGANGANAGAR

05.04.21 JDO-2547/2019
11.11.19 JDO-2547/2019
DATE DRG. No. SCALE: 1:250

MANAGER(E)
JODHPUR D.O.

CDRSM
JODHPUR D.O.

MORT&H EMPANELLED CONSULTANT
VAULTER ENGINEERING SERVICES (P) LTD.
52A, Laxmi Nagar Colony, Gopal Road, Jagatpura, Jaipur-320022
Phone: 0141-2971098, 3158484, Mob: +91-9414226272, 9862222250
Email: info@vaalterengineering.com

Atok Deshpande
Chief Engineer-Rt
Ministry of Road Transport & Highways
Govt. of India
DCM, Ameer Road, Jaipur - 302019

Copy Received for execution