


PROPOSED 30 MLD WTP AREA

LOCATION:- SITARAMPUR

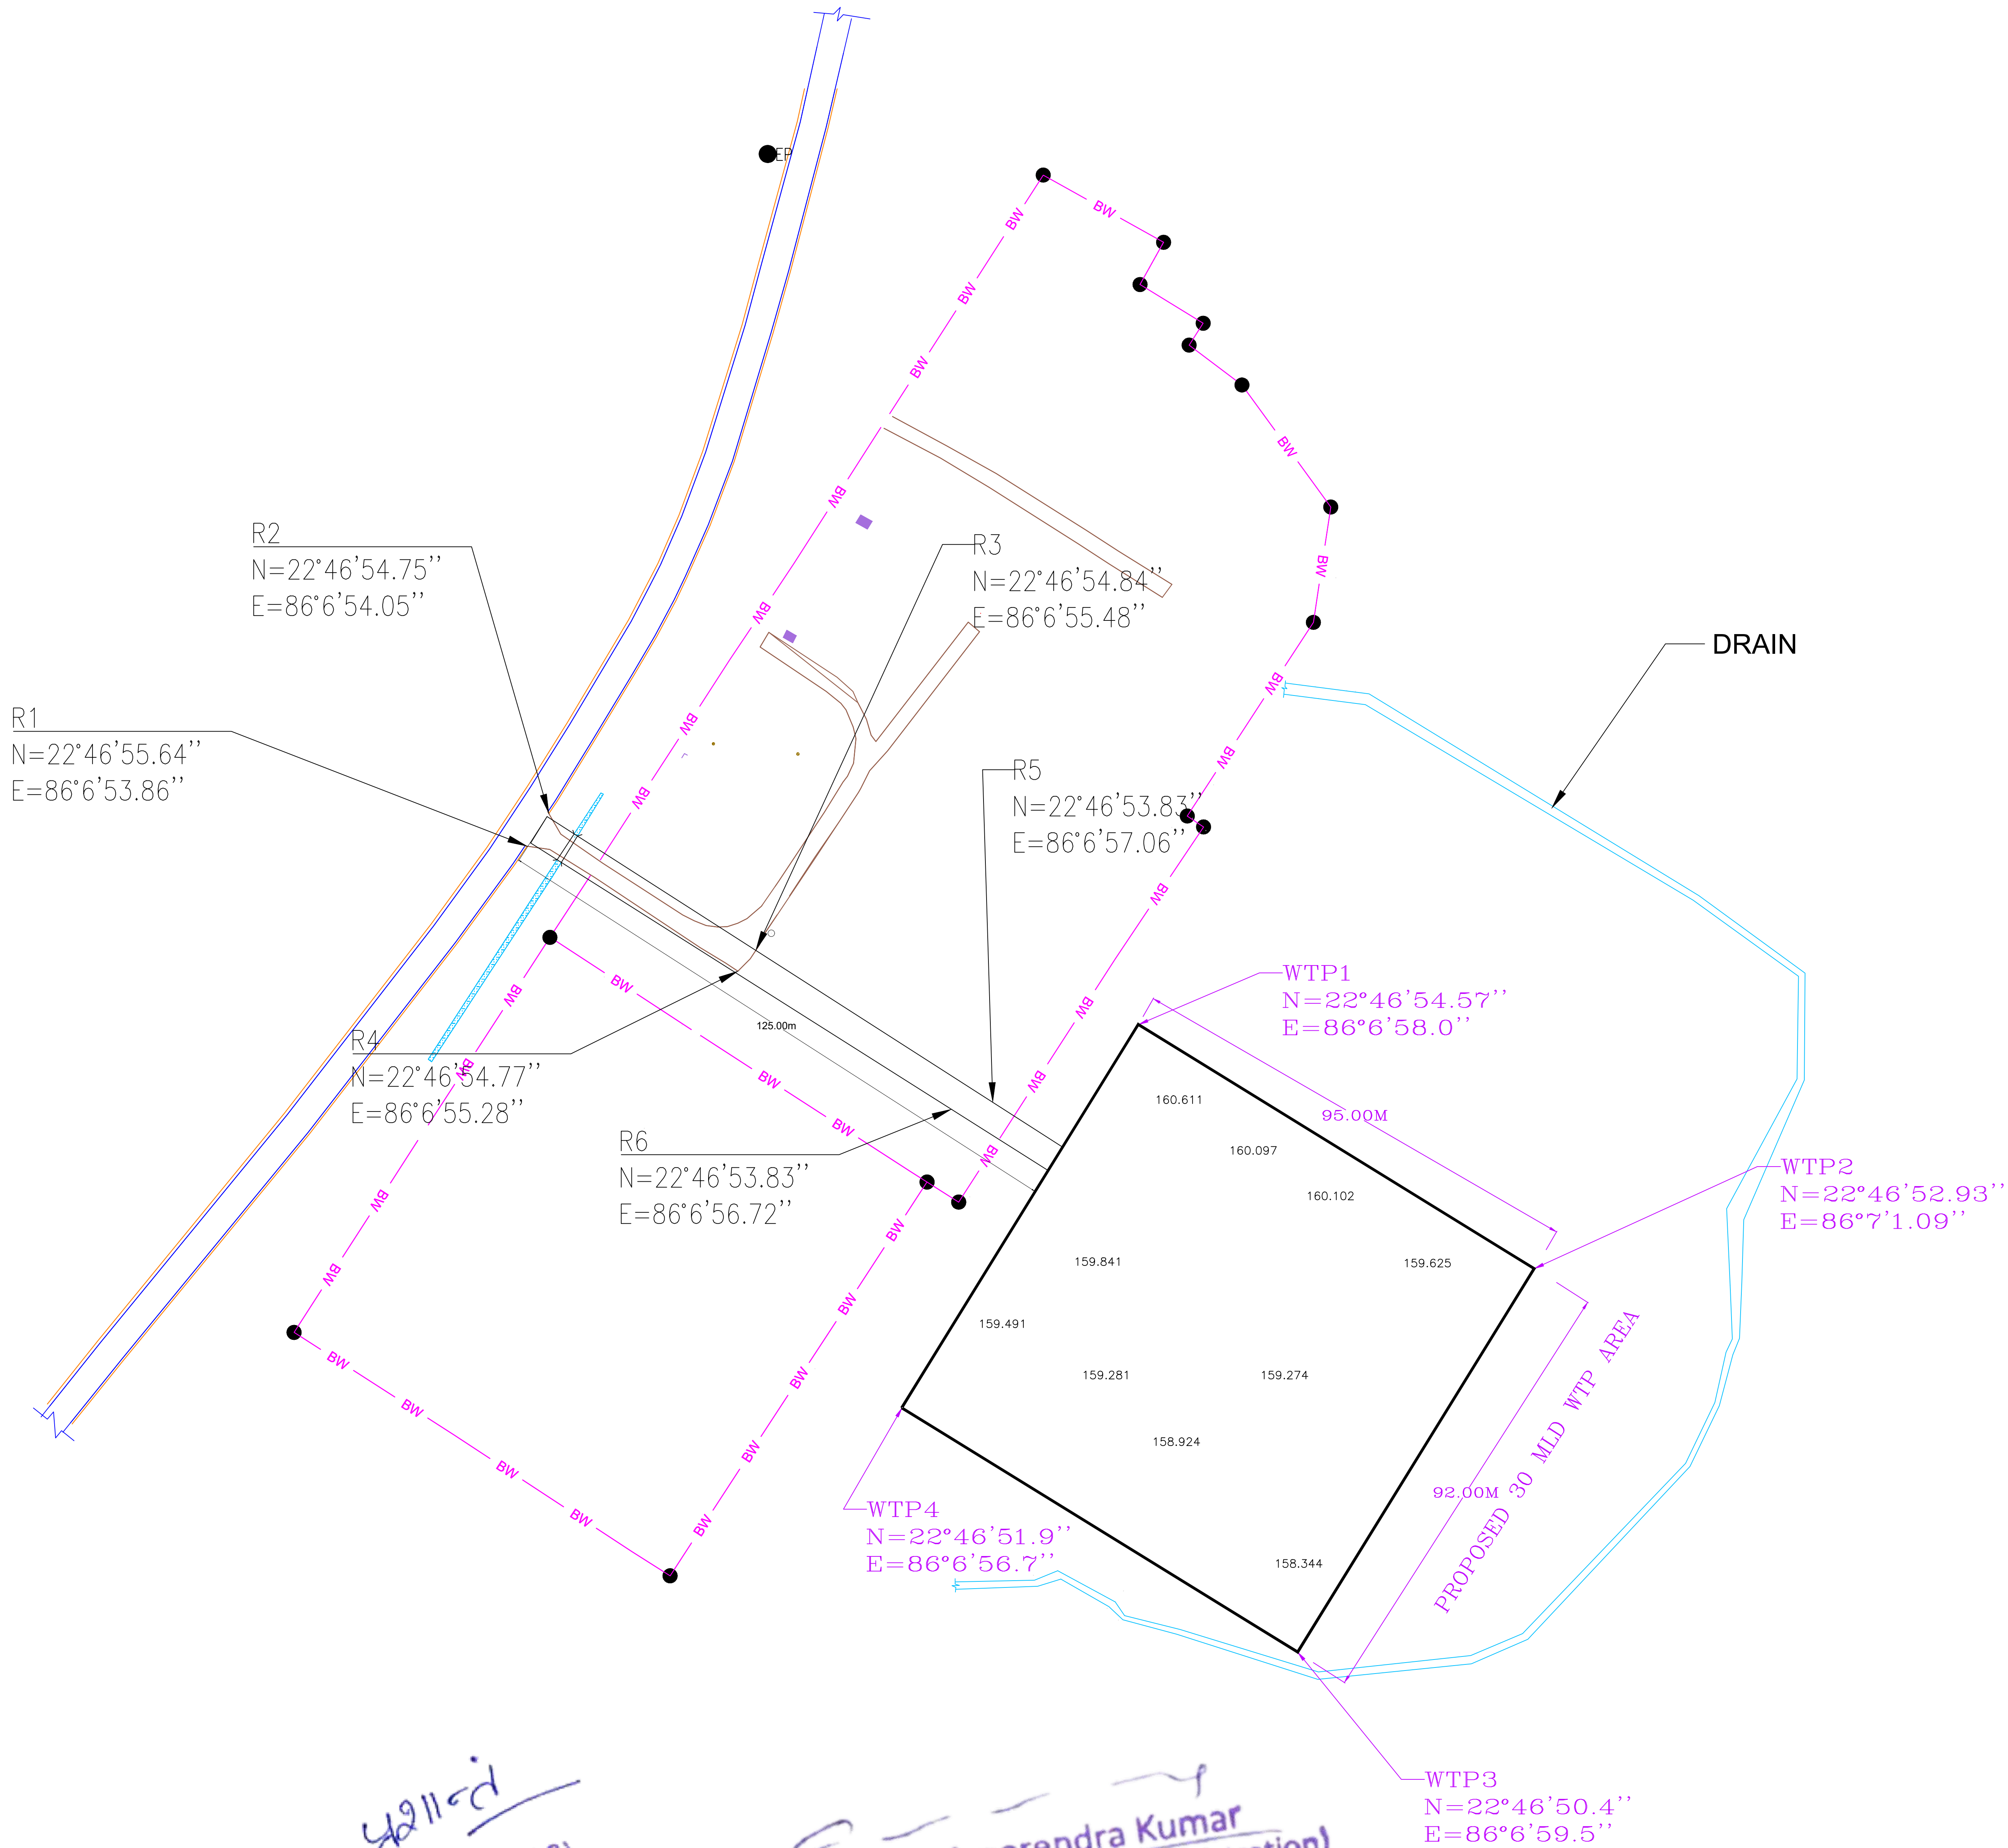


Note:-
1. All dimensions are in Mtr. unless otherwise stated.
2. All levels are in reference to Irrigation Dept. Bench Mark of RL =124.250m Carried from Sluice gate barrel top located At 300m west at Adityapur Toll Bridge on the left Bank of Kharkai River (DECK).

REFERENCES	
1. SITE PLAN	
2. WATER MAIN	
3. SANITARY MAIN	
4. SEWER MAIN	
5. DRAINAGE MAIN	
6. FLOOD MAIN	
7. ROAD MAIN	
8. RAIL MAIN	
9. AIR MAIN	
10. TELEPHONE MAIN	
11. POWER MAIN	
12. GAS MAIN	
13. STEAM MAIN	
14. HOT WATER MAIN	
15. COLD WATER MAIN	
16. WASTE WATER MAIN	
17. SEWAGE MAIN	
18. DRAINAGE MAIN	
19. FLOOD MAIN	
20. ROAD MAIN	
21. RAIL MAIN	
22. AIR MAIN	
23. TELEPHONE MAIN	
24. POWER MAIN	
25. GAS MAIN	
26. STEAM MAIN	
27. HOT WATER MAIN	
28. COLD WATER MAIN	
29. WASTE WATER MAIN	
30. SEWAGE MAIN	
31. DRAINAGE MAIN	
32. FLOOD MAIN	
33. ROAD MAIN	
34. RAIL MAIN	
35. AIR MAIN	
36. TELEPHONE MAIN	
37. POWER MAIN	
38. GAS MAIN	
39. STEAM MAIN	
40. HOT WATER MAIN	
41. COLD WATER MAIN	
42. WASTE WATER MAIN	
43. SEWAGE MAIN	
44. DRAINAGE MAIN	
45. FLOOD MAIN	
46. ROAD MAIN	
47. RAIL MAIN	
48. AIR MAIN	
49. TELEPHONE MAIN	
50. POWER MAIN	
51. GAS MAIN	
52. STEAM MAIN	
53. HOT WATER MAIN	
54. COLD WATER MAIN	
55. WASTE WATER MAIN	
56. SEWAGE MAIN	
57. DRAINAGE MAIN	
58. FLOOD MAIN	
59. ROAD MAIN	
60. RAIL MAIN	
61. AIR MAIN	
62. TELEPHONE MAIN	
63. POWER MAIN	
64. GAS MAIN	
65. STEAM MAIN	
66. HOT WATER MAIN	
67. COLD WATER MAIN	
68. WASTE WATER MAIN	
69. SEWAGE MAIN	
70. DRAINAGE MAIN	
71. FLOOD MAIN	
72. ROAD MAIN	
73. RAIL MAIN	
74. AIR MAIN	
75. TELEPHONE MAIN	
76. POWER MAIN	
77. GAS MAIN	
78. STEAM MAIN	
79. HOT WATER MAIN	
80. COLD WATER MAIN	
81. WASTE WATER MAIN	
82. SEWAGE MAIN	
83. DRAINAGE MAIN	
84. FLOOD MAIN	
85. ROAD MAIN	
86. RAIL MAIN	
87. AIR MAIN	
88. TELEPHONE MAIN	
89. POWER MAIN	
90. GAS MAIN	
91. STEAM MAIN	
92. HOT WATER MAIN	
93. COLD WATER MAIN	
94. WASTE WATER MAIN	
95. SEWAGE MAIN	
96. DRAINAGE MAIN	
97. FLOOD MAIN	
98. ROAD MAIN	
99. RAIL MAIN	
100. AIR MAIN	
101. TELEPHONE MAIN	
102. POWER MAIN	
103. GAS MAIN	
104. STEAM MAIN	
105. HOT WATER MAIN	
106. COLD WATER MAIN	
107. WASTE WATER MAIN	
108. SEWAGE MAIN	
109. DRAINAGE MAIN	
110. FLOOD MAIN	
111. ROAD MAIN	
112. RAIL MAIN	
113. AIR MAIN	
114. TELEPHONE MAIN	
115. POWER MAIN	
116. GAS MAIN	
117. STEAM MAIN	
118. HOT WATER MAIN	
119. COLD WATER MAIN	
120. WASTE WATER MAIN	
121. SEWAGE MAIN	
122. DRAINAGE MAIN	
123. FLOOD MAIN	
124. ROAD MAIN	
125. RAIL MAIN	
126. AIR MAIN	
127. TELEPHONE MAIN	
128. POWER MAIN	
129. GAS MAIN	
130. STEAM MAIN	
131. HOT WATER MAIN	
132. COLD WATER MAIN	
133. WASTE WATER MAIN	
134. SEWAGE MAIN	
135. DRAINAGE MAIN	
136. FLOOD MAIN	
137. ROAD MAIN	
138. RAIL MAIN	
139. AIR MAIN	
140. TELEPHONE MAIN	
141. POWER MAIN	
142. GAS MAIN	
143. STEAM MAIN	
144. HOT WATER MAIN	
145. COLD WATER MAIN	
146. WASTE WATER MAIN	
147. SEWAGE MAIN	
148. DRAINAGE MAIN	
149. FLOOD MAIN	
150. ROAD MAIN	
151. RAIL MAIN	
152. AIR MAIN	
153. TELEPHONE MAIN	
154. POWER MAIN	
155. GAS MAIN	
156. STEAM MAIN	
157. HOT WATER MAIN	
158. COLD WATER MAIN	
159. WASTE WATER MAIN	
160. SEWAGE MAIN	
161. DRAINAGE MAIN	
162. FLOOD MAIN	
163. ROAD MAIN	
164. RAIL MAIN	
165. AIR MAIN	
166. TELEPHONE MAIN	
167. POWER MAIN	
168. GAS MAIN	
169. STEAM MAIN	
170. HOT WATER MAIN	
171. COLD WATER MAIN	
172. WASTE WATER MAIN	
173. SEWAGE MAIN	
174. DRAINAGE MAIN	
175. FLOOD MAIN	
176. ROAD MAIN	
177. RAIL MAIN	
178. AIR MAIN	
179. TELEPHONE MAIN	
180. POWER MAIN	
181. GAS MAIN	
182. STEAM MAIN	
183. HOT WATER MAIN	
184. COLD WATER MAIN	
185. WASTE WATER MAIN	
186. SEWAGE MAIN	
187. DRAINAGE MAIN	
188. FLOOD MAIN	
189. ROAD MAIN	
190. RAIL MAIN	
191. AIR MAIN	
192. TELEPHONE MAIN	
193. POWER MAIN	
194. GAS MAIN	
195. STEAM MAIN	
196. HOT WATER MAIN	
197. COLD WATER MAIN	
198. WASTE WATER MAIN	
199. SEWAGE MAIN	
200. DRAINAGE MAIN	
201. FLOOD MAIN	
202. ROAD MAIN	
203. RAIL MAIN	
204. AIR MAIN	
205. TELEPHONE MAIN	
206. POWER MAIN	
207. GAS MAIN	
208. STEAM MAIN	
209. HOT WATER MAIN	
210. COLD WATER MAIN	
211. WASTE WATER MAIN	
212. SEWAGE MAIN	
213. DRAINAGE MAIN	
214. FLOOD MAIN	
215. ROAD MAIN	
216. RAIL MAIN	
217. AIR MAIN	
218. TELEPHONE MAIN	
219. POWER MAIN	
220. GAS MAIN	
221. STEAM MAIN	
222. HOT WATER MAIN	
223. COLD WATER MAIN	
224. WASTE WATER MAIN	
225. SEWAGE MAIN	
226. DRAINAGE MAIN	
227. FLOOD MAIN	
228. ROAD MAIN	
229. RAIL MAIN	
230. AIR MAIN	
231. TELEPHONE MAIN	
232. POWER MAIN	
233. GAS MAIN	
234. STEAM MAIN	
235. HOT WATER MAIN	
236. COLD WATER MAIN	
237. WASTE WATER MAIN	
238. SEWAGE MAIN	
239. DRAINAGE MAIN	
240. FLOOD MAIN	
241. ROAD MAIN	
242. RAIL MAIN	
243. AIR MAIN	
244. TELEPHONE MAIN	
245. POWER MAIN	
246. GAS MAIN	
247. STEAM MAIN	
248. HOT WATER MAIN	
249. COLD WATER MAIN	
250. WASTE WATER MAIN	
251. SEWAGE MAIN	
252. DRAINAGE MAIN	
253. FLOOD MAIN	
254. ROAD MAIN	
255. RAIL MAIN	
256. AIR MAIN	
257. TELEPHONE MAIN	
258. POWER MAIN	
259. GAS MAIN	
260. STEAM MAIN	
261. HOT WATER MAIN	
262. COLD WATER MAIN	
263. WASTE WATER MAIN	
264. SEWAGE MAIN	
265. DRAINAGE MAIN	
266. FLOOD MAIN	
267. ROAD MAIN	
268. RAIL MAIN	
269. AIR MAIN	
270. TELEPHONE MAIN	
271. POWER MAIN	
272. GAS MAIN	
273. STEAM MAIN	
274. HOT WATER MAIN	
275. COLD WATER MAIN	
276. WASTE WATER MAIN	
277. SEWAGE MAIN	
278. DRAINAGE MAIN	
279. FLOOD MAIN	
280. ROAD MAIN	
281. RAIL MAIN	
282. AIR MAIN	
283. TELEPHONE MAIN	
284. POWER MAIN	
285. GAS MAIN	
286. STEAM MAIN	
287. HOT WATER MAIN	
288. COLD WATER MAIN	
289. WASTE WATER MAIN	
290. SEWAGE MAIN	
291. DRAINAGE MAIN	
292. FLOOD MAIN	
293. ROAD MAIN	
294. RAIL MAIN	
295. AIR MAIN	
296. TELEPHONE MAIN	
297. POWER MAIN	
298. GAS MAIN	
299. STEAM MAIN	
300. HOT WATER MAIN	
301. COLD WATER MAIN	
302. WASTE WATER MAIN	
303. SEWAGE MAIN	
304. DRAINAGE MAIN	
305. FLOOD MAIN	
306. ROAD MAIN	
307. RAIL MAIN	
308. AIR MAIN	
309. TELEPHONE MAIN	
310. POWER MAIN	
311. GAS MAIN	
312. STEAM MAIN	
313. HOT WATER MAIN	
314. COLD WATER MAIN	
315. WASTE WATER MAIN	
316. SEWAGE MAIN	
317. DRAINAGE MAIN	
318. FLOOD MAIN	
319. ROAD MAIN	
320. RAIL MAIN	
321. AIR MAIN	
322. TELEPHONE MAIN	
323. POWER MAIN	
324. GAS MAIN	
325. STEAM MAIN	
326. HOT WATER MAIN	
327. COLD WATER MAIN	
328. WASTE WATER MAIN	
329. SEWAGE MAIN	
330. DRAINAGE MAIN	
331. FLOOD MAIN	
332. ROAD MAIN	
333. RAIL MAIN	
334. AIR MAIN	
335. TELEPHONE MAIN	
336. POWER MAIN	
337. GAS MAIN	
338. STEAM MAIN	
339. HOT WATER MAIN	
340. COLD WATER MAIN	
341. WASTE WATER MAIN	
342. SEWAGE MAIN	
343. DRAINAGE MAIN	
344. FLOOD MAIN	
345. ROAD MAIN	
346. RAIL MAIN	
347. AIR MAIN	
348. TELEPHONE MAIN	
349. POWER MAIN	
350. GAS MAIN	
351. STEAM MAIN	
352. HOT WATER MAIN	
353. COLD WATER MAIN	
354. WASTE WATER MAIN	
355. SEWAGE MAIN	
356. DRAINAGE MAIN	
357. FLOOD MAIN	
358. ROAD MAIN	
359. RAIL MAIN	
360. AIR MAIN	
361. TELEPHONE MAIN	
362. POWER MAIN	
363. GAS MAIN	
364. STEAM MAIN	
365. HOT WATER MAIN	
366. COLD WATER MAIN	
367. WASTE WATER MAIN	
368. SEWAGE MAIN	
369. DRAINAGE MAIN	
370. FLOOD MAIN	
371. ROAD MAIN	
372. RAIL MAIN	
373. AIR MAIN	
374. TELEPHONE MAIN	
375. POWER MAIN	
376. GAS MAIN	
377. STEAM MAIN	
378. HOT WATER MAIN	
379. COLD WATER MAIN	
380. WASTE WATER MAIN	
381. SEWAGE MAIN	
382. DRAINAGE MAIN	
383. FLOOD MAIN	
384. ROAD MAIN	
385. RAIL MAIN	
386. AIR MAIN	
387. TELEPHONE MAIN	
388. POWER MAIN	
389. GAS MAIN	
390. STEAM MAIN	
391. HOT WATER MAIN	
392. COLD WATER MAIN	
393. WASTE WATER MAIN	
394. SEWAGE MAIN	
395. DRAINAGE MAIN	
396. FLOOD MAIN	
397. ROAD MAIN	
398. RAIL MAIN	
399. AIR MAIN	
400. TELEPHONE MAIN	
401. POWER MAIN	
402. GAS MAIN	
403. STEAM MAIN	
404. HOT WATER MAIN	
405. COLD WATER MAIN	
406. WASTE WATER MAIN	
407. SEWAGE MAIN	
408. DRAINAGE MAIN	
409. FLOOD MAIN	
410. ROAD MAIN	
411. RAIL MAIN	
412. AIR MAIN	
413. TELEPHONE MAIN	
414. POWER MAIN	
415. GAS MAIN	
416. STEAM MAIN	
417. HOT WATER MAIN	
418. COLD WATER MAIN	
419. WASTE WATER MAIN	
420. SEWAGE MAIN	
421. DRAINAGE MAIN	
422. FLOOD MAIN	
423. ROAD MAIN	
424. RAIL MAIN	
425. AIR MAIN	
426. TELEPHONE MAIN	
427. POWER MAIN	
428. GAS MAIN	
429. STEAM MAIN	
430. HOT WATER MAIN	
431. COLD WATER MAIN	
432. WASTE WATER MAIN	
433. SEWAGE MAIN	
434. DRAINAGE MAIN	
435. FLOOD MAIN	
436. ROAD MAIN	
437. RAIL MAIN	
438. AIR MAIN	
439. TELEPHONE MAIN	
440. POWER MAIN	
441. GAS MAIN	
442. STEAM MAIN	
443. HOT WATER MAIN	
444. COLD WATER MAIN	
445. WASTE WATER MAIN	
446. SEWAGE MAIN	
447. DRAINAGE MAIN	
448. FLOOD MAIN	
449. ROAD MAIN	
450. RAIL MAIN	
451. AIR MAIN	
452. TELEPHONE MAIN	
453. POWER MAIN	
454. GAS MAIN	
455. STEAM MAIN	
456. HOT WATER MAIN	
457. COLD WATER MAIN	
458. WASTE WATER MAIN	
459. SEWAGE MAIN	
460. DRAINAGE MAIN	
461. FLOOD MAIN	
462. ROAD MAIN	
463. RAIL MAIN	
464. AIR MAIN	
465. TELEPHONE MAIN	
466. POWER MAIN	
467. GAS MAIN	
468. STEAM MAIN	
469. HOT WATER MAIN	
470. COLD WATER MAIN	
471. WASTE WATER MAIN	
472. SEWAGE MAIN	
473. DRAINAGE MAIN	
474. FLOOD MAIN	
475. ROAD MAIN	
476. RAIL MAIN	
477. AIR MAIN	
478. TELEPHONE MAIN	
479. POWER MAIN	
480. GAS MAIN	
481. STEAM MAIN	
482. HOT WATER MAIN	
483. COLD WATER MAIN	
484. WASTE WATER MAIN	
485. SEWAGE MAIN	
486. DRAINAGE MAIN	
487. FLOOD MAIN	
488. ROAD MAIN	
489. RAIL MAIN	
490. AIR MAIN	
491. TELEPHONE MAIN	
492. POWER MAIN	
493. GAS MAIN	
494. STEAM MAIN	
495. HOT WATER MAIN	
496. COLD WATER MAIN	
497. WASTE WATER MAIN	
498. SEWAGE MAIN	
499. DRAINAGE MAIN	
500. FLOOD MAIN	
501. ROAD MAIN	
502. RAIL MAIN	
503. AIR MAIN	
504. TELEPHONE MAIN	
505. POWER MAIN	
506. GAS MAIN	
507. STEAM MAIN	
508. HOT WATER MAIN	
509. COLD WATER MAIN	
510. WASTE WATER MAIN	
511. SEWAGE MAIN	
512. DRAINAGE MAIN	
513. FLOOD MAIN	
514. ROAD MAIN	
515. RAIL MAIN	
516. AIR MAIN	
517. TELEPHONE MAIN	
518. POWER MAIN	
519. GAS MAIN	
520. STEAM MAIN	
521. HOT WATER MAIN	
522. COLD WATER MAIN	
523. WASTE WATER MAIN	
524. SEWAGE MAIN	
525. DRAINAGE MAIN	
526. FLOOD MAIN	
527. ROAD MAIN	
528. RAIL MAIN	
529. AIR MAIN	
530. TELEPHONE MAIN	
531. POWER MAIN	
532. GAS MAIN	
533. STEAM MAIN	
534. HOT WATER MAIN	
535. COLD WATER MAIN	
536. WASTE WATER MAIN	
537. SEWAGE MAIN	
538. DRAINAGE MAIN	
539. FLOOD MAIN	
540. ROAD MAIN	
541. RAIL MAIN	
542. AIR MAIN	
543. TELEPHONE MAIN	
544. POWER MAIN	
545. GAS MAIN	
546. STEAM MAIN	
547. HOT WATER MAIN	
548. COLD WATER MAIN	
549. WASTE WATER MAIN	
550. SEWAGE MAIN	
551. DRAINAGE MAIN	
552. FLOOD MAIN	
553. ROAD MAIN	
554. RAIL MAIN	
555. AIR MAIN	
556. TELEPHONE MAIN	
557. POWER MAIN	
558. GAS MAIN	
559. STEAM MAIN	
560. HOT WATER MAIN	
561. COLD WATER MAIN	
562. WASTE WATER MAIN	
563. SEWAGE MAIN	
564. DRAINAGE MAIN	
565. FLOOD MAIN	
566. ROAD MAIN	
567. RAIL MAIN	
568. AIR MAIN	
569. TELEPHONE MAIN	
570. POWER MAIN	
571. GAS MAIN	
572. STEAM MAIN	
573. HOT WATER MAIN	
574. COLD WATER MAIN	
575. WASTE WATER MAIN	
576. SEWAGE MAIN	
577. DRAINAGE MAIN	
578. FLOOD MAIN	
579. ROAD MAIN	
580. RAIL MAIN	
581. AIR MAIN	
582. TELEPHONE MAIN	
583. POWER MAIN	
584. GAS MAIN	
585. STEAM MAIN	
586. HOT WATER MAIN	
587. COLD WATER MAIN	
588. WASTE WATER MAIN	
589. SEWAGE MAIN	
590. DRAINAGE MAIN	
591. FLOOD MAIN	
592. ROAD MAIN	
593. RAIL MAIN	</

G.L.S.R. CUM
M.B.R. AT WARD-9

East = 86°-8'-21.09"
North = 22°-46'-59.83"

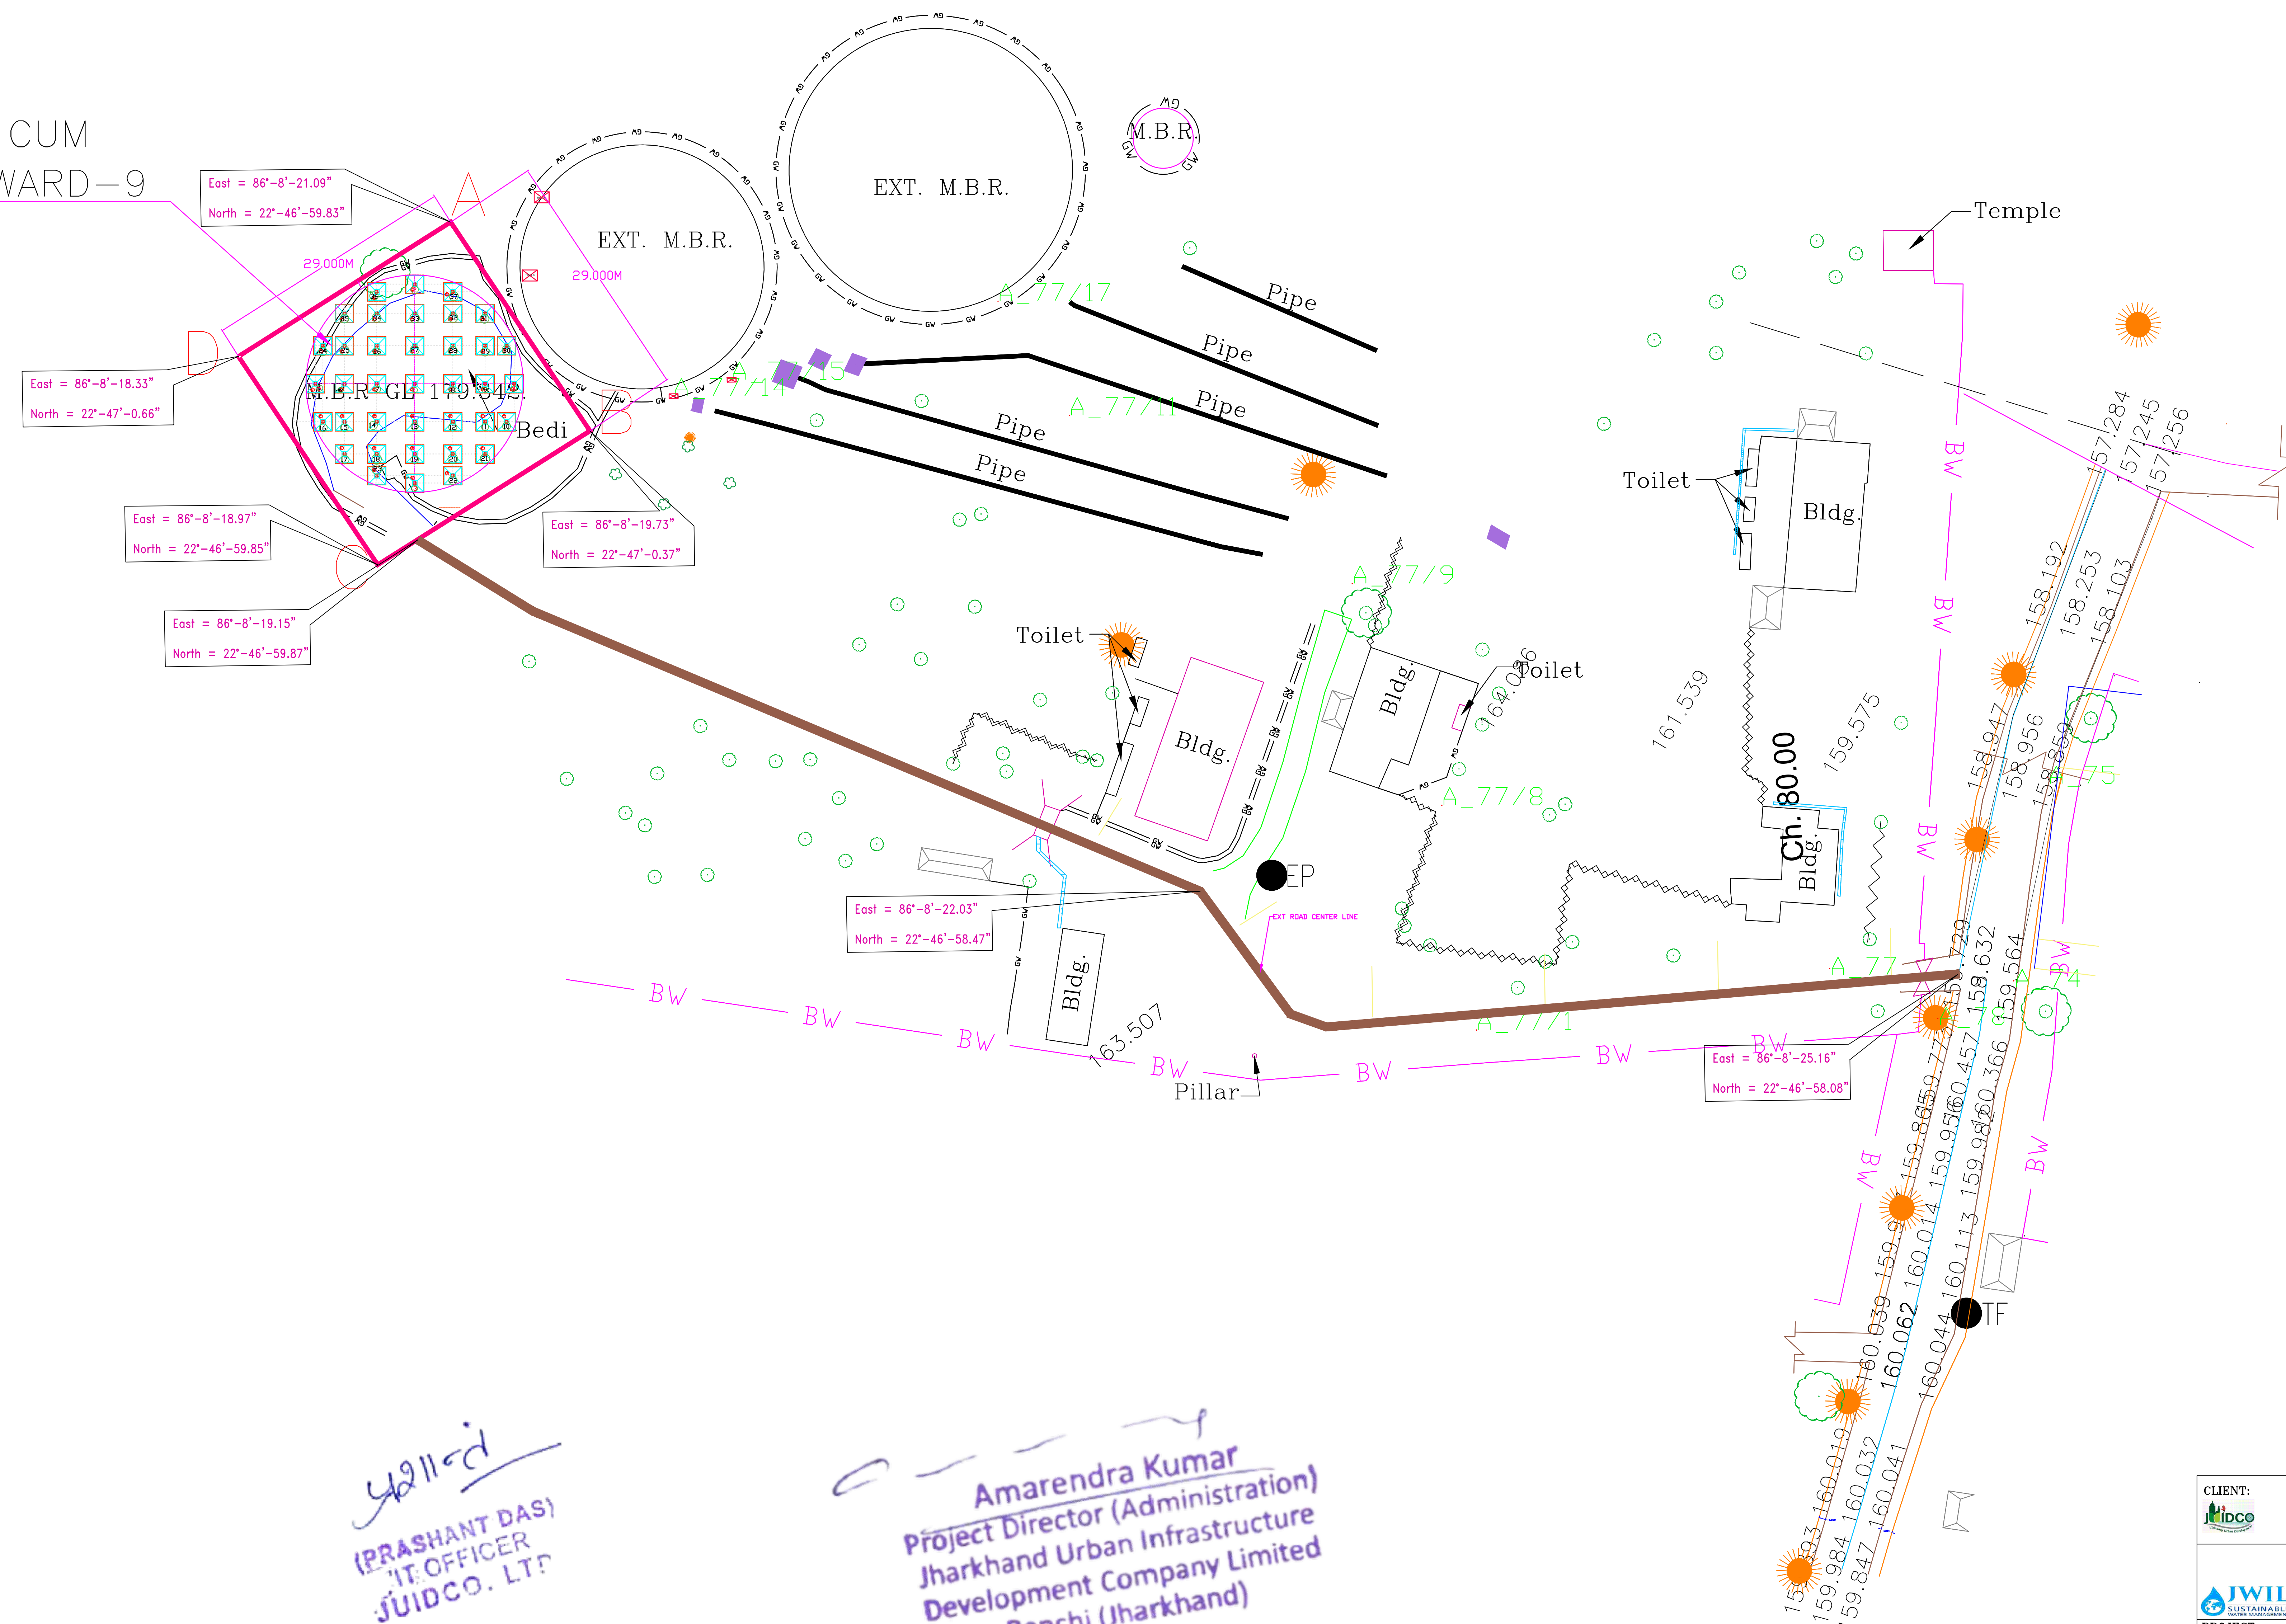

421101
(PRASHANT DAS)
IT OFFICER
JUIDCO. LTD


Amarendra Kumar
Project Director (Administration)
Jharkhand Urban Infrastructure
Development Company Limited
Ranchi (Jharkhand)

APPENDIX 1		
1. DIFFERENCE FROM OTHERS	1	
2. WALKED INTO DEPTHS	2	
3. FRODO BAGGINS	3	
4. KATIE'S MOM ALWAYS SAYS	4	
5. HONOLULU	5	
6. PLANT	6	
7. FRODO BAGGINS	7	
8. FRODO BAGGINS	8	
9. FRODO BAGGINS	9	
10. FRODO BAGGINS	10	
11. FRODO BAGGINS	11	
12. FRODO BAGGINS	12	
13. FRODO BAGGINS	13	
14. FRODO BAGGINS	14	
15. FRODO BAGGINS	15	
16. FRODO BAGGINS	16	
17. FRODO BAGGINS	17	
18. FRODO BAGGINS	18	
19. FRODO BAGGINS	19	
20. FRODO BAGGINS	20	
21. FRODO BAGGINS	21	
22. FRODO BAGGINS	22	
23. FRODO BAGGINS	23	
24. FRODO BAGGINS	24	
25. FRODO BAGGINS	25	
26. FRODO BAGGINS	26	
27. FRODO BAGGINS	27	
28. FRODO BAGGINS	28	
29. FRODO BAGGINS	29	
30. FRODO BAGGINS	30	
31. FRODO BAGGINS	31	
32. FRODO BAGGINS	32	
33. FRODO BAGGINS	33	
34. FRODO BAGGINS	34	
35. FRODO BAGGINS	35	
36. FRODO BAGGINS	36	
37. FRODO BAGGINS	37	
38. FRODO BAGGINS	38	
39. FRODO BAGGINS	39	
40. FRODO BAGGINS	40	
41. FRODO BAGGINS	41	
42. FRODO BAGGINS	42	
43. FRODO BAGGINS	43	
44. FRODO BAGGINS	44	
45. FRODO BAGGINS	45	
46. FRODO BAGGINS	46	
47. FRODO BAGGINS	47	
48. FRODO BAGGINS	48	
49. FRODO BAGGINS	49	
50. FRODO BAGGINS	50	

CLIENT:  PROJECT MANAGER JUIDCO LIMITED, RANCHI									
M/S JWIL – SPML (JV) 28 SHIVAJI MARG NEW DELHI – 1100015									
 									
PROJECT: AUGMENTATION AND STRENGTHNING OF ADITYAPUR WATER SUPPLY SCHEME									
TITLE: PROPOSED MBR LOCATION DETAILS									
DRG. NO.: JWIL/2018/ADITYAPUR/170									
R2	1 OF 1	SIZE : A1	23.12.2020						
REV.	SHEET	SCALE	DATE	DRN.	CHKD.	APPD.			

PROPOSED OHT-1

LOCATION- JAMALPUR

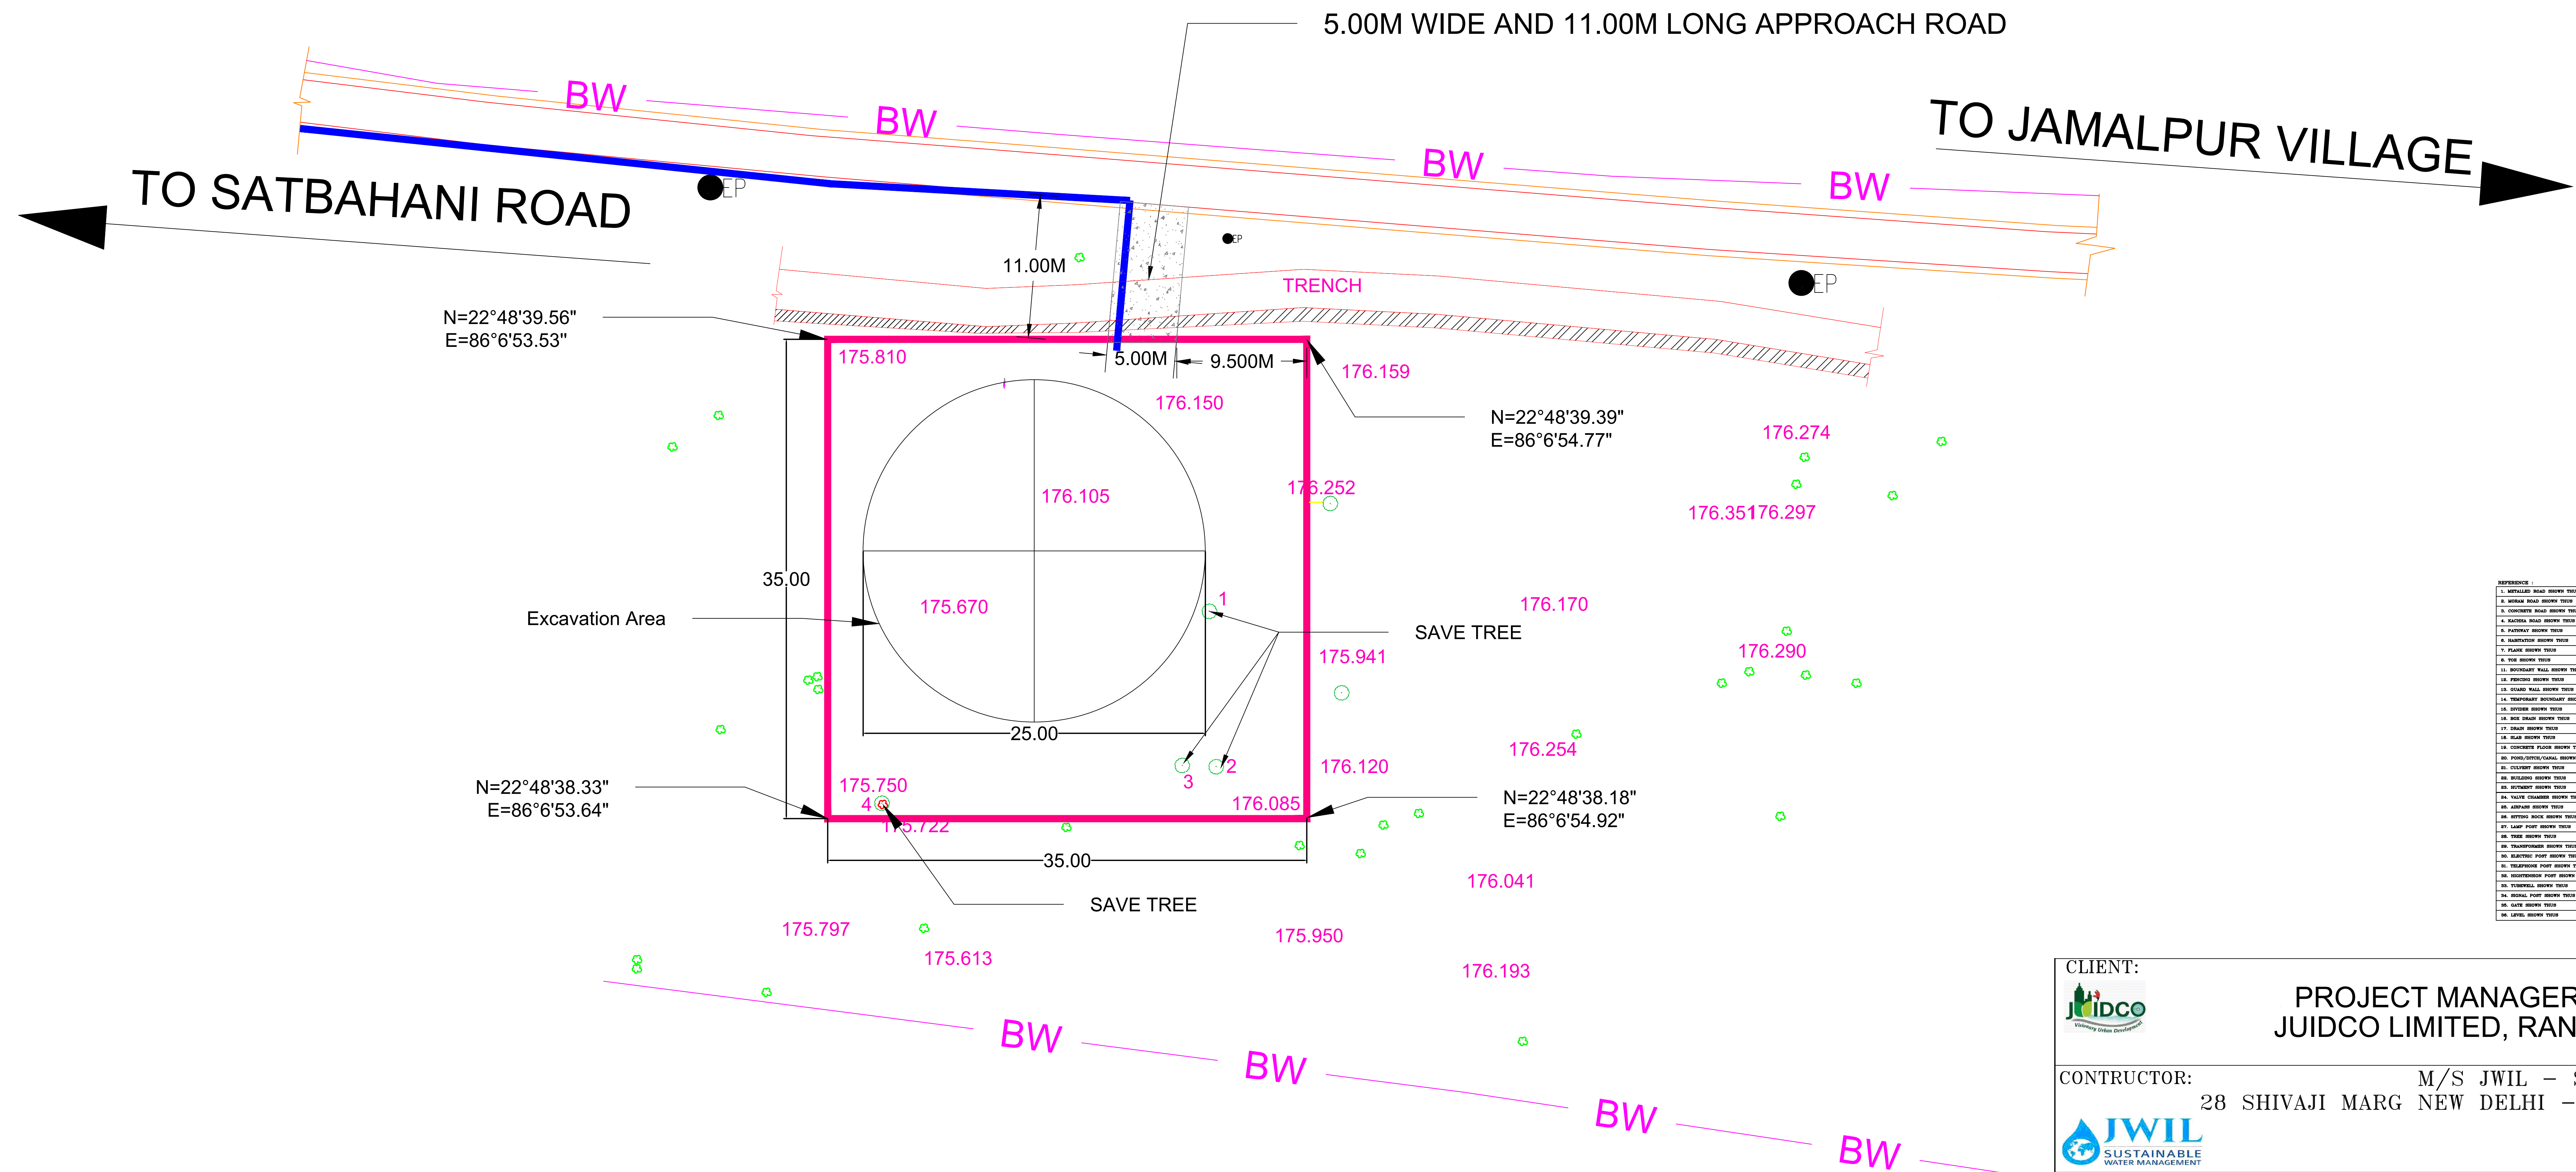

REFERENCE	
1. EXISTING ROAD	
2. EXISTING ROAD	
3. EXISTING ROAD	
100. EXISTING ROAD	

Amarendra Kumar
Project Director (Administration)
Jharkhand Urban Infrastructure
Development Company Limited
Ranchi (Jharkhand)

CLIENT:	PROJECT MANAGER JUIDCO LIMITED, RANCHI
CONTRACTOR:	M/S JWIL - SPML (JV) 28 SHIVAJI MARG NEW DELHI - 1100015
PROJECT:	AUGMENTATION AND STRENGTHNING OF ADITYAPUR WATER SUPPLY SCHEME
TITLE:	PROPOSED OHT-1 LOCATION DETAILS
DRG. NO.:	JWIL/2018/ADITYAPUR/170
REV.	R2
SHEET	1 OF 1
SCALE	A1
DATE	23.12.2020
AV	HB
DRN.	CHKD.
APPD.	DB

