


**NOTES:-**  
 1. 40MM DIA VENT PIPE 4.0 M HIGH & 4.0 M CLEAR ALLROUND FITTED WITH TWO LAYER OF NON CORRODABLE WIRE GAUGE OF 11 MESH LINER CM SQUARE.  
 2. FILL POINT FITTED WITH CAM LOCK COUPLINGS & AIR TIGHT THREADED BRASS CAP DECAINTING FROM TANK LORRY.  
 3. DIP PIPE WITH CAP ASSEMBLY.  
 4. ALL THE DOORS OF BUILDING TO BE OPENED OUTWARDLY.  
 5. NO SEWER OR SURFACE DRAIN WITH IN 6 MTR FORM U.G TANK & D.U.S.  
 6. PREMISES TO BE USED ONLY FOR STORAGE OF PETROLEUM PRODUCTS.  
 7. TANK ARE PAINTED WITH TWO LAYER OF HOT BITUMEN OVER TWO COATS OF RED LID PRIMER TO PROTECT AGAINST CORROSION.  
 8. FABRICATION OF U.G STORAGE TANK ARE CONFORMING TO IS 10987:1998 AS PER CCOE NAGPUR ORDER NO G-40/SC/PMSC - 84 DATED 24-02-1999.  
 10. ALL DIMENSIONS ARE IN MTRS.  
 11. 50% SAND BUCKETS TO NO AS PER EXPLOSIVE RULES.  
 12. FIRE EXTINGUISHERS TO NO AS PER EXPLOSIVE RULES.  
 13. TANK SHOULD BE GIVEN HYDRAULIC PRESSURE TEST TO BEFORE INSTALLATION AND BEFORE ANY PROTECTIVE COATING IS APPLIED THE TEST SHOULD BE MENTION AT A CONTROLL PRESSURE OF 0.38 KG/CM<sup>2</sup> FOR TWO HOURS.  
 14. DIP ROAD SUPPLIED WITH THE TANK FOR THIS TYPE OF INSTALLATION SHOULD BE 3200 LONG.  
 15. FABRICATION THICKNESS OF TANK SHELL PLATES AND END PLATES: 20KL SHELL - 6MM, END - 6MM  
 16. TANK CONFORM TO CLAUSE 124.125&131 OF PETROLEUM RULES 2002.  
 17. ALL LIGHT POLES FITTED AS PER APPROVALS OF CCOE NAGPUR VIDE LETTER NO-FUI/MB-1 DATED 25.11.03.  
 18. NATURAL DOWN SLOPE FROM EDGE OF THE ROAD TO CULVERT ON APPROACHES WILL BE MENTION FREE FLOW OF WATER TOWARDS DRAIN.  
 19. SITES MEETS APPLICABLES PER IRC NORMS 1983 WITH LATEST AMENDMENTS.  
 20. E.V. EXTENDED VENT PIPE.  
 21. E.F. EXTENDED FILL POINT.  
 22. NO HIGH TENSION LINE IS PASSING OVER THE SITE.  
 23. THE PROPOSED SITE IS FREE FROM ANY TYPE OF LITIGATION AND NO CASE IS PENDING IN ANY COURT OF LAW.  
 24. ALL NECESSARY APPROVALS FROM CONCERN DEPARTMENT TO BE OBTAINED.

### SIGN & SYMBOLS

|     |                                   |
|-----|-----------------------------------|
| (A) | FUEL STATION AHEAD<br>1 KM & 500M |
| (B) | FUEL STATION                      |
| (C) | FUEL STATION AHEAD                |
| (D) | GIVE WAY                          |
| (E) | ONE WAY                           |
| (F) | NO ENTRY                          |
| (G) | COMPULSORY DIRECTION BOARD        |
| (H) | NO RIGHT TURN                     |
| (I) | NO LEFT TURN                      |
| (J) | FUEL STATION BOARD                |

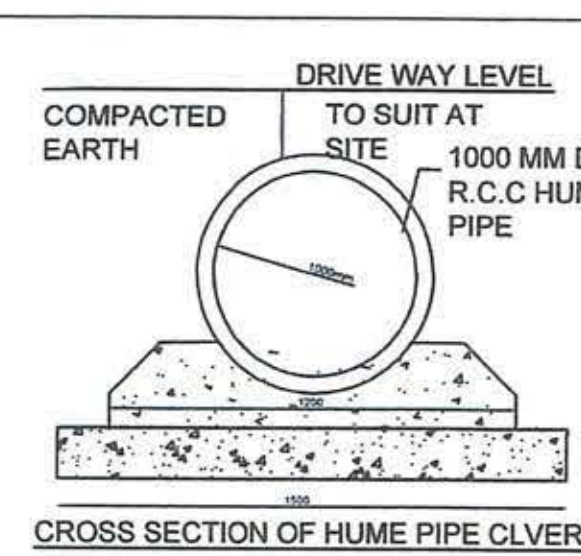


### AREA CHART

|                                      |            |
|--------------------------------------|------------|
| PROPOSED CONSTRUCTION AREA (40Mx40M) | 1600 SQM   |
| SALES BUILDING AREA                  | 36.19 SQM  |
| CANOPY AREA                          | 242.00 SQM |


### REFERENCE

|                       |  |
|-----------------------|--|
| PROPOSED CONSTRUCTION |  |
| PROPOSED DRAIN        |  |
| OTHER'S LAND          |  |

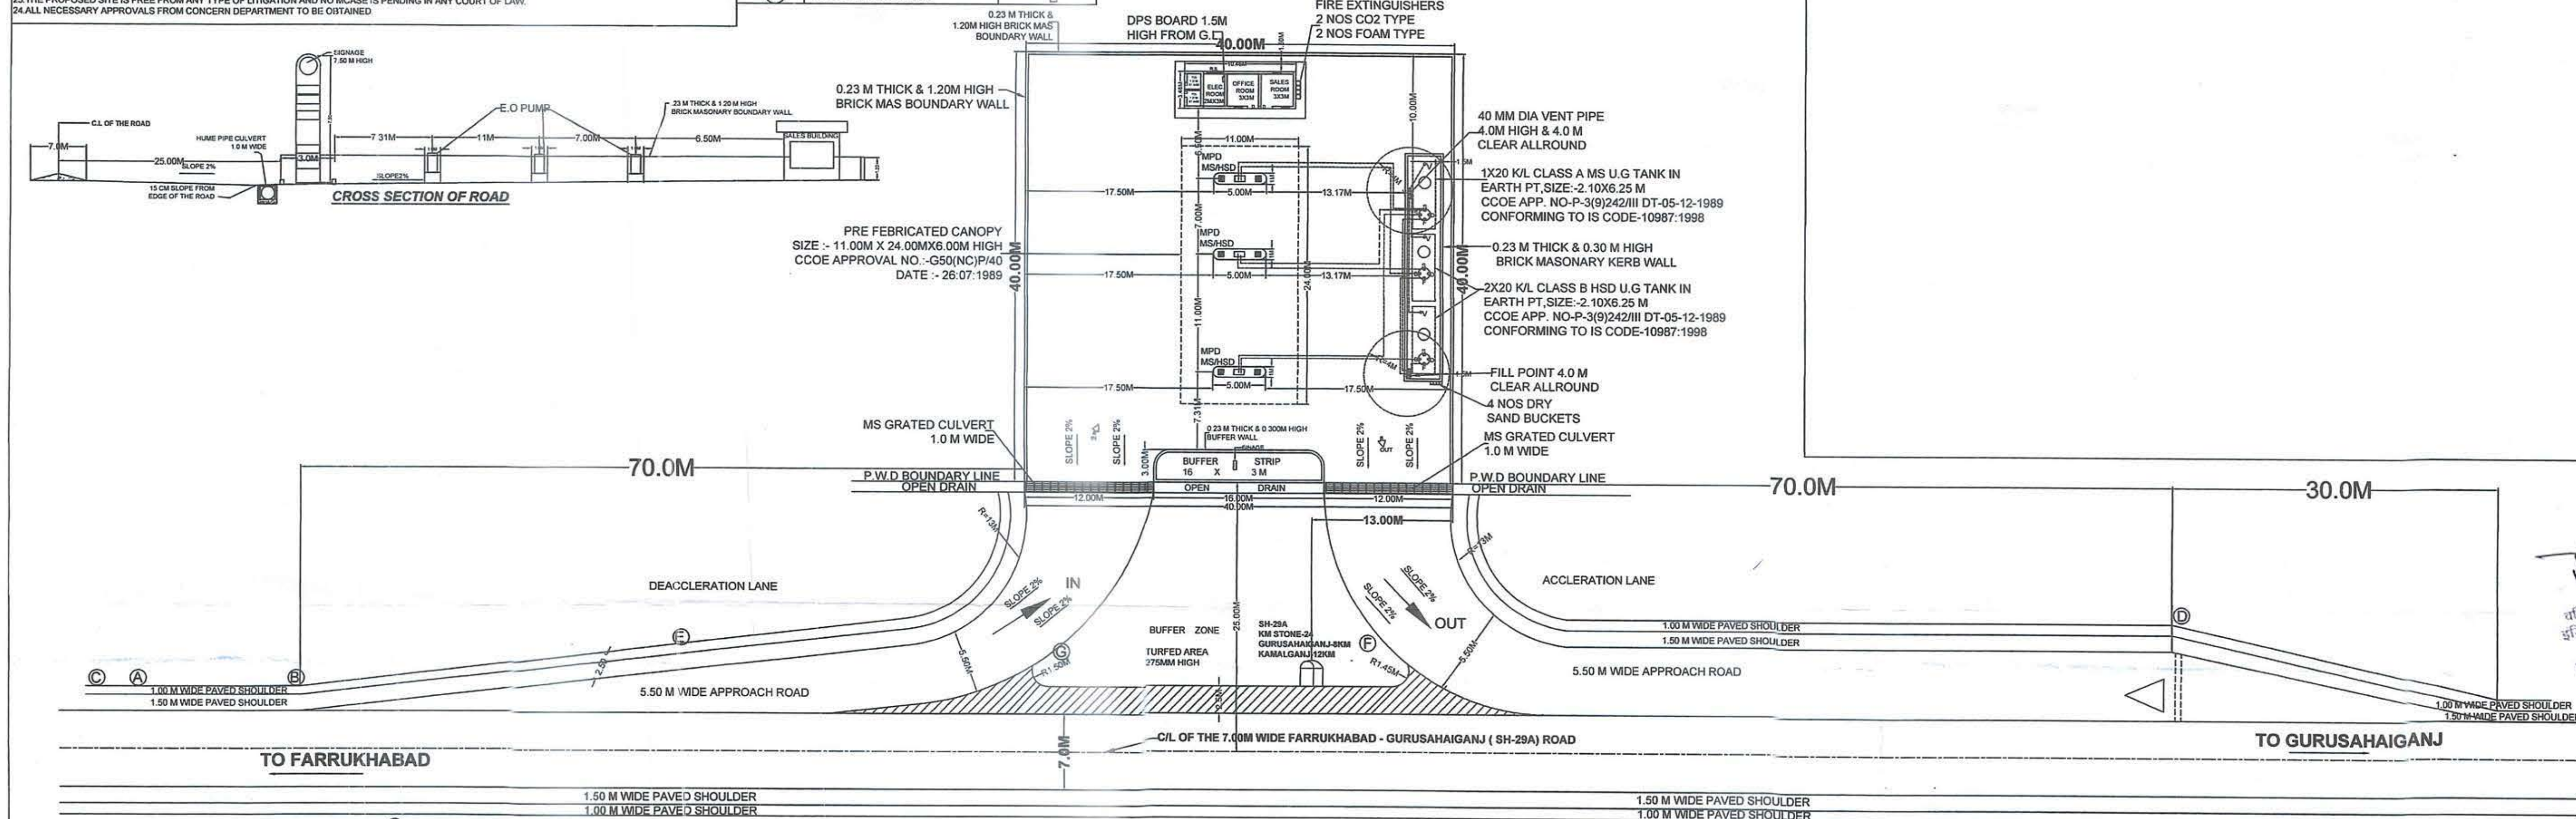


चन्द्रमणि राय  
 वरिष्ठ प्रबंधक (रिटेल सेल्स)  
 इंडियन ऑइल कॉर्पोरेशन लिमिटेड  
 ऑफिस नंबर, 65/2-282002


अधिसूची अभिलेखित  
 निर्माण खण्ड, 01 लोडिंग डिप  
 कन्नौज

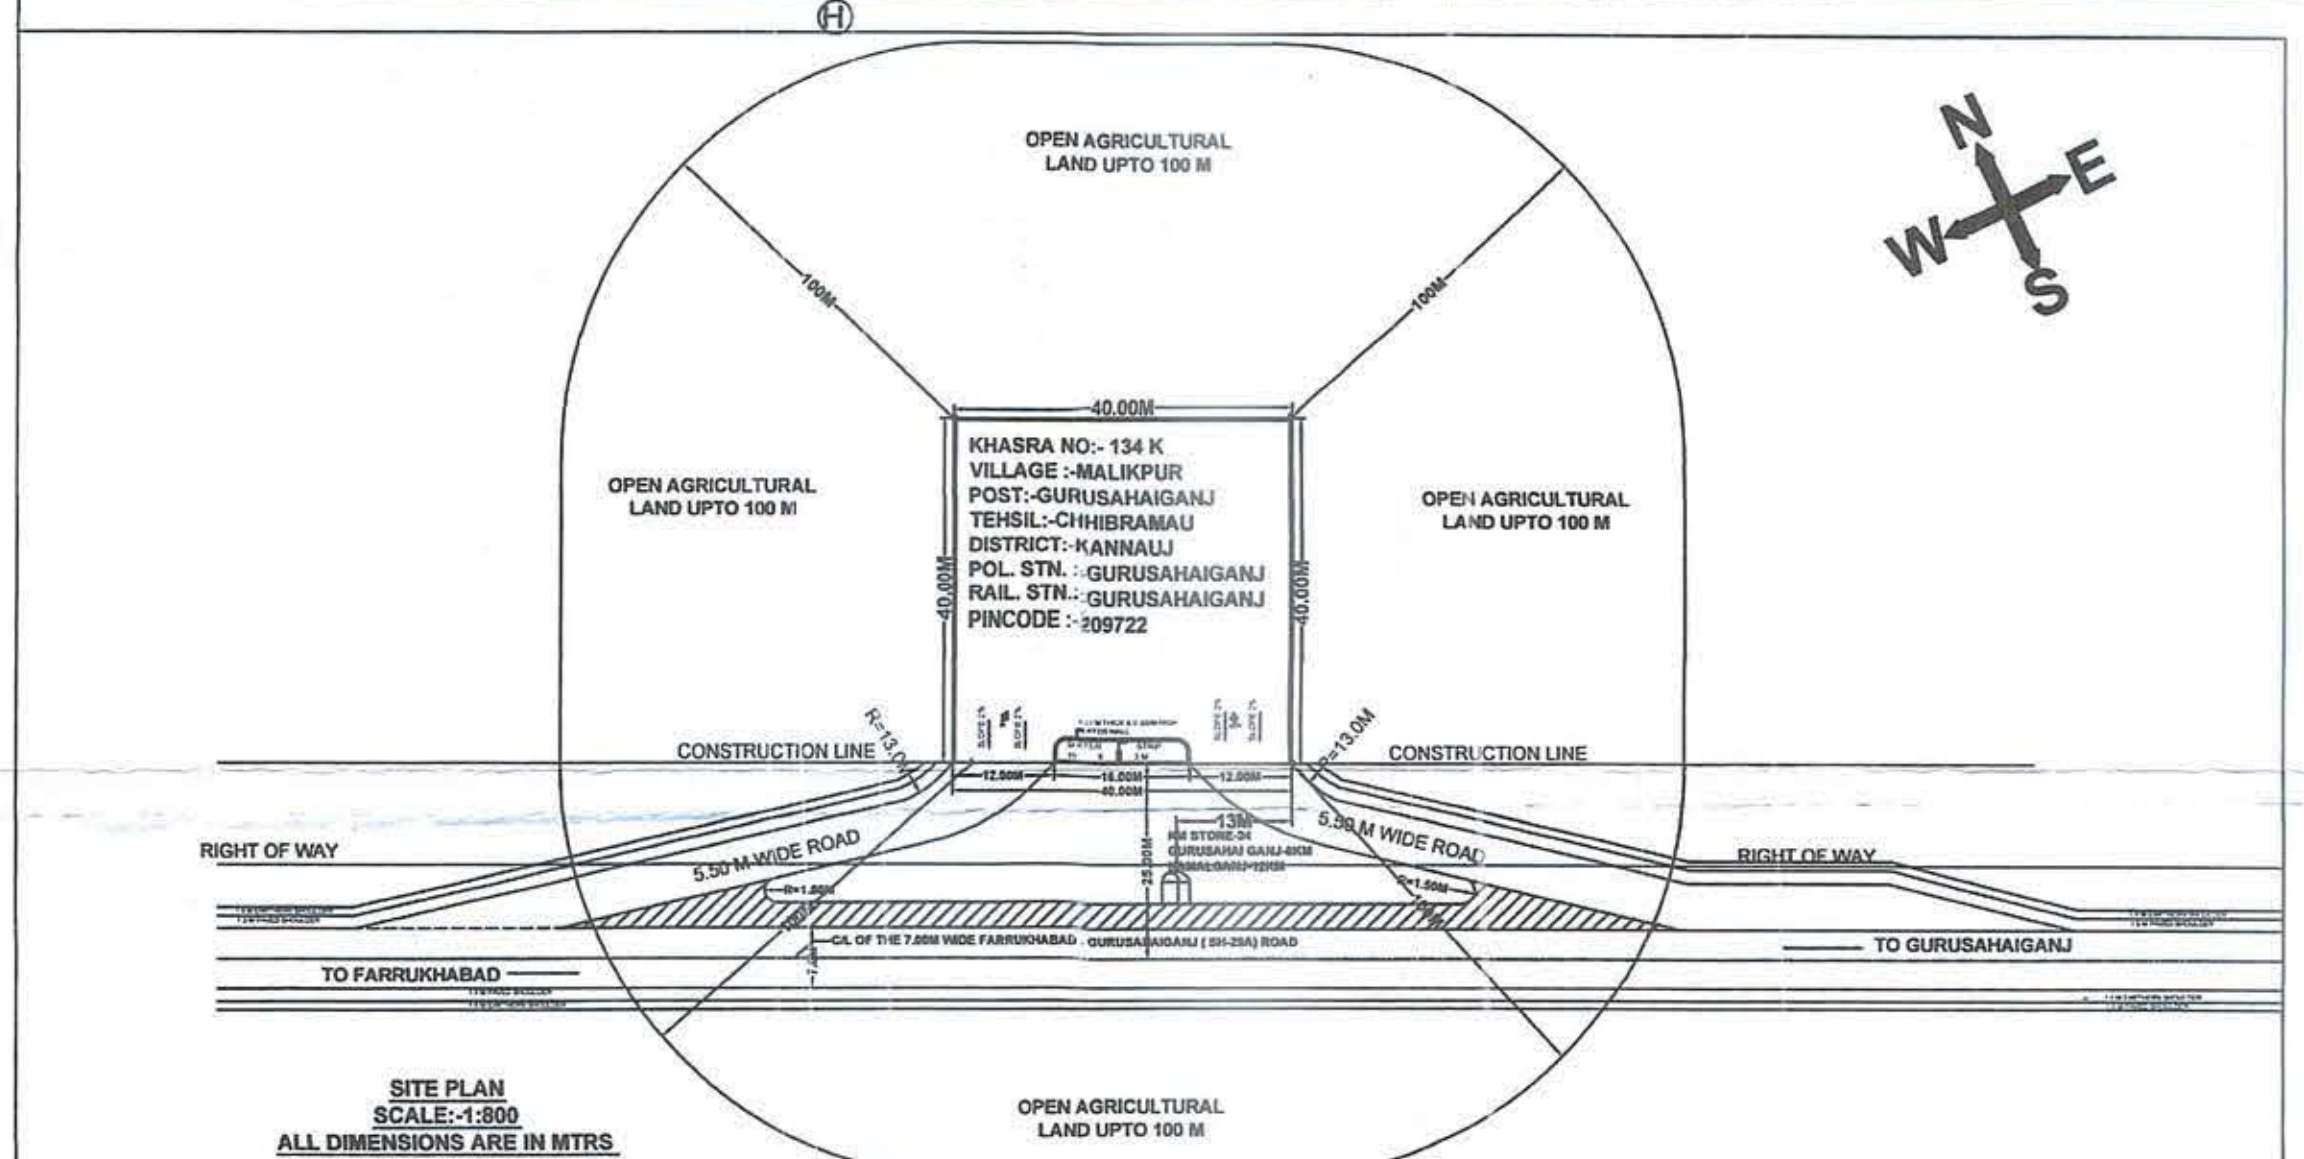

### LAYOUT PLAN SCALE:-1:300 ALL DIMENSIONS ARE IN MTRS

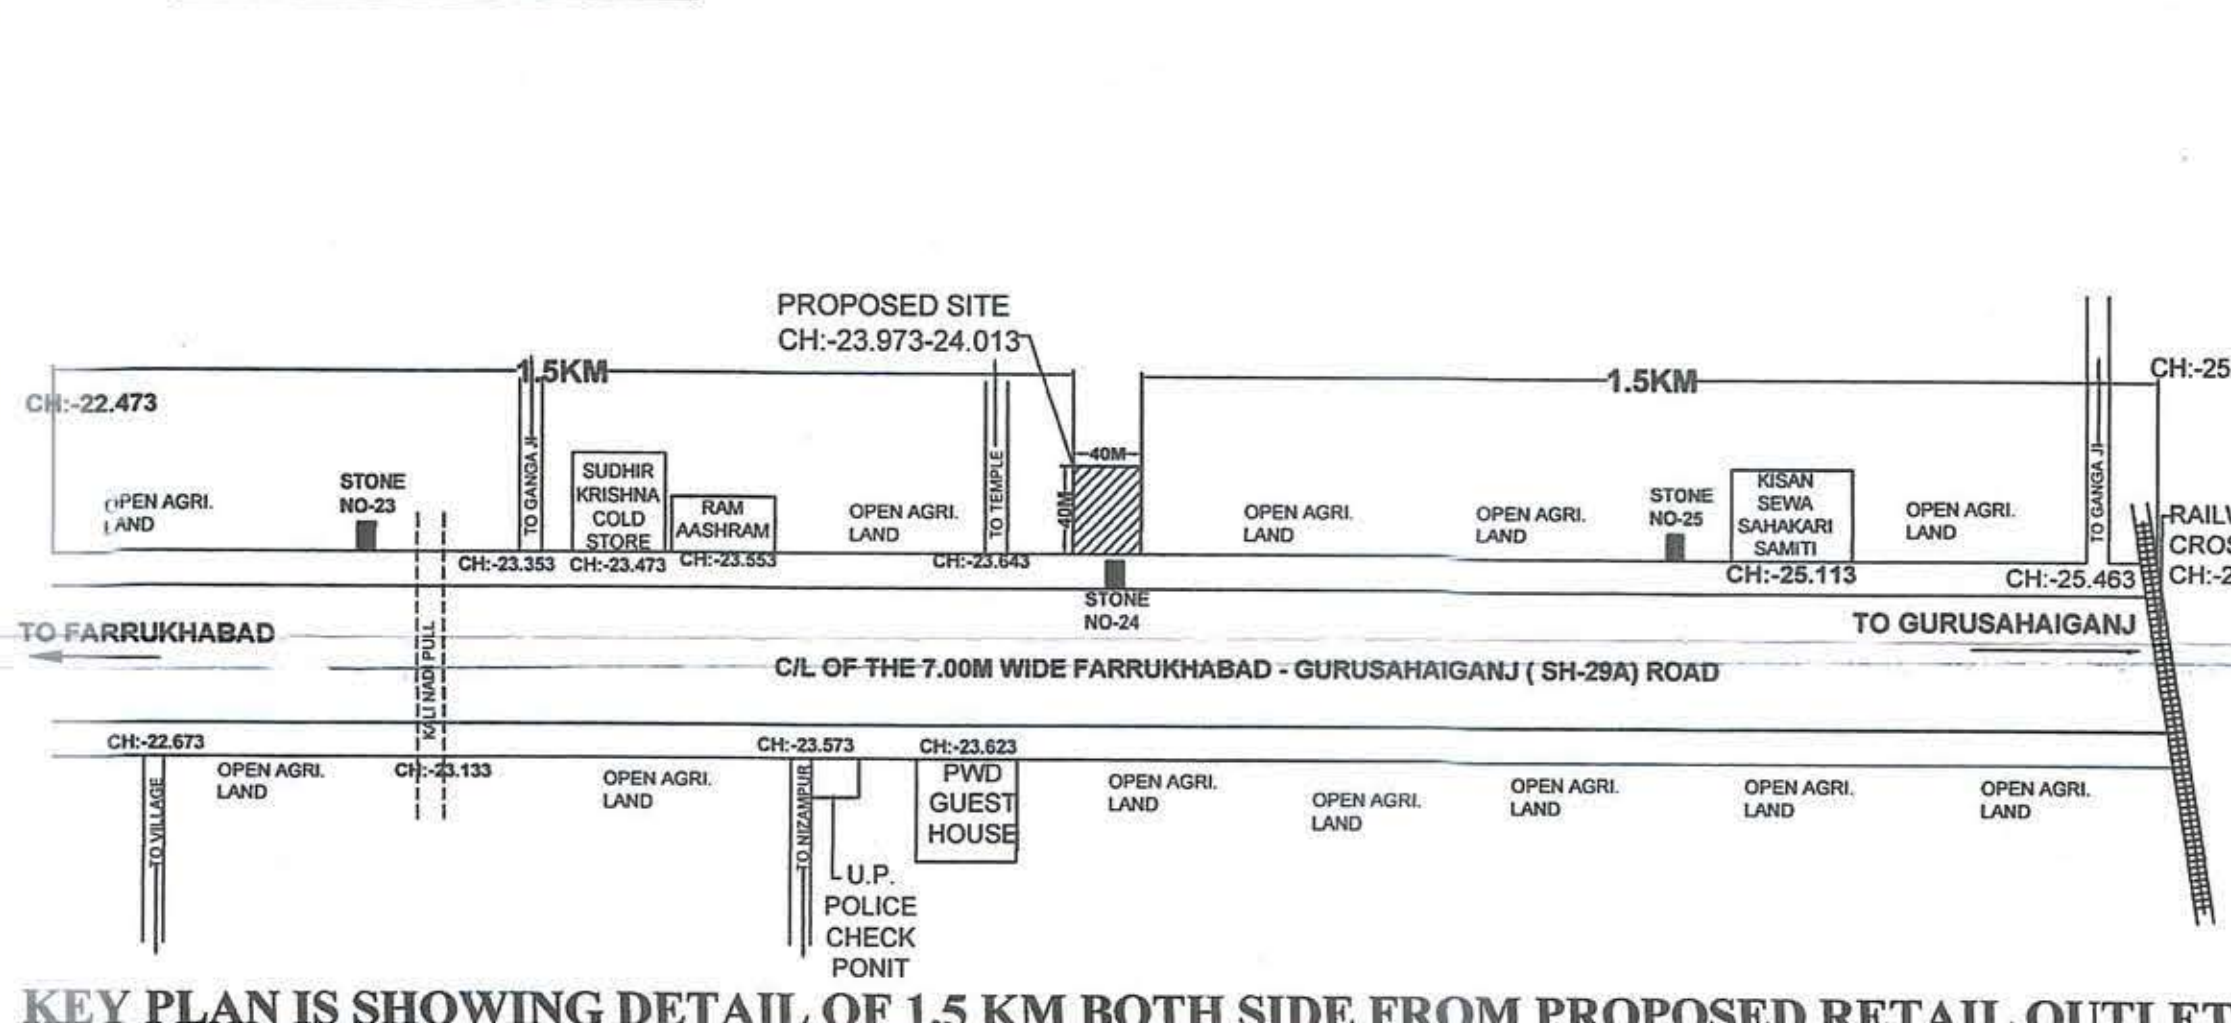

KEY PLAN IS SHOWING DETAIL OF 1.5 KM BOTH SIDE FROM PROPOSED RETAIL OUTLET

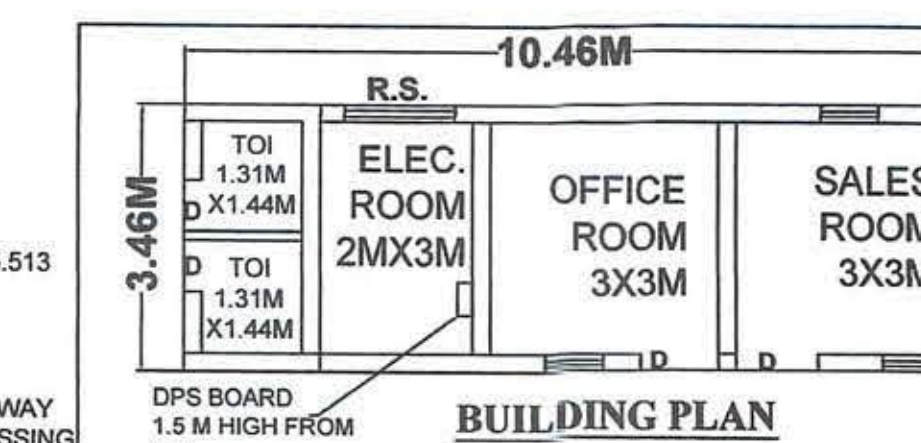

| LEGEND | DESCRIPTION  | DIMENSION     | CAPACITY | PIT TYPE                                                     | EXPLOSIVE APPROVAL NO.        |
|--------|--------------|---------------|----------|--------------------------------------------------------------|-------------------------------|
| T1     | MS U/G TANK  | 2.10 X 6.25 M | 20.00 KL | EARTHEN                                                      | CIE-P-3(9)242 DATE-11.06.1988 |
| T2     | HSD U/G TANK | 2.10 X 6.25 M | 20.00 KL | EARTHEN                                                      | CIE-P-3(9)242 DATE-11.06.1988 |
| T3     | HSD U/G TANK | 2.10 X 6.25 M | 20.00 KL | EARTHEN                                                      | CIE-P-3(9)242 DATE-11.06.1988 |
| P1     | PUMP ISLAND  | 5.00 X 1.0 M  |          | MASONARY / CONCRETE PEDESTAL FOR ELECTRICALLY OPERATED FLAME |                               |
| P2     | PUMP ISLAND  | 5.00 X 1.0 M  |          | PROOF PUMP CONFORMING IS - 2148.                             |                               |
| P3     | PUMP ISLAND  | 5.00 X 1.0 M  |          |                                                              |                               |

### LICENSE DETAILS.

PESO. LIC. NO. P/CC/UP/14/ (P)



**Indian Oil Corporation Limited**  
 (Marketing Division)  
 65/2, Sanjay Place, Agra.

### NAME OF RO:-

### LOCATION:-

### DRAWING NO:-

### DATE:-

### MS & HSD RETAIL OUTLET


### ROAD:- ON GURUSHAIGANJ-FARRUKHABAD ROAD

### TEHSIL:- CHHIBRAMAU


### DISTRICT:- KANNAUJ

### STATE:- UTTAR PRADESH


| DATE | REVISION | Scale:-As Shown Above | Sr.MGR(E) | Sr.MGR(RS) | CDRSM |
|------|----------|-----------------------|-----------|------------|-------|
|------|----------|-----------------------|-----------|------------|-------|

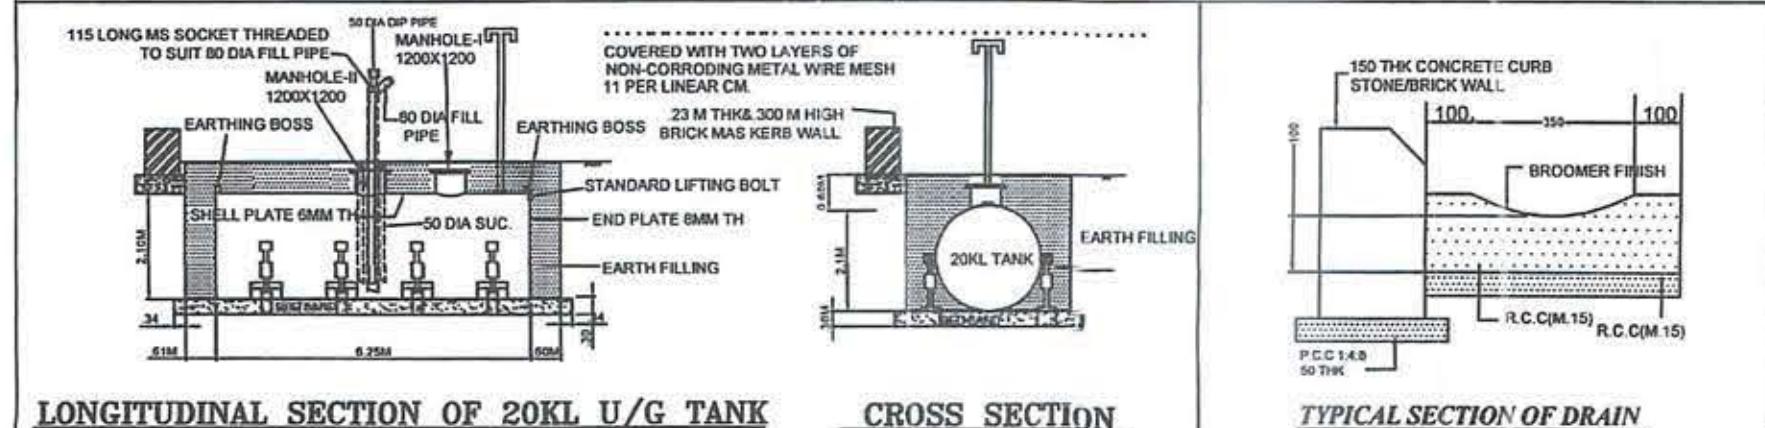


### CROSS SECTION

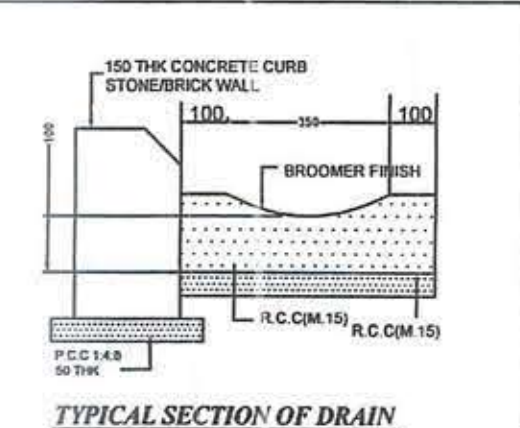

### DETAIL OF KERB WALL

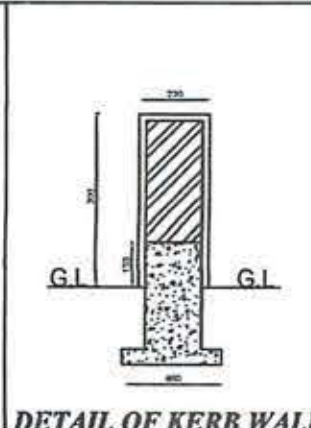

### DETAILS SECTION OF APPROACH ROAD

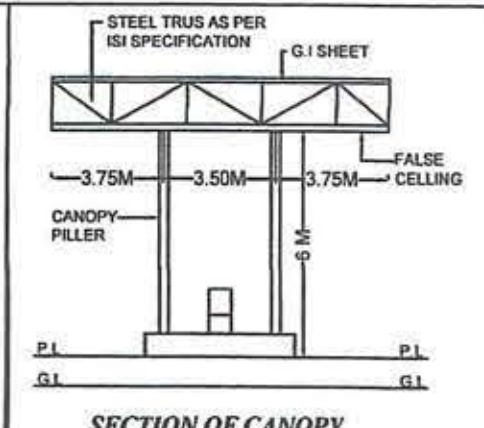

### FRONT ELEVATION

