
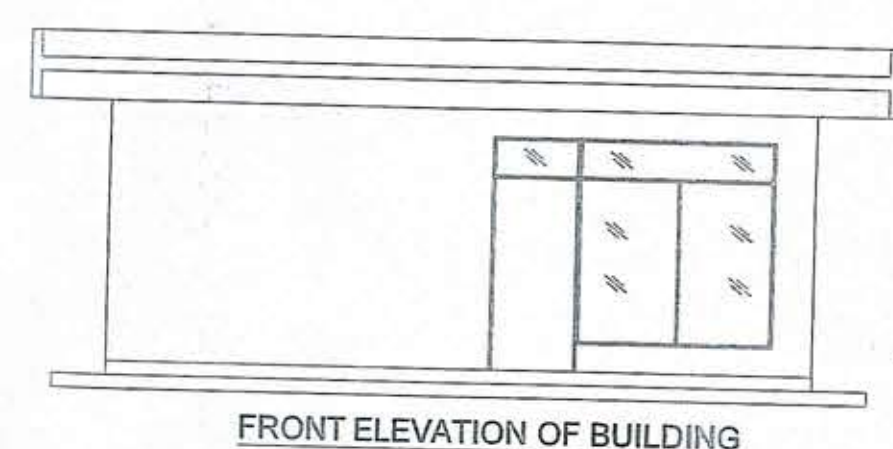
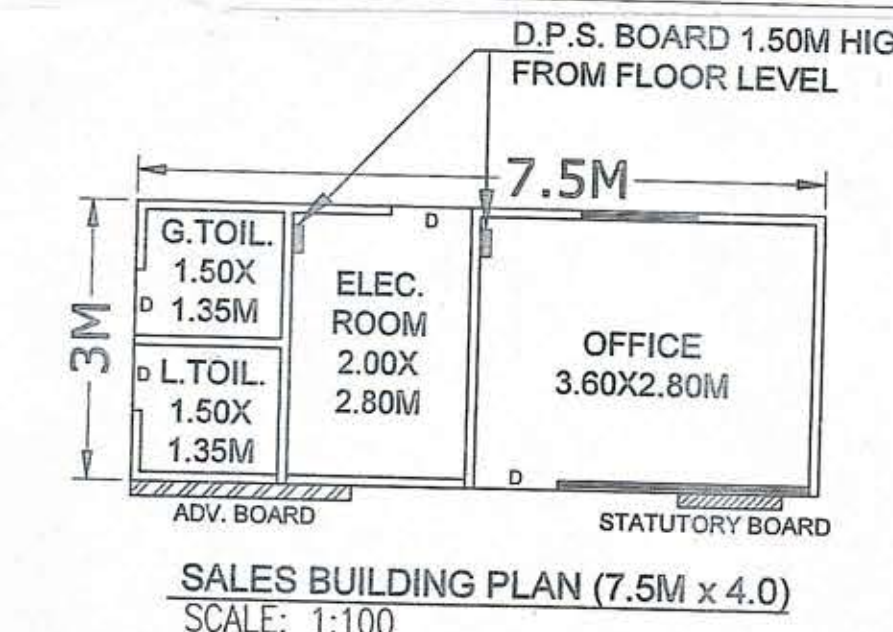
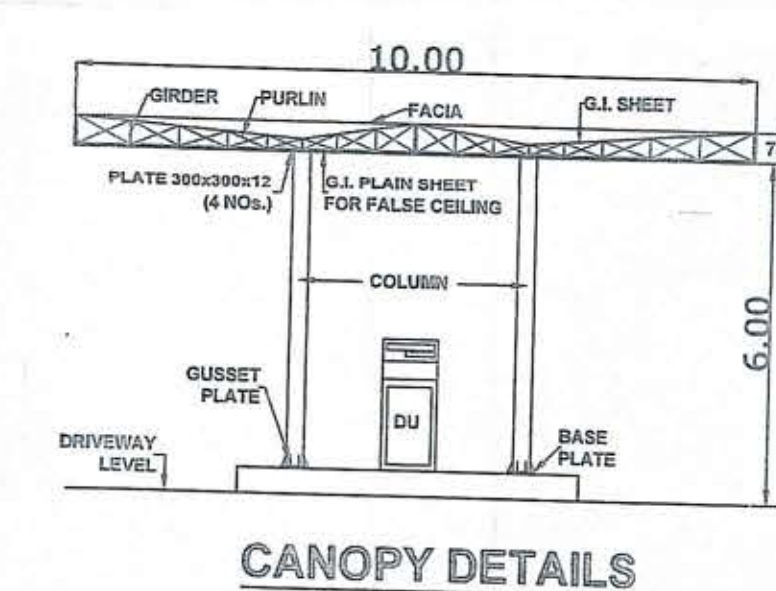
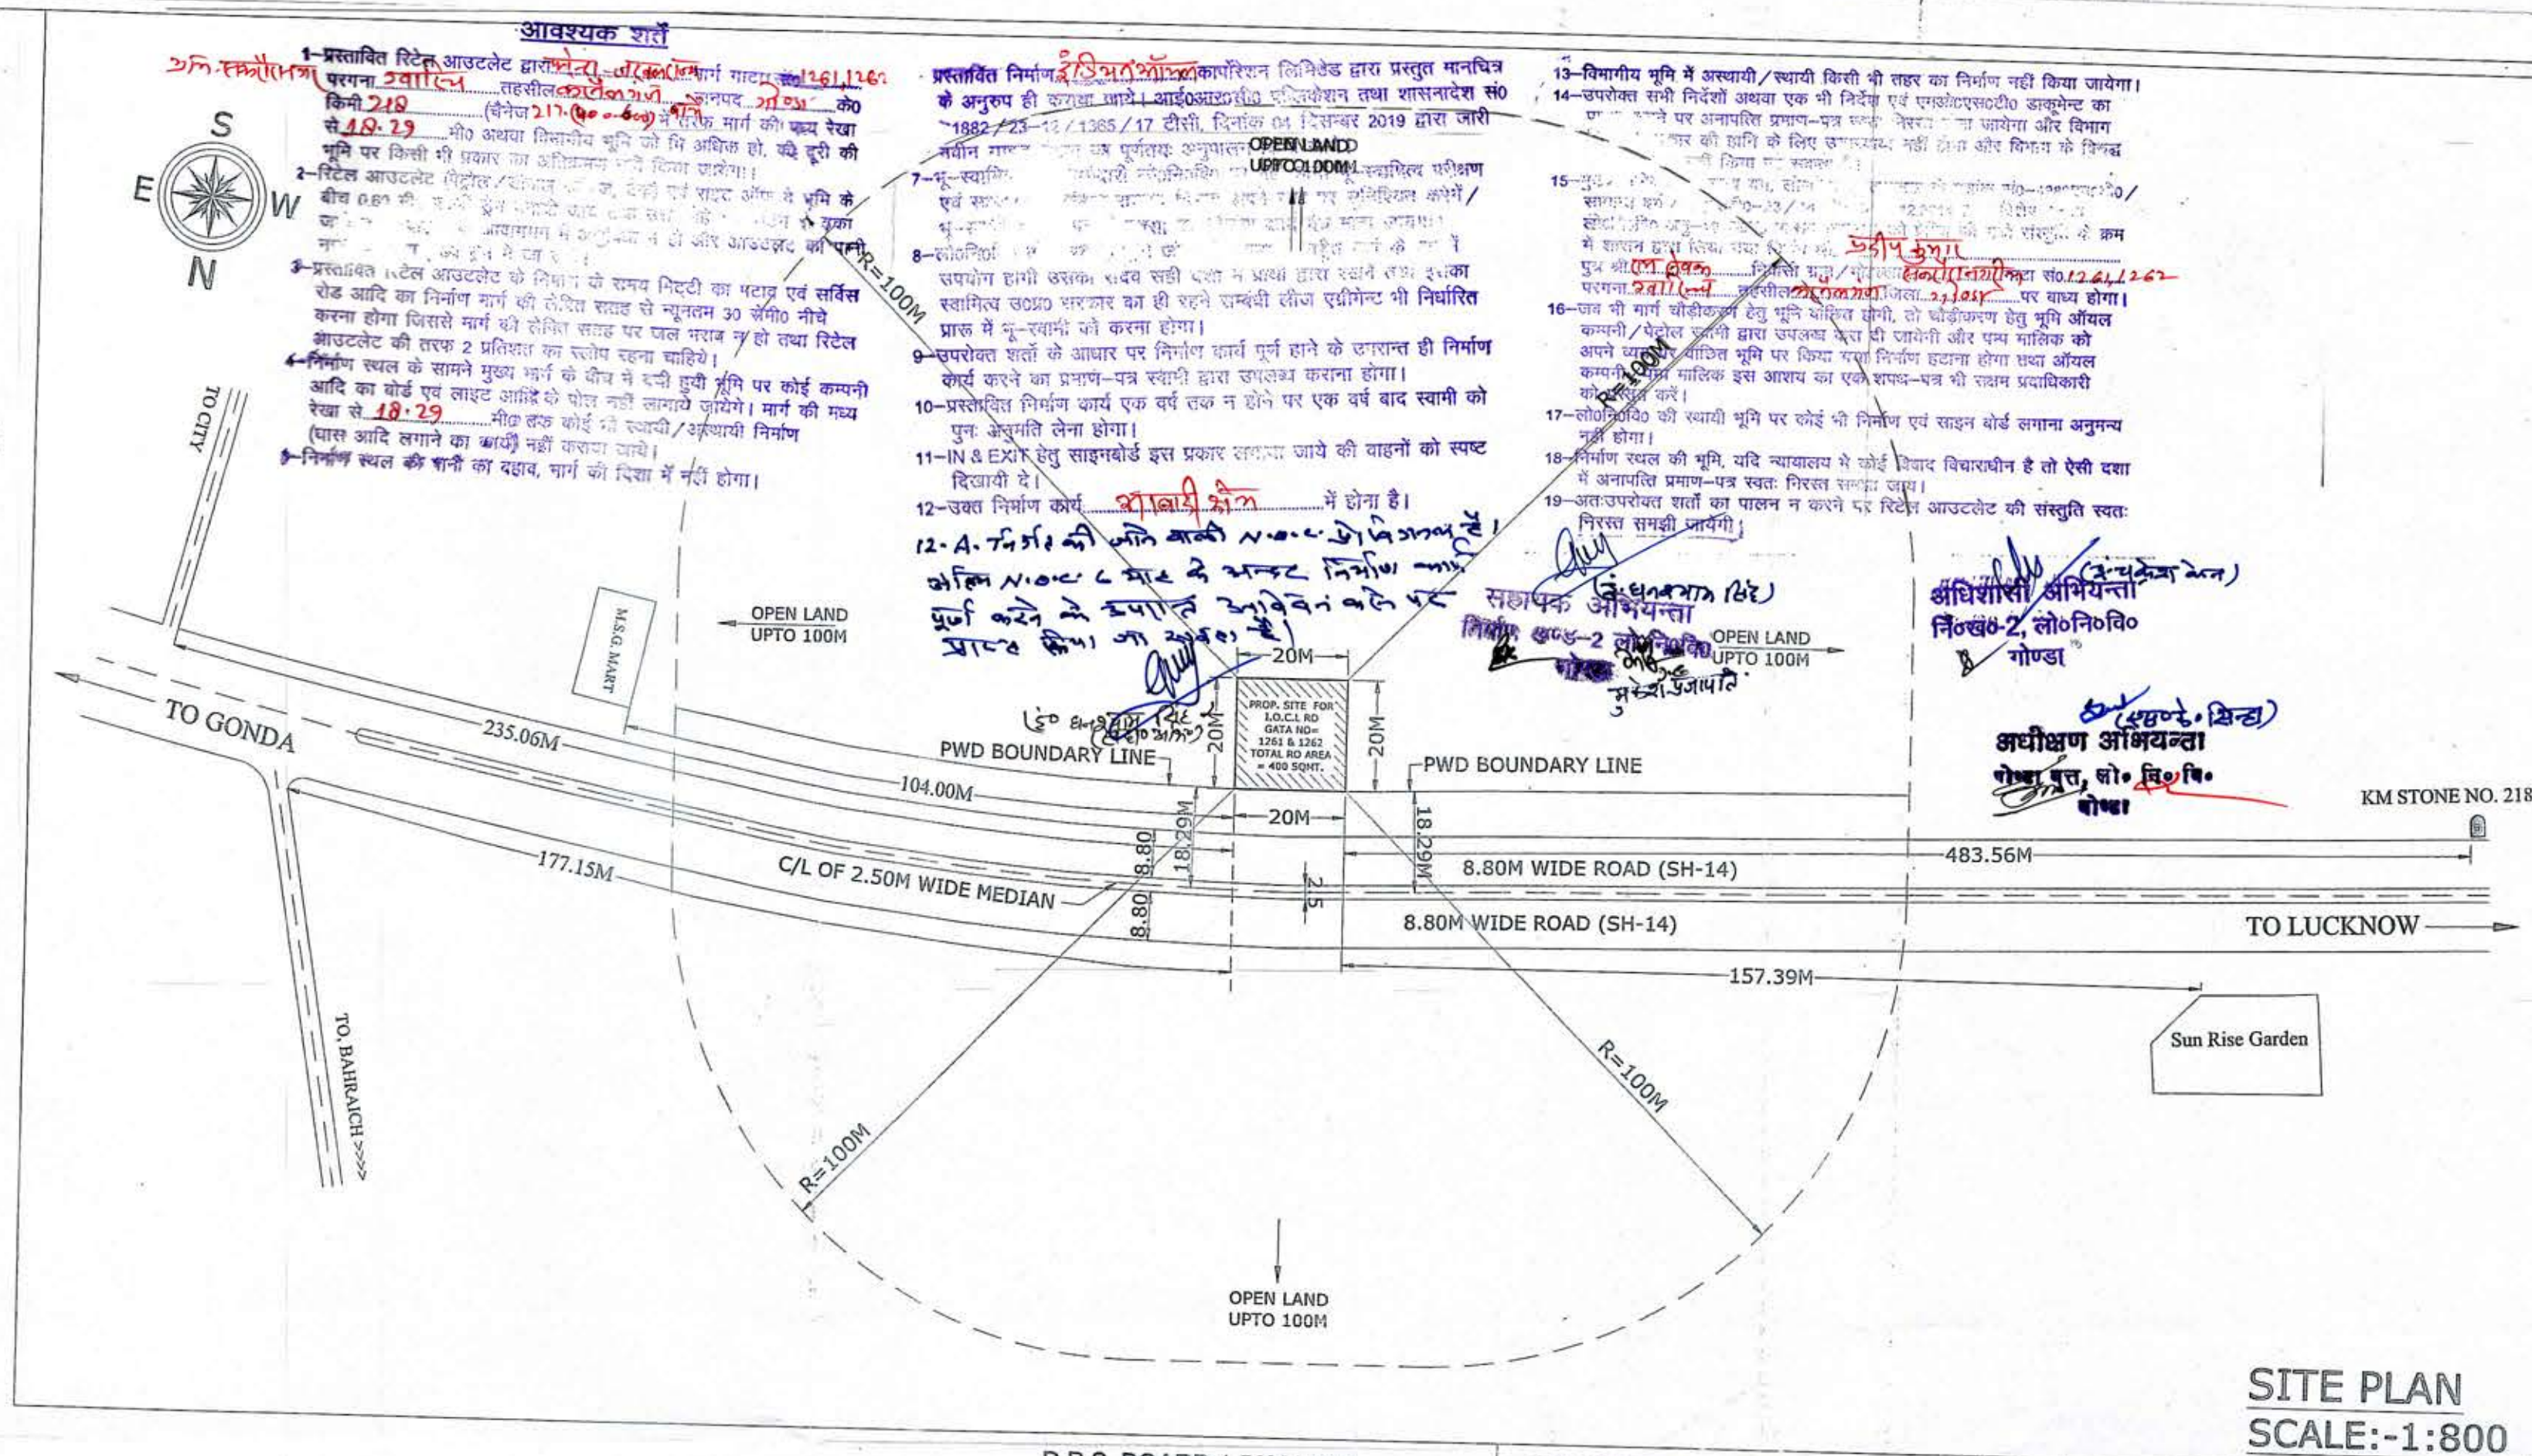
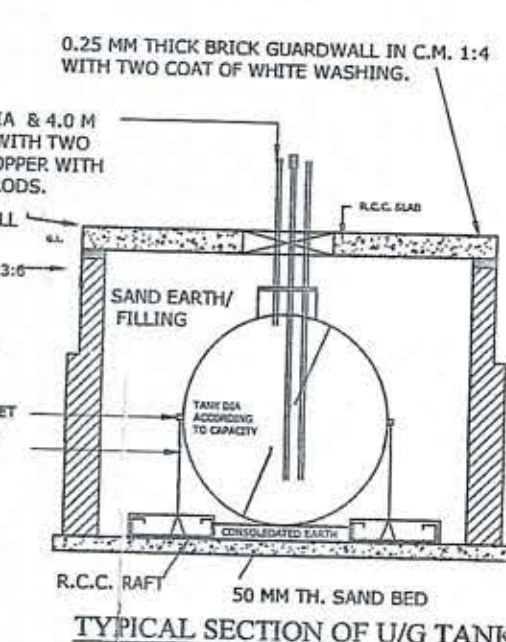
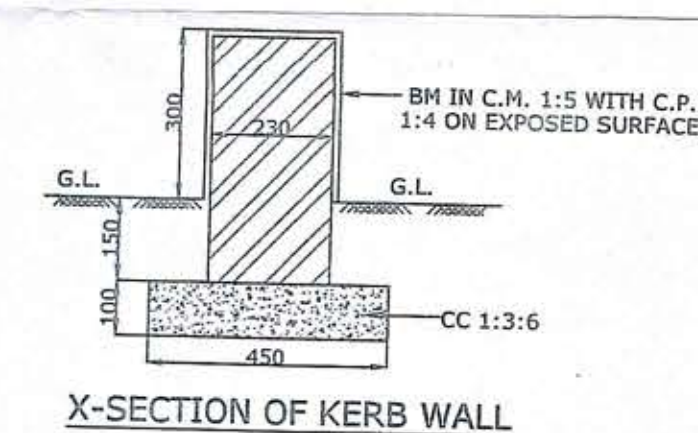
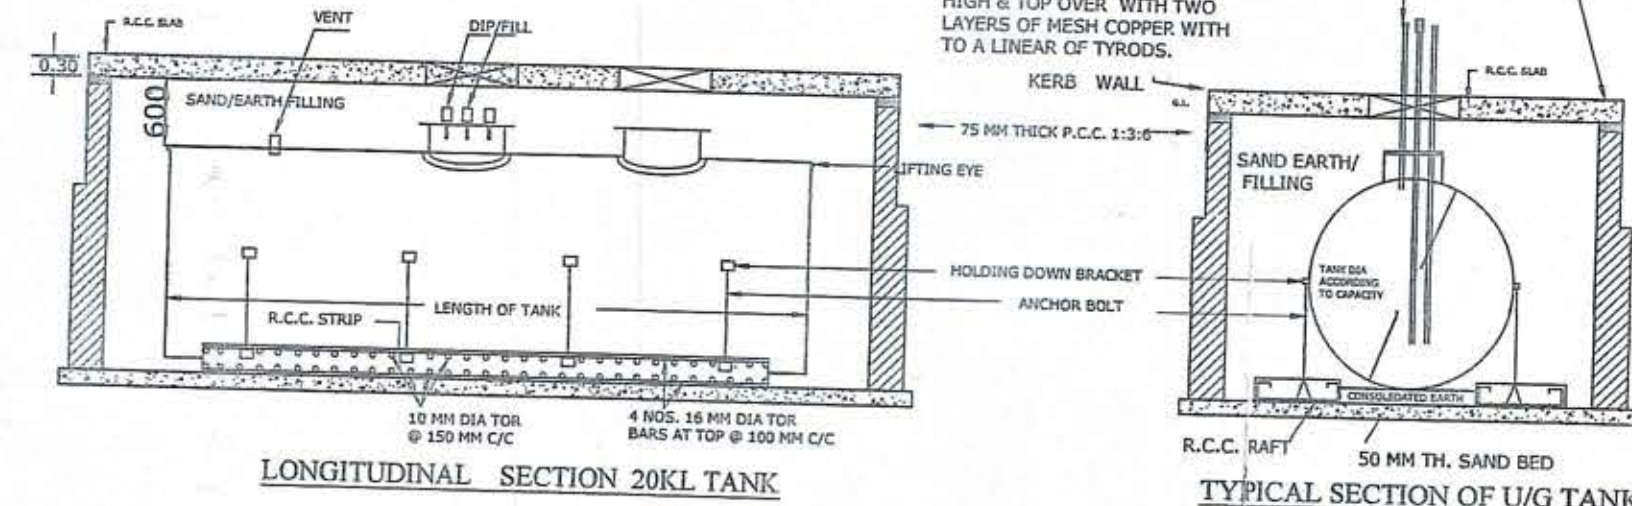
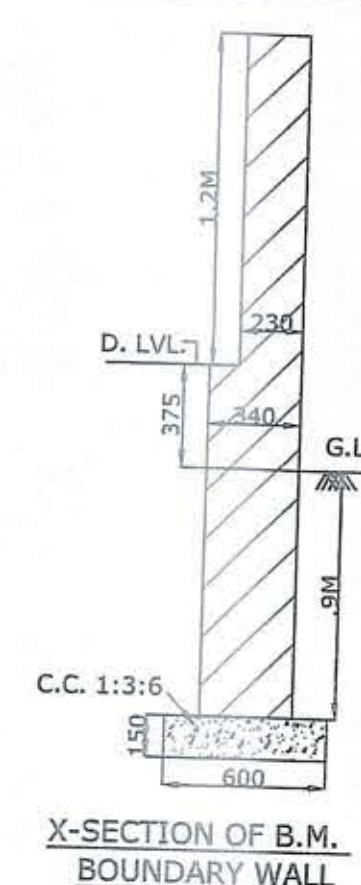
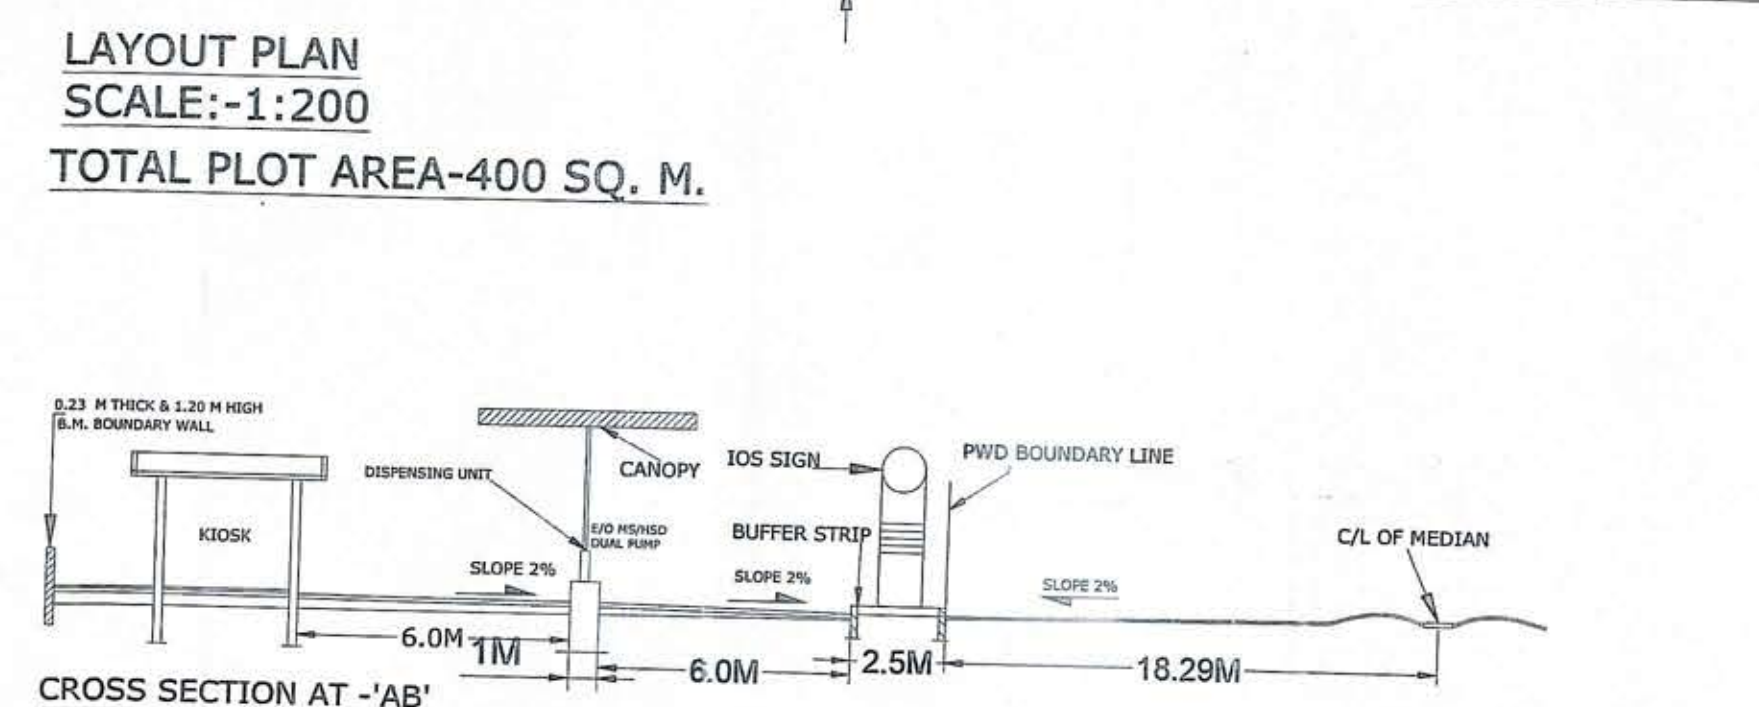


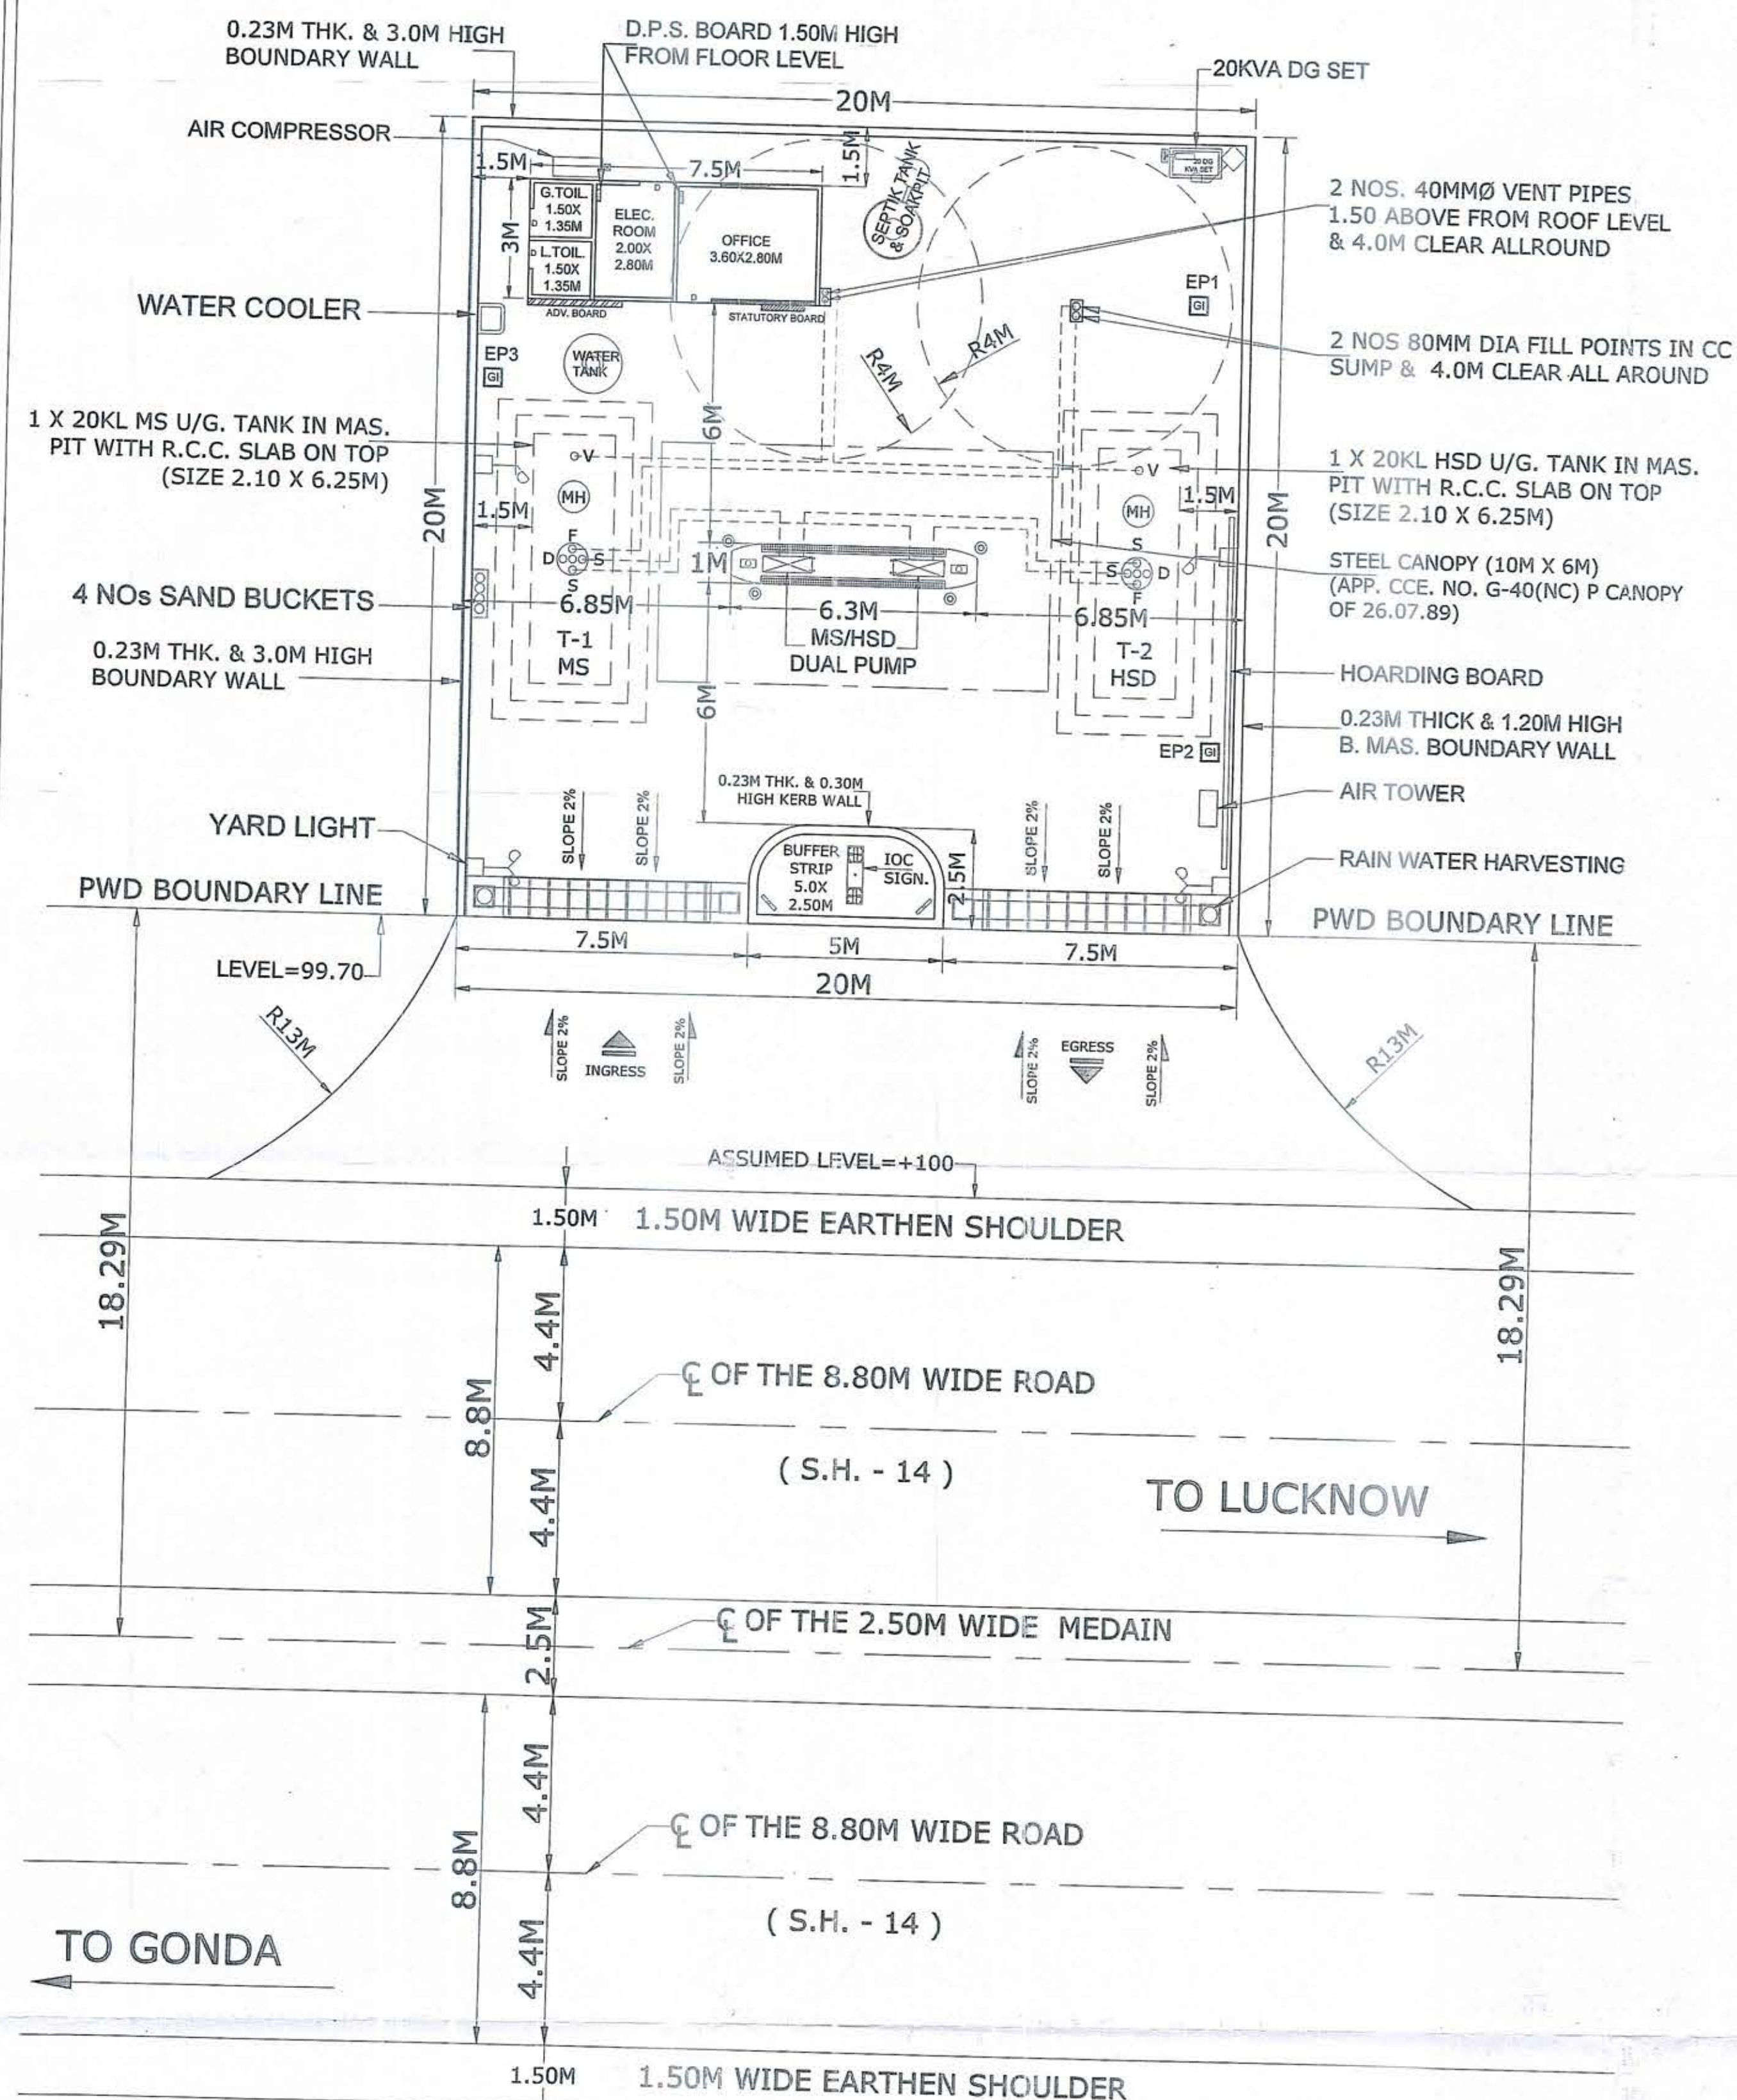

SPECIFICATION NOTES- I

1. CERTIFIED THAT NO OTHER STRUCTURE WILL BE ERECTED NOR ANY OTHER SERVICE RENDERED EXCEPT THAT CONNECTED WITH PETROL PUMP WITHOUT THE PRIOR APPROVAL OF P.W.D.
2. CERTIFIED THAT THERE IS NO CROSSING WITHIN 300M BETWEEN THE TANGENT POINTS OF THE CURVES OF SIDE ROAD AND THAT OF THE FUEL-FILLING CUM SERVICE STATIONS OF THE PETROL PUMP. THAT THERE IS NO OBJECTION FROM ROAD POINT OF VIEW FOR THE INSTALLATION OF THIS PUMP. THE PROPOSED PUMP WILL NOT AFFECT THE FUTURE IMPROVEMENT OF THE ROAD.
4. CERTIFIED THAT NO OTHER PETROL PUMP EXISTS WITHIN THE DISTANCE OF 300M ON EITHER SIDE OF THE PLOT.
5. CERTIFIED THAT ALL CONDITIONS LAID DOWN BY THE GOVT. OF INDIA AND IRC FROM TIME TO TIME WITH REGARD TO THE LOCATION OF ROAD SIDE FUEL-FILLING CUM SERVICE STATIONS SHALL BE COMPLIED WITH & ENTIRE CONSTRUCTION WILL BE ON CORPORATION LAND.
6. NO DRAIN, SEWER OR STRUCTURE WITHIN 1.5M FROM UNDER GROUND TANKS.
7. SUCTION PIPES, UNDER DRIVEWAY HOUSED IN PIPE SLEEVES.
8. ELECTRIC FITTINGS CONFORM TO IS CODE NO- 2144 FOR NON-IONISING PUMP ONLY.
9. DPS BOARD IS FIXED 1.5M HIGH FROM FLOOR LEVEL AND WILL NOT BE KEPT UNDER LOCK AND KEY.
10. CORROD VENT PIPES, 4M HIGH FROM GROUND LEVEL AND 4M CLEAR AROUND, THE OPEN END OF PIPE LINDER CM.
11. COVERED WITH TWO LAYERS OF NONE CORRODIBLE METAL WIRE GAUGE OF 11MESH PER LINER CM.
12. 80MMO FILD PIPES, TO BE PROVIDED 3.65M CLEAR ALL ROUND.
12. FIRE FIGHTING EQUIPMENT:-  
C02 TYPE FIRE EXTINGUISHERS OF CAPACITY 9KG EACH FOR PETROLEUM FIRE, 2NOS  
FOAM TYPE FIRE EXTINGUISHERS OF CAPACITY OF 3KG EACH FOR FIGHTING ELECTRICAL FIRE, 2NOS  
6NOS TYPE FIRE BUCKETS FILLED WITH DRY SAND SHALL BE PROVIDED AT THE PETROL PUMP.
13. CERTIFIED THAT THERE WILL NOT BE ANY HIGH DRIVES FROM OVER HEAD HT LINES.
14. CERTIFIED THAT ALL THE CONDITIONS OF IRC-1983/2003 SHALL BE COMPLIED WITH.

TANK SCHEDULE :-

| TANK NO. | PRODUCT | CAPACITY |
|----------|---------|----------|
| 1        | MS      | 20KL     |
| 2        | HSD     | 20KL     |

PUMP SCHEDULE :-

| PRODUCT | NO.OF PUMP | NO.OF NOZZLE |
|---------|------------|--------------|
| MS      | 2          | 2            |
| HSD     | 2          | 2            |

|          |             |      |          |          |
|----------|-------------|------|----------|----------|
| REV. NO. | DESCRIPTION | DATE | REV. BY. | APP. BY. |
|----------|-------------|------|----------|----------|



INDIAN OIL CORPORATION LTD.  
( MARKETING DIVISION )  
LUCKNOW DIVISIONAL OFFICE

PROJECT:- PROPOSED MS/HSD RETAIL OUTLET IN COLONELGANJ WML  
ON GONDA -LUCKNOW (SH-14) ROAD, AT VILLAGE SAKRAURA, TEHSIL-  
COLONELGANJ, DISTT.- GONDA (U.P.)

TITLE:- SITE & LAYOUT PLAN OF RETAIL OUTLET

|                           |                        |
|---------------------------|------------------------|
| DRG NO.:- RO/LKO/SAKRAURA | DRG DATE :- 05.02.2021 |
|---------------------------|------------------------|

|                                      |  |  |  |  |
|--------------------------------------|--|--|--|--|
| M/S Acceptance Partners<br>New Delhi |  |  |  |  |
|--------------------------------------|--|--|--|--|

New Delhi  
 Mob. 8527237363  
 PRANJEEN  
 मुख्य मण्डलीय निदेश देना  
 Chief Divisional Rural Sav  
 मण्डलीय या / जिला (अ)