




Diversion of 0.0662 Ha. of Forest Land for Laying of 300MM DI RCC NP2 Water Pipe line of 662 Meter Length from JD - 3 Minor to Rupgarh Water works at Village – Rupgarh, Teh. & Distt. Jind (HR)

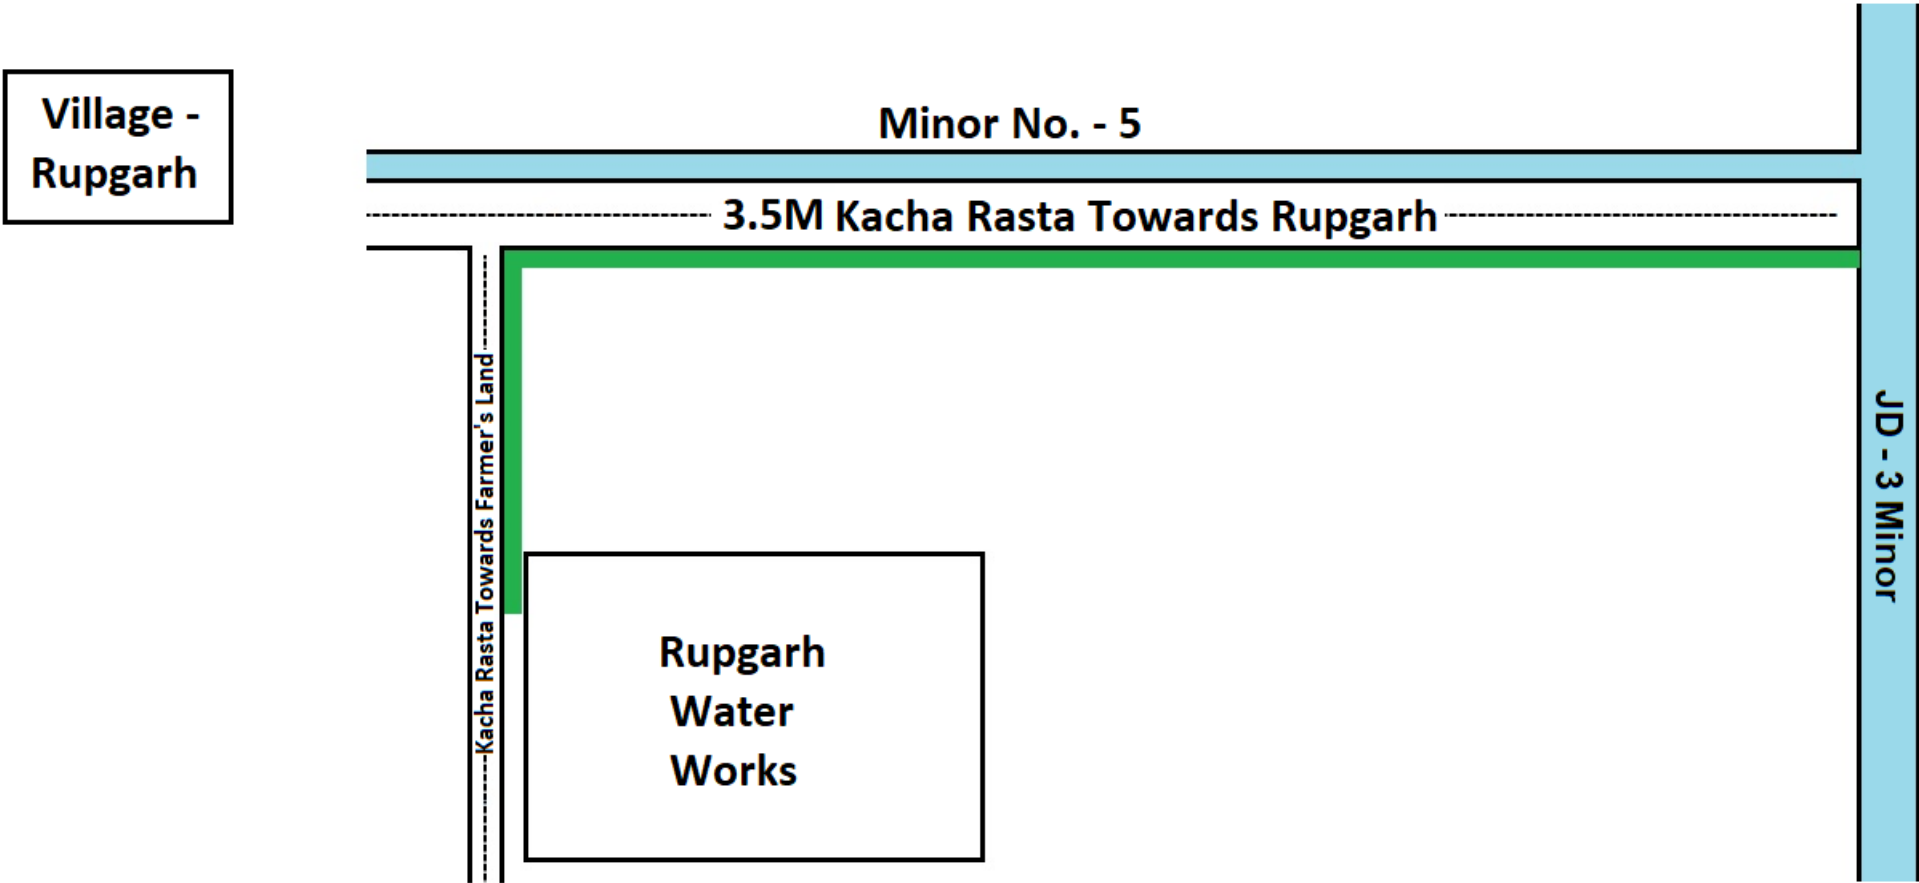

DREST AREA USED Forest Land Area: - = 662 M X 1.0 M = 662 SQMT = 0.0662Hectare	PROJECT NAME: - Diversion of 0.0662 Ha. of Forest Land for Laying of 300MM DI RCC NP2 Water Pipe line of 662 Meter Length from JD - 3 Minor to Rupgarh Water works at Village – Rupgarh, Teh. & Distt. Jind (HR)	DRAWING NAME: SITE PLAN	SCALE: - NTS		DATE: - 17/07/2021
		NOTES: - <ul style="list-style-type: none"> ❖ DRAWING AND DIMENSIONS ARE ONLY TO BE READ AND NOT SCALED. ❖ UNLESS OTHERWISE MENTIONED, ALL DIMENSIONS ARE GIVEN IN METERS ❖ THIS DRAWING SHALL BE READ IN CONJUNCTION WITH RELEVANT ARCHITECTURAL, STRUCTURAL AND SERVICES DRAWINGS. ❖ ALL LEVELS GIVEN IN DRAWING ARE WITH REFERENCE TO THE ROAD LEVEL AS BENCHMARKED AT SITE ❖ ANY DISCREPANCY BETWEEN THE ARCHITECTURAL/ STRUCTURAL OR SERVICES DRAWINGS MUST BE BROUGHT TO THE ATTENTION OF THE ARCHITECT BY THE CONTRACT OR PROJECT MANAGER BEFORE EXECUTION OF THE SAME. ❖ ARCHITECT & CAN NOT BE REPRODUCED IN ANY FORMAT WITHOUT WRITTEN CONSENT FROM THE ARCHITECT. 	DRAWN BY: - Lalit Sharma CHECKED BY: - Aniket Singh	PRINCPAL ARCHITECH: - Ar. ARMAN SINGH ARCHITECTS & INTERIOR DESIGNERS	
			User Agency: -  Executive Engineer Public Health Engineering Division No.1, Jind Sh. Sanjay Sharma, Executive Engineer, Public Health Engineering Department, Division No.- 1, Jind		