



LEGEND	PRODUCT & CLASS	Di/VH	LENGTH	CAPACITY	PIT TYPE	CONNECTED TO	EXPLOSIVE APPROVAL No.
T1	MS CLASS 'A'	2100	6250	20 KL	EARTHEN	MPD1 & 2	CEP-38242018-05-13-1988
T2	HSD CLASS 'B'	2100	6250	20 KL	EARTHEN	MPD1 & 2	CEP-38242018-05-13-1988
P1	PUMP ISLAND	1400	8000				
P2	PUMP ISLAND	1400	8000				
PRODUCT	CONNECTED TO						
MPD2	HSDMS						
MPD1	HSDMS						


MASONRY/CONCRETE PEDESTAL FOR ELECTRICALLY OPERATED FLAME PROOF PUMP CONFORMING TO IS-2148

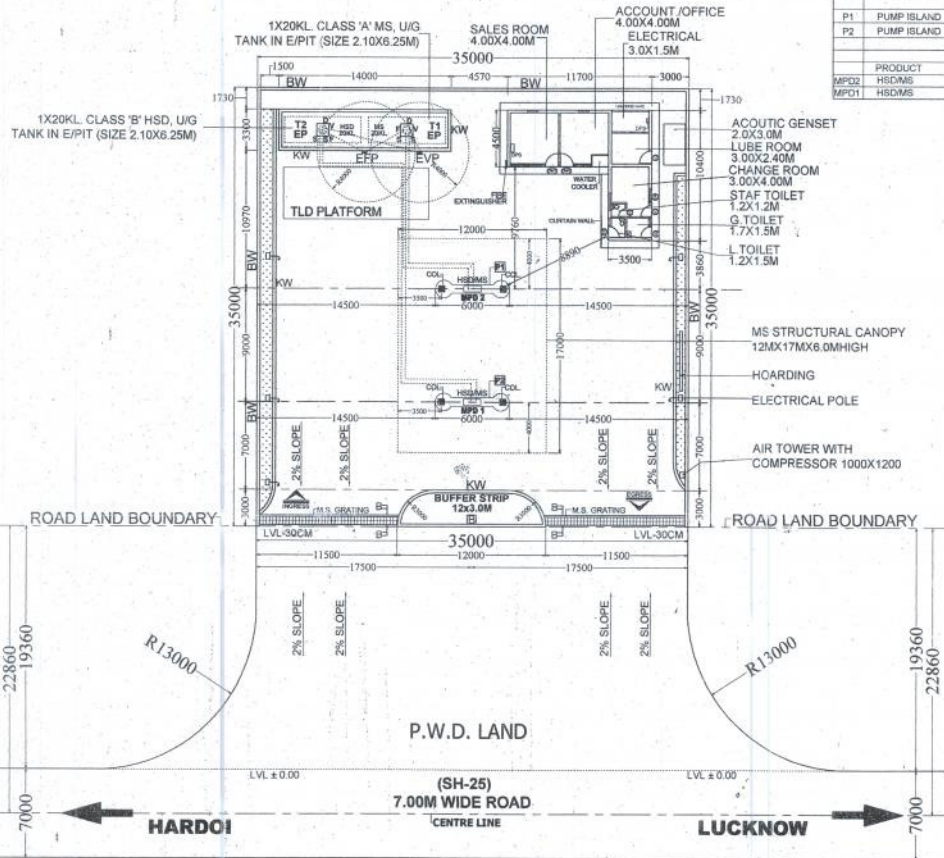


LAYOUT PLAN (SCALE 1:200)

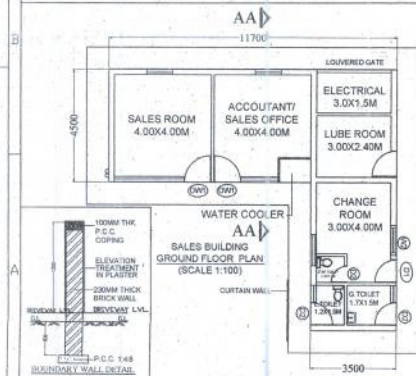


SALES BUILDING GROUND FLOOR PLAN (SCALE 1:100)

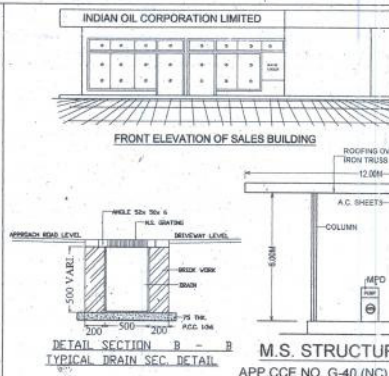

FRONT ELEVATION OF SALES BUILDING

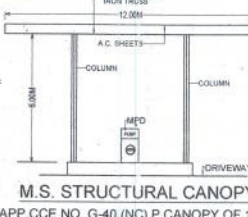

M.S. STRUCTURAL CANOPY APP CCE NO. G-40 (NC) P CANOPY OF 13.4.89

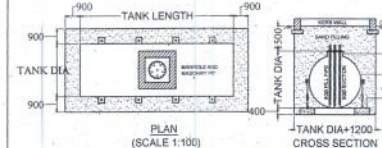


TANK INSTALLATION IN EARTHEN PIT WITH STRIP RAFT OR MAT RAFT

DOOR & WINDOW SCHEDULE	
D	1000x2000 ALUMINUM GLAZED DOOR
W	1000x1200 STEEL GLAZED WINDOW
V	1000x600 STEEL GLAZED WINDOW
GP	3000x2000 ROLLING SHUTTER
GP	2100x1200 ALUMINUM GLAZED WINDOW

LEGENDS REPRESENT

S	SUCTION POINT PIPE LINE CONNECTING UNDER GROUND TANK AND DISPENSING UNIT
EP	EXTENDED FILL POINT MINIMUM 3000mm AWAY FROM BOUNDARY AND BUILDING
EP	UNDER GROUND TANKS INSTALLED IN EARTHEN PIT
BS	BUFFER STRIP IN BRICK MASONRY 275mm HIGH AND 150/250mm THICK
KW	KERB WALL 275mm HIGH, 250mm THICK IN BRICK MASONRY/CONCRETE BLOCKS
EV	VENT PIPE WITH VENT HOOD ON TOP, 400mm AWAY FROM BOUNDARY WALL/BUILDING AND 400mm ABOVE GROUND
BW	MASONRY WALL 250mm THICK & 1200mm HIGH ALL AROUND RETAIL OUTLET BOUNDARY
F	FLUO SIGN/EMBLEM POLE/MONUMENT/TOTEM
F/D	FILL/VENT/PIPE POINTS OF UNDER GROUND TANK
EX	EXHAUST COVERED WITH SPARK ARRESTER

SCALE 1:200 UNLESS SHOWN ALL DIMENSIONS ARE IN 'mm'

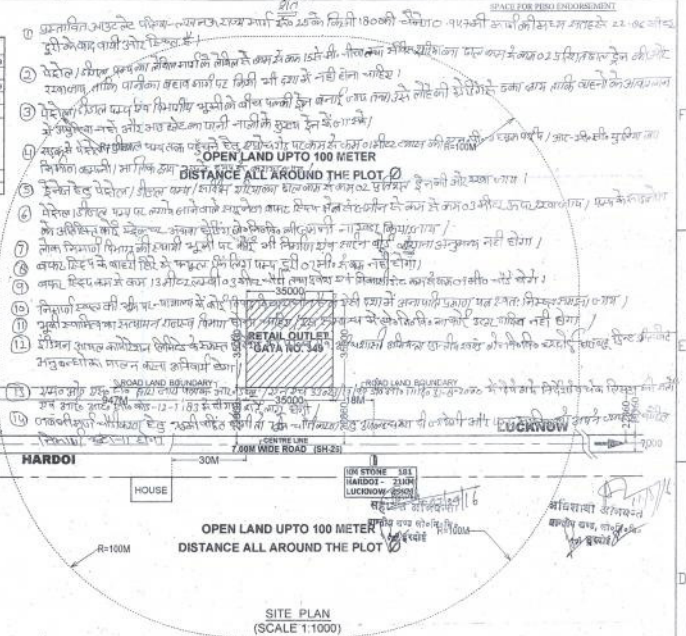

CERTIFICATES & NOTES

1. LICENSED PREMISE SHALL CONFORM TO LATEST IRC-12 REGULATIONS FOR ROAD SIDE RETAIL OUTLETS.
2. NO SEWER OR SURFACE DRAIN WITHIN 8M AROUND THE UNDER GROUND TANKS/DISPENSING UNITS.
3. NO OVERHEAD HIGH TENSION ELECTRICAL LINE PASSING OVER THE SITE.
4. OPS BOARD SHALL BE PROVIDED 1500 mm ABOVE THE FLOOR LEVEL INSIDE THE ROOM.
5. ILLUMINATION POLES ARE FIXED AS PER CEE-NAGPUR APPROVAL LETTER No. PL-111(MB) dt. 20-11-13.
6. ELECTRICALLY OPERATED PUMPS & ALL OTHER ELECTRICAL FITTINGS ARE CONFORMING TO IS-2148.
7. FILL POINT FITTED WITH CAM LOCK COUPLING & AIR TIGHT THREADED BRASS CAP FOR DECANTING.
8. FILL DIP AND SUCTION PIPES ARE EXTENDED TO BOTTOM OF TANK SHELL WITH A FREE BOARD OF 60mm.
9. DISPENSING UNITS & TANKS SHALL BE PROVIDED WITH EARTHING AS PER PETROLEUM RULES 2002.
10. BUILDING SHALL BE PROVIDED WITH DOORS OPENING OUTWARD FROM ALL ROOMS.
11. ALL UNDER GROUND TANKS ARE INSTALLED IN EARTHEN PIT UNLESS OTHERWISE SPECIFIED.
12. TANK FABRICATION & DESIGN ARE CONFORMING TO IS-10987/1992 AS PER CODE-NAGPUR APPROVAL.
13. DETAILS REQUIRED FOR CONSTRUCTION ARE AS IN STANDARD TYPICAL DRAWINGS.
14. PIPE LINES USED FOR CONNECTING TO THE STORAGE TANK ARE OF B-CLASS STEEL (MS/STAINLESS) JOINED WITH PIPE FITTINGS AND HYDRAULICALLY TESTED TO 0.35 Kg/Cm² C.M. AND SHALL CONFORM TO IS-1239.
15. STORAGE TANKS CONFORM TO IS-1239, 125, 131 OF PETROLEUM RULES 2002 AND PAINTED WITH 2 COAT BEACH OF BITUMEN BASED PAINT & ZINC CHROMATE BASED PRIMER. DIP RODS ARE 3000mm LONG.
16. UNDERGROUND STORAGE TANKS ARE MADE OF MILD STEEL PLATES (IS-226: CIRCULAR ENDS 8mm THICK & CYLINDRICAL SHELL WITH 5.6mm THICK PLATE) AND TESTED TO 0.25 Kg/Cm² HYDRAULIC PRESSURE.
17. NO SMOKING BOARD/EXPLOSIVE LICENCE NUMBER/EXTRACT OF PETROLEUM RULES ETC. SHALL BE DISPLAYED INSIDE PREMISES AND PREMISES SHALL BE USED AS PER THE CONDITIONS OF LICENSE.
18. FIRE BUCKETS FILLED WITH DRY SAND, FOAM TYPE FIRE EXTINGUISHER OF 9 LITRE CAPACITY & DOPTYPE OF 10 Kg CAPACITY, MINIMUM 2 Nos. EACH SHALL BE PROVIDED AT THE PREMISES.
19. VENT PIPE SHALL BE PROVIDED FROM VAPOUR SPACE INSIDE TANK AND EXTENDED 4M ABOVE GROUND LEVEL WITH INVERTED 'U' TYPE VENT HOOD COVERED WITH TWO LAYERS OF NON-CORROSIVE METAL WIRE GAUGE OF 11 MESH PER Sq Cm LENGTH AT THE OPENINGS.
20. THIS LAND IS FREE FROM LITIGATIONS AND NO UNSETTLED CASES PENDING IN THE COURT OF LAW.

INDIAN OIL CORPORATION LIMITED
LUCKNOW DIVISIONAL OFFICE, LUCKNOW.
KAPOORTHALA COMPLEX, SECTOR - F, ALGAUNJ, LUCKNOW.

RETAIL OUTLET LAYOUT FOR PETROLEUM PRODUCTS (MS & HSD)

ROAD NAME / NO	STATE- UTTAR PRADESH
HARDOI - LUCKNOW (SH-25)	DISTRICT- HARDOI
POST OFFICE- BAGHAULI	TEHSIL- HARDOI
POLICE STN. - BAGHAULI	VILLAGE- KHAJURMAI
RAILWAY STN. - BAGHAULI	SURVEY/KHASRA No. 349
PIN CODE - 241122	DRAWING NO. RO/KHAJURMAI/2015

MGR (RS)

SR MGR (ENG)

SORSRM

PREPARED BY: [Signature]

DATE: 26.08.2015