
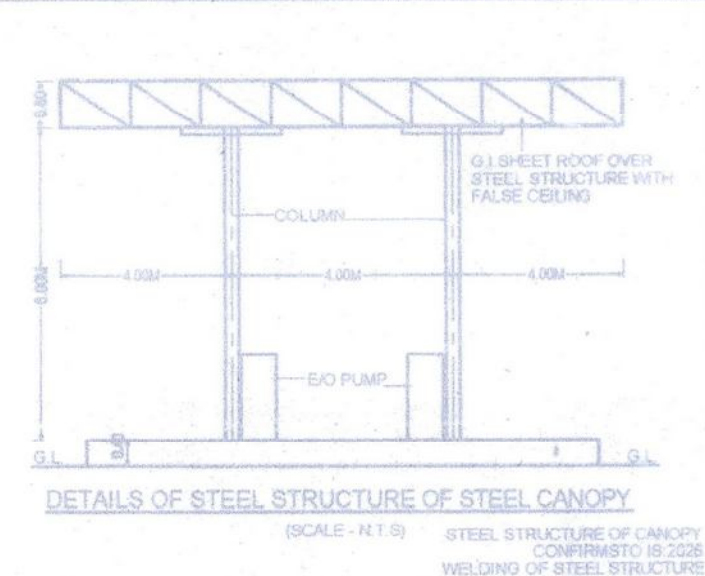


3 NOS 40MM/2 VENT PIPES
4.0M HIGH & 4.0M CLEAR

0.23M THICK & 1.2M HIGH BRICK
MASH BOUNDARY WALL

FIRE BUCKET

1 NO 16 KL CAP. U/G MILD STEEL M.S. TANK
OF SIZE 2.00M X 2.50M LONG IN MASONRY
PIT FOUNDATION WITH RCC SLAB ON TOP
APPROVED BY C.C.E., NAGPUR VIDE HIS

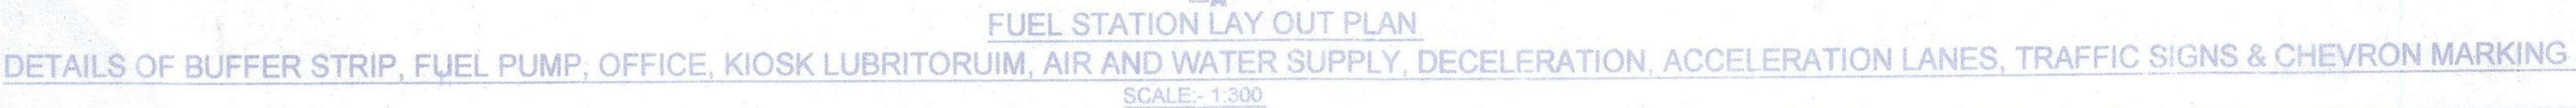

 HINDUSTAN PETROLEUM CORPORATION LTD. <u>(A GOVERNMENT OF INDIA ENTERPRISE)</u> PLOT NO-1, NEHRU ENCLAVE, GOMTI NAGAR, LUCKNOW-226010.	
SUBJECT	LAYOUT, SITE PLAN & SECTIONAL ELEVATION OF PROPOSED MS & HSD FUEL STATION.
LOCATION	SULTANPUR - LUCKNOW ROAD, NH-731 (OLD NH NO.56), IN KM.177 (CH.176.060, LHS), AT KHASRA NO. 749, VILLAGE- KAKRI, TEHSIL- HAIDERGARH, DISTRICT- BARABANKI, UTTAR PRADESH.
PREPARED BY	MS.SR.GLOBAL CONSULTANTS
  Partner	
SR Global Consultants 0522-4022283 globalsrconsultants@gmail.com	
SCALE - 1:300	DATE - April 2016   विशाल बाजपै VISHAL BAJPAI एडवोकेट Advocate Sole Constituted Attorney
DRG. NO. HPLCL/NH-731/02/2016	