


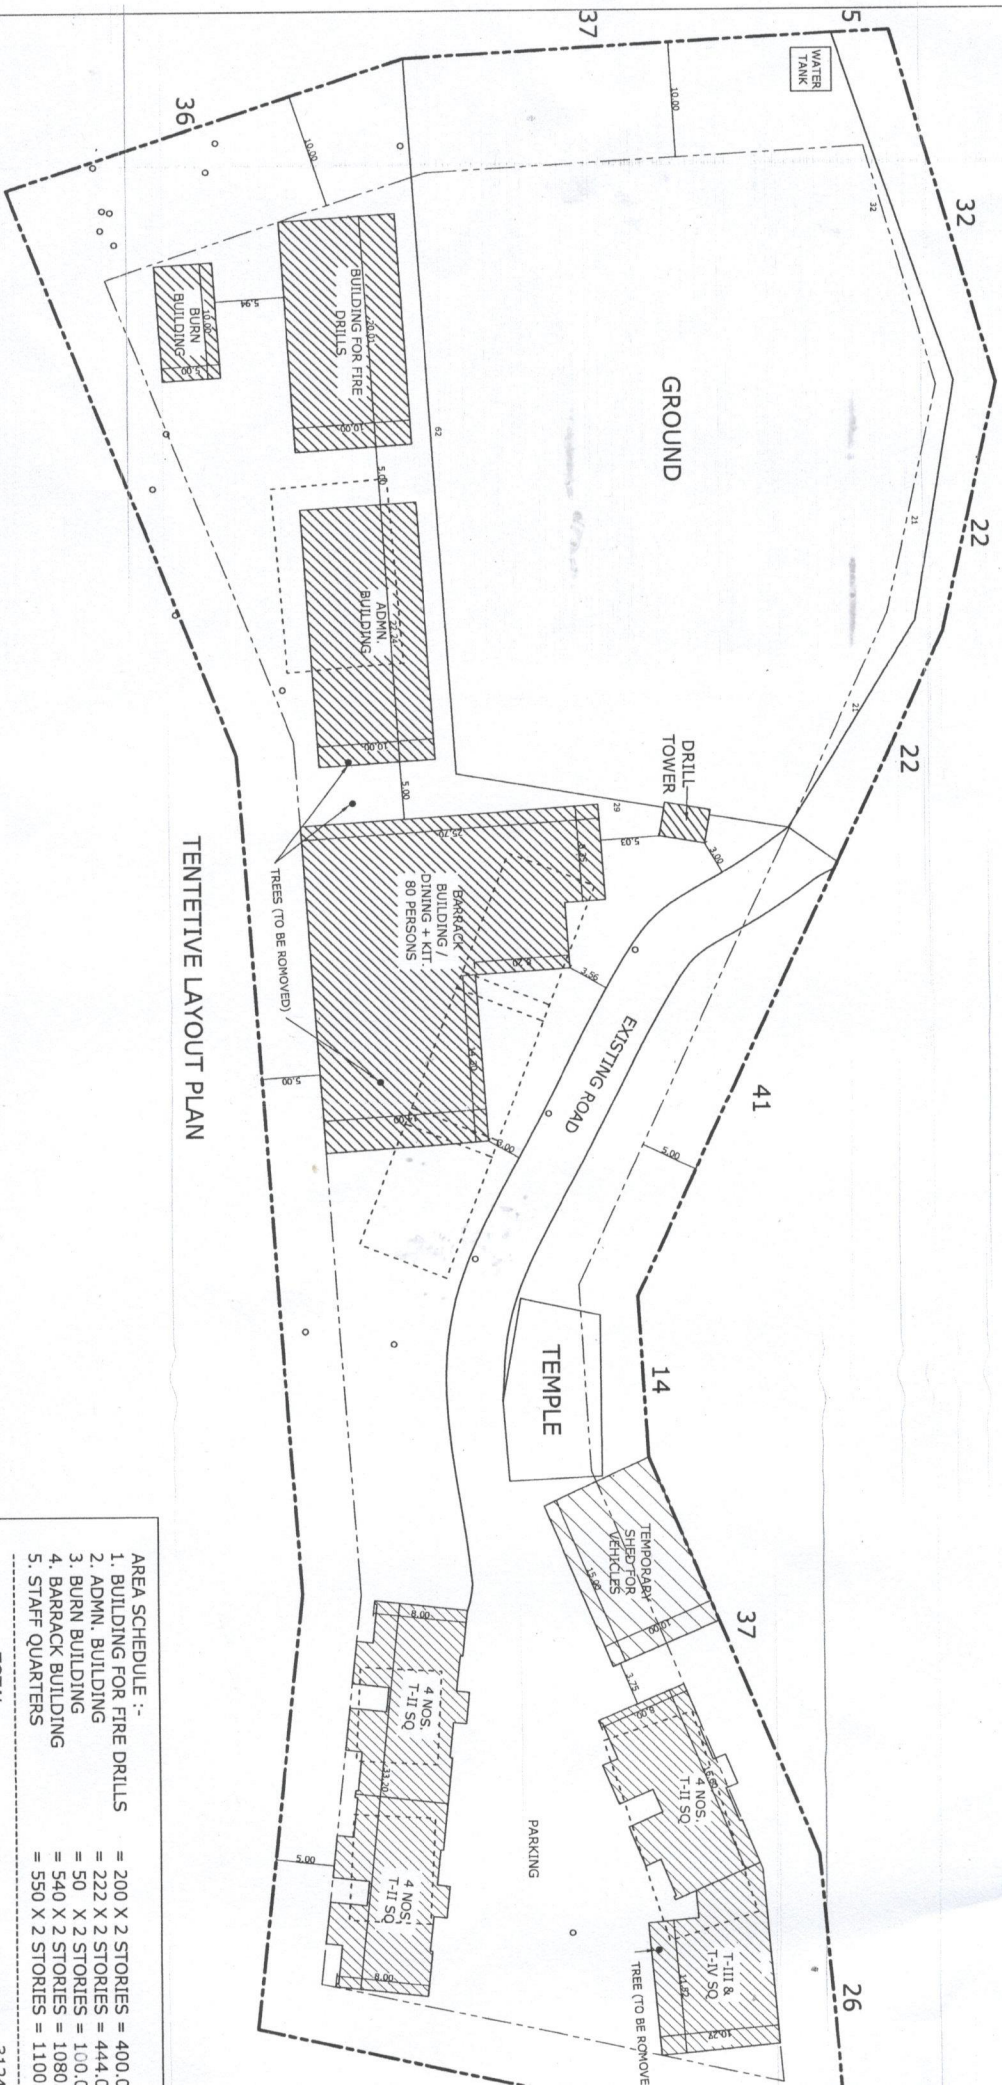

TENTATIVE LAYOUT PLAN

AREA SCHEDULE :-	
1. BUILDING FOR FIRE DRILLS	= 200 X 2 STORIES = 400.0
2. ADMN. BUILDING	= 222 X 2 STORIES = 444.0
3. BURN BUILDING	= 50 X 2 STORIES = 100.0
4. BARRACK BUILDING	= 540 X 2 STORIES = 1080
5. STAFF QUARTERS	= 550 X 2 STORIES = 1100
TOTAL	= 3124

CONST. OF FIRE TRAINING CENTRE
FOR FIRE DEPARTMENT AT
BALDIYAN, DISTT. SHIMLA (HP)

SITE PLAN

DATE :-

DRG. NO.:- WD (SP) - 01

Divisional Fire Officer,
Fire Training Centre
Baldayan DDO Code-013



EXECUTING AGENCY :-
BHARAT SANCHAR NIGAM LTD
OFFICE OF THE CHIEF ENGINEER (C)-NOR
B.S.N.L. H.P. CIVIL NORTH ZONE, NEW SHIMLA-1
PHONE :- 0177-2673009, FAX :- 0177-267301