




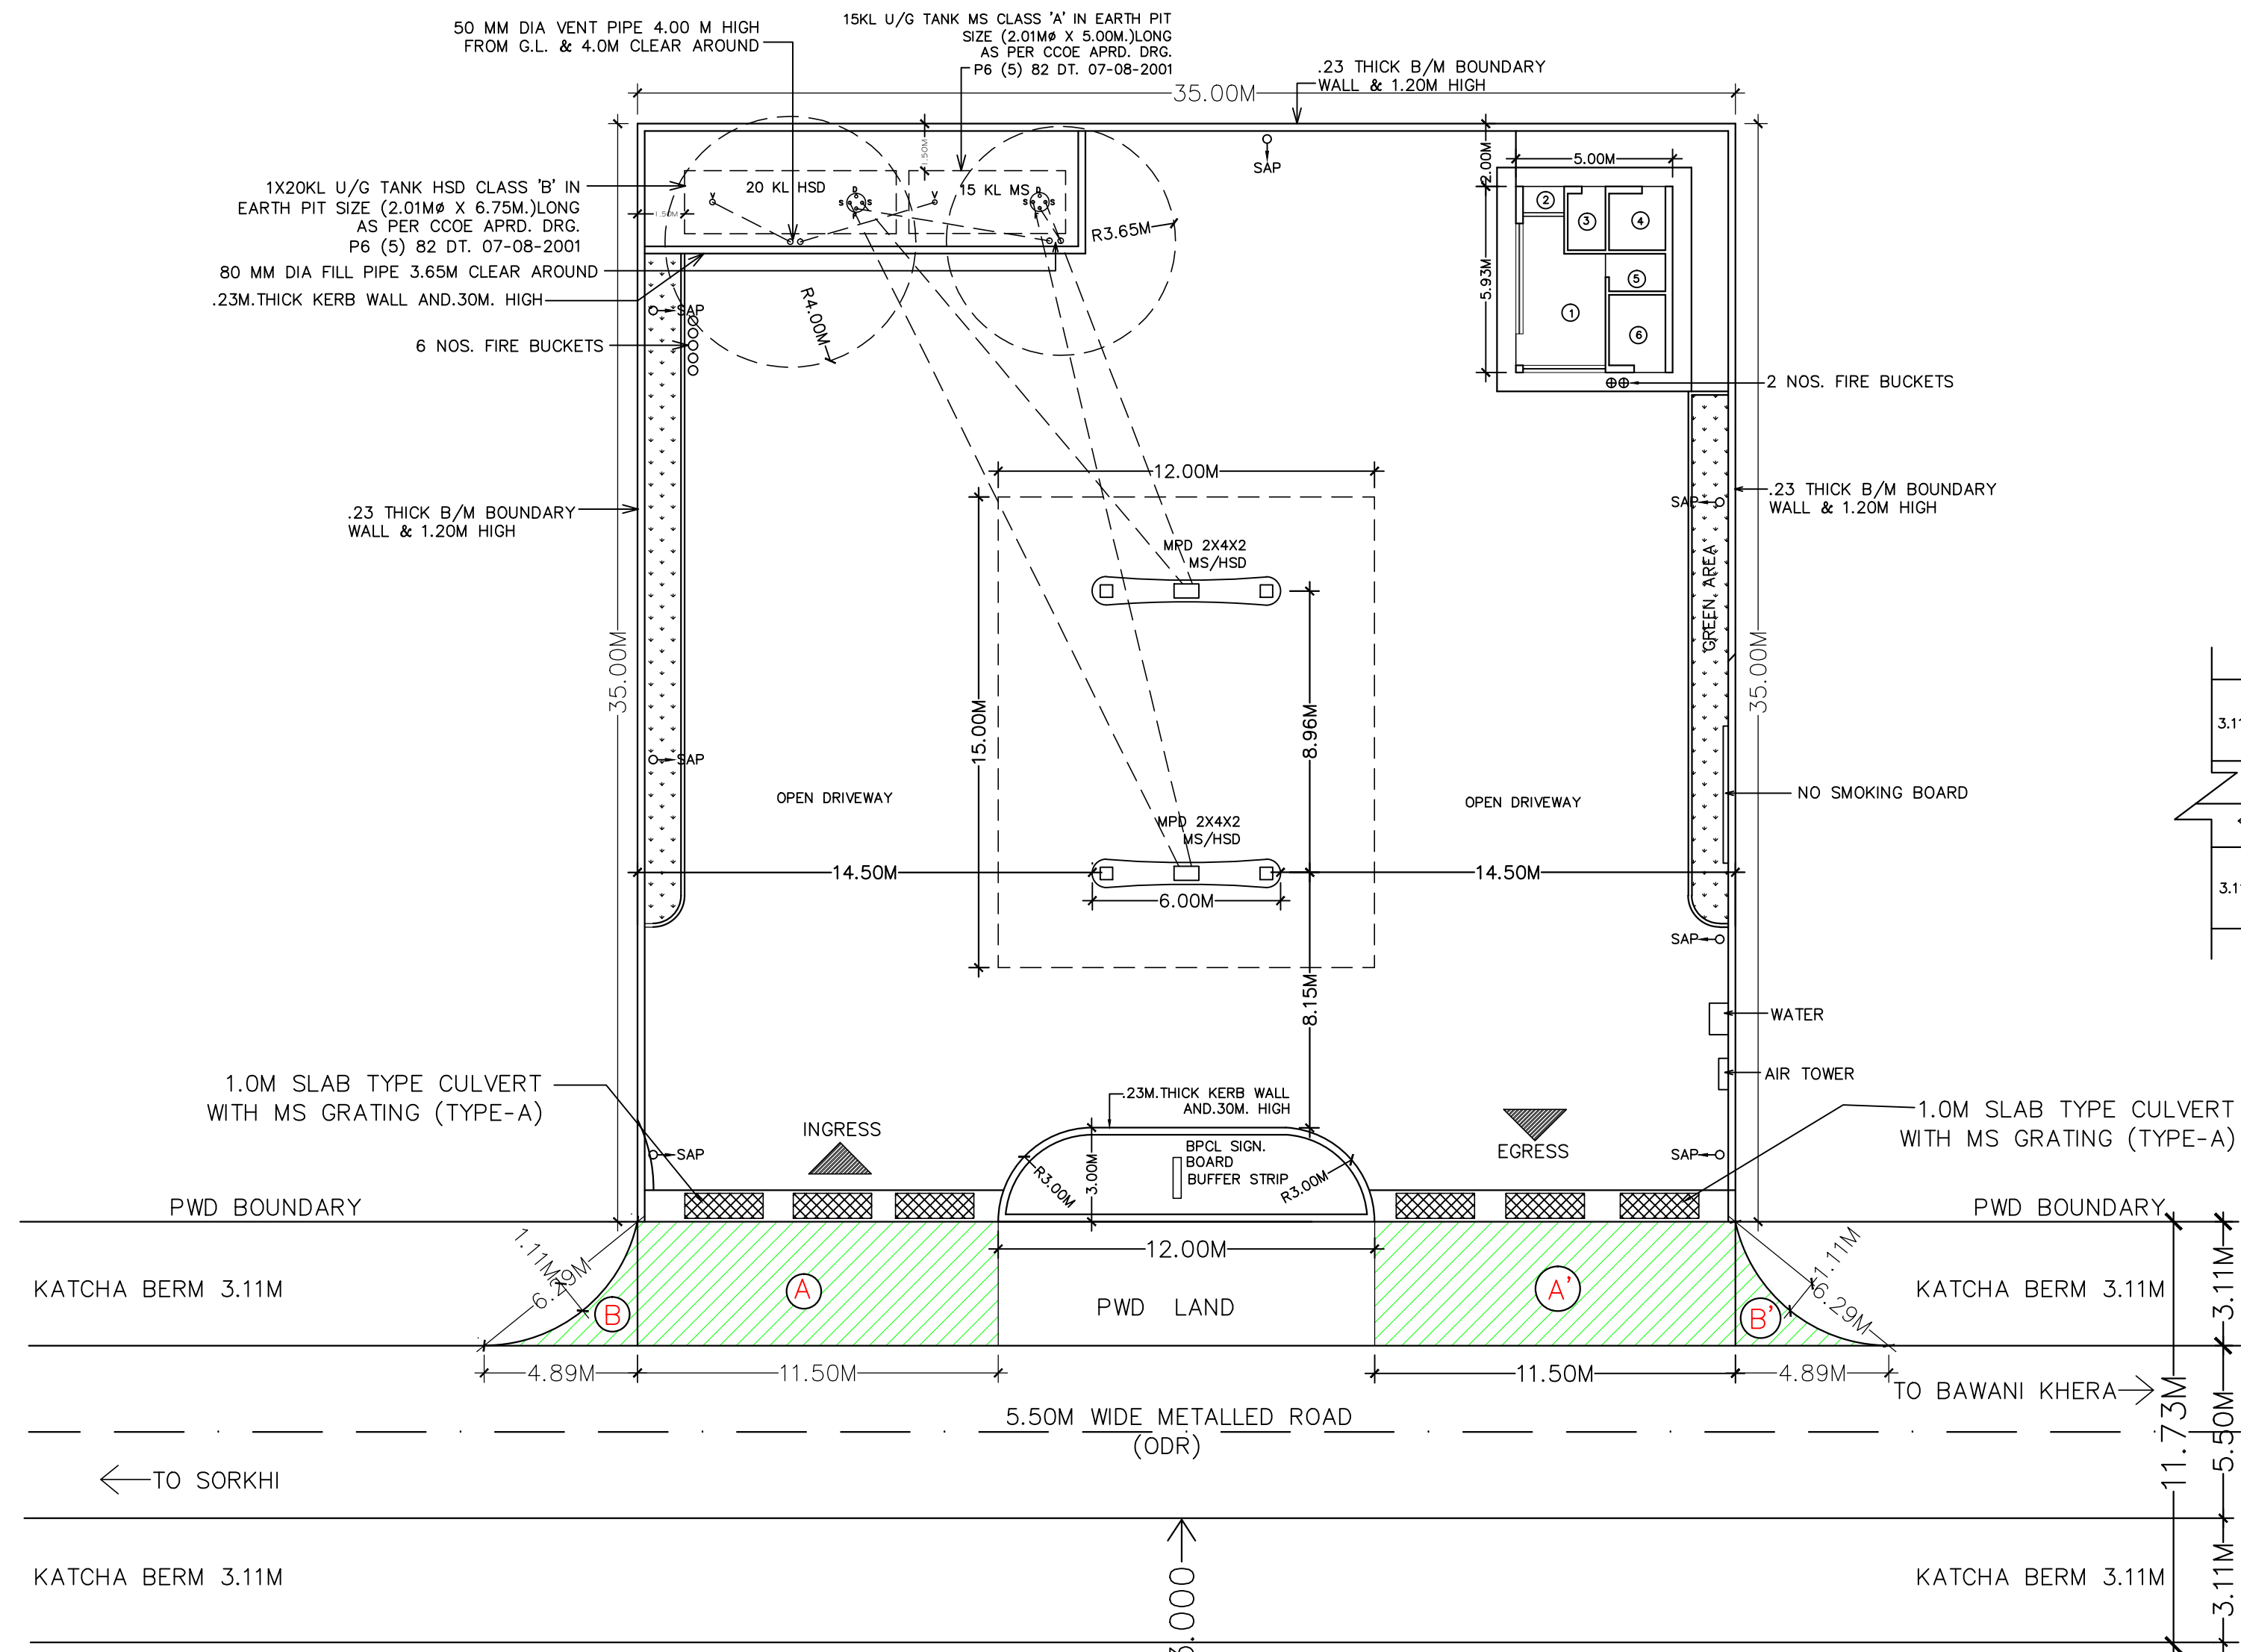


LAYOUT PLAN
SCALE:- 1: 300

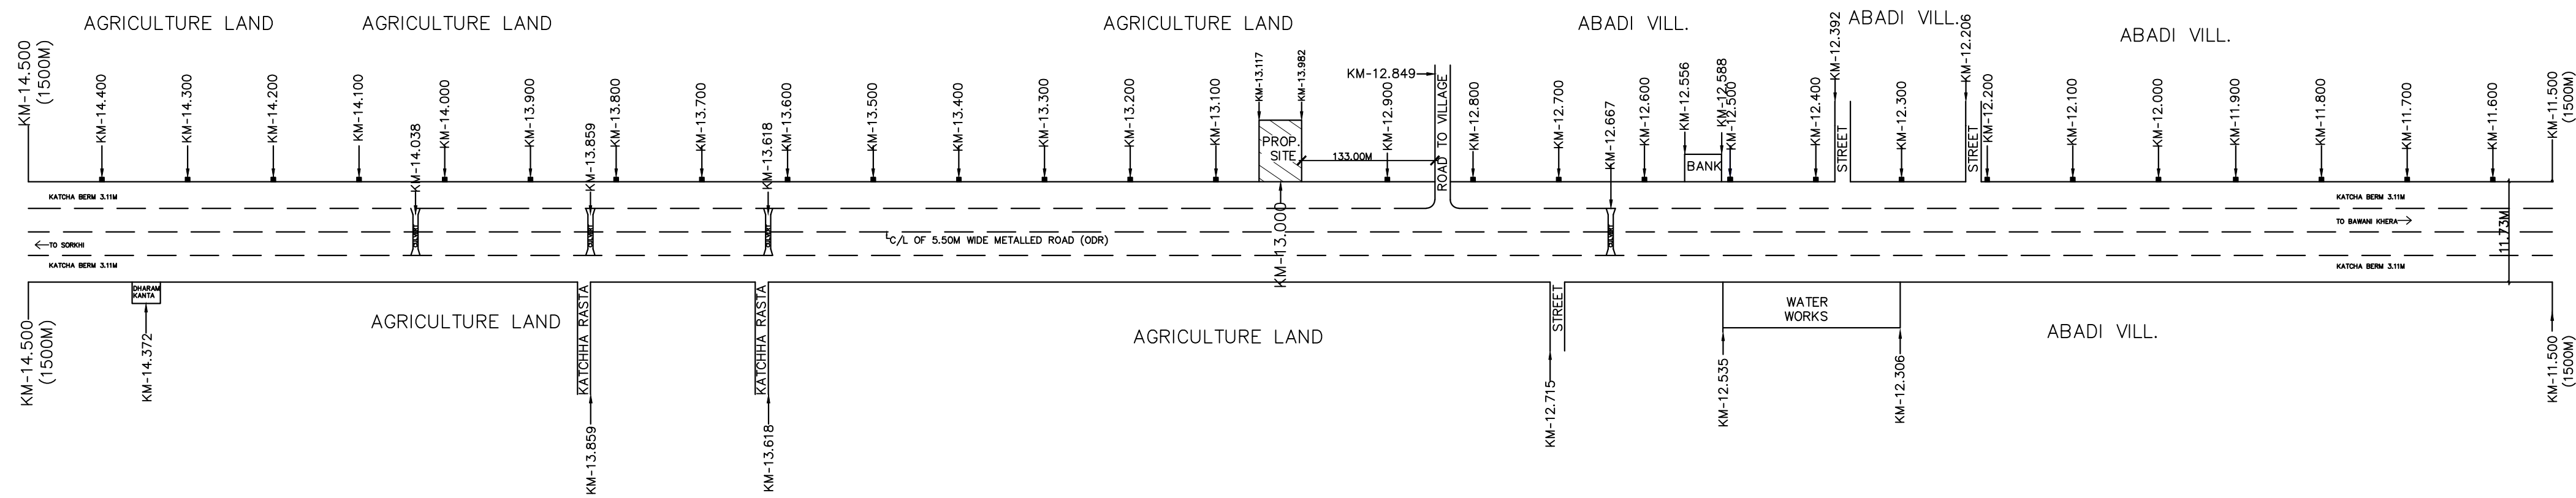



LONGITUDINAL PART ELEVATION PART SECTION

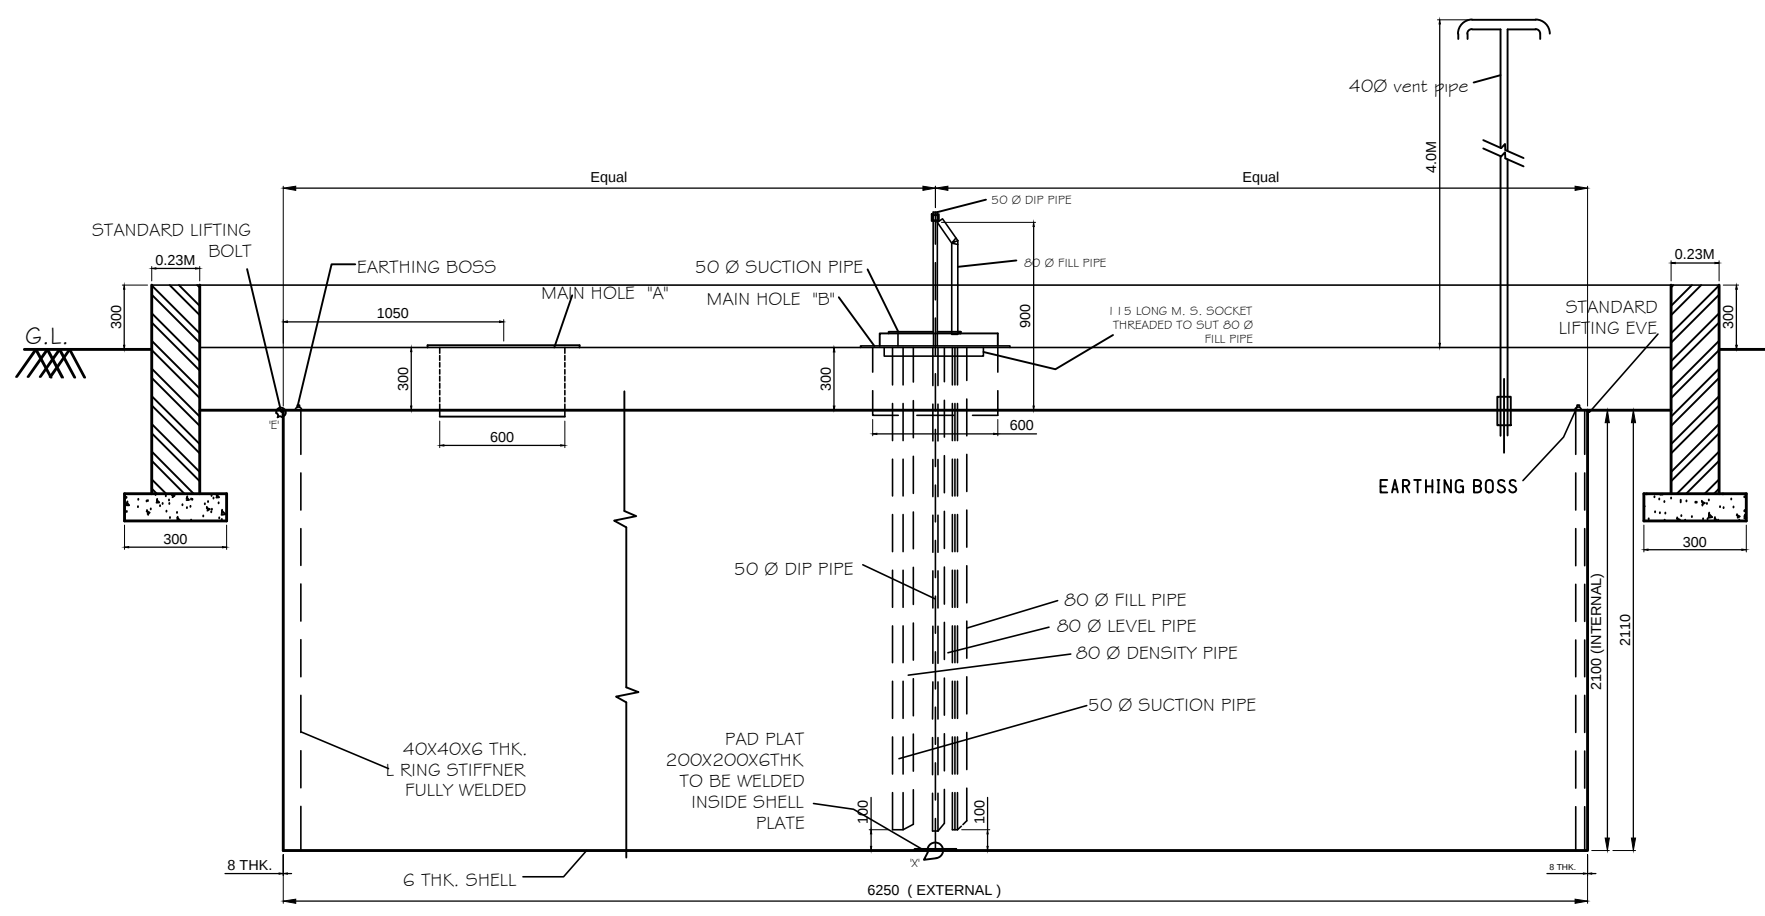

END SECTION

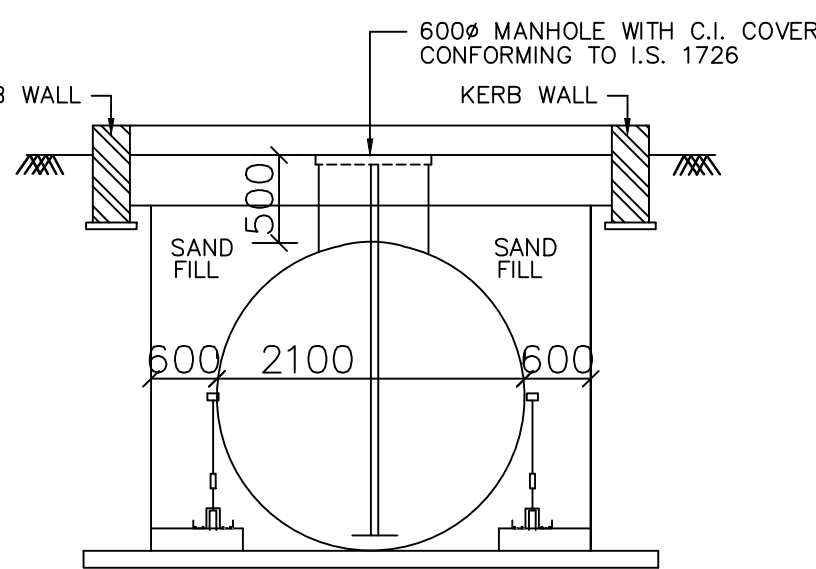

X-SECTION OF B.M. BOUNDARY WALL

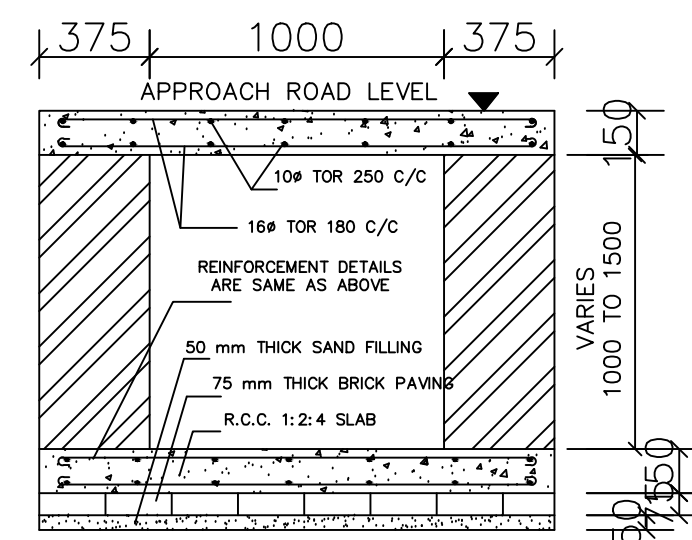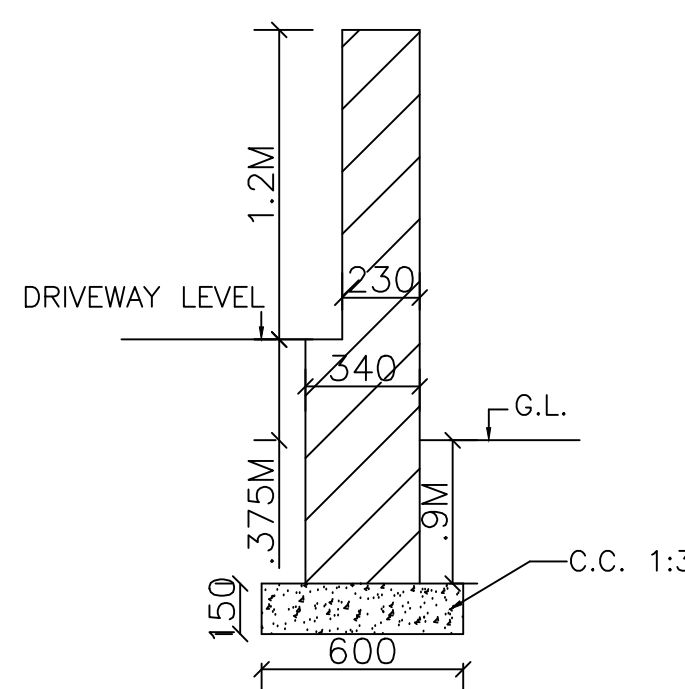

CROSS SECTION OF CULVERT
DESIGN AS PER IRC:SP-13 (TYPE-A)

TANK DATA CHART


TANK	SIZE OF TANK	MS PLATES		NO. OF H.D.B.	VENT PIPE DIA	SLAB TH. IN MM.	TANKS		PUMPS	
		SHELL	END				MS	HSD	MS	HSD
20KL	2.10M X 6.25M	6mm	8mm	8	40	325	1	1	2	2

Non Forest Area = 1225.00 sq.mt.



Non forest Area 0.1225 Hac.

APPROCH ROAD AREA

1. AREA = A+A' = 2(11.50 X 3.11) = 71.53 sq.mt.
 2. AREA = B+B' = 2(1/2X 4.89 X 3.11-2/3X6.29X1.11) = 15.20-9.30 = 5.90 sq.mt.
- TOTAL AREA = 71.53+5.90 = 77.43 sq.mt.
= 0.0077 hac.

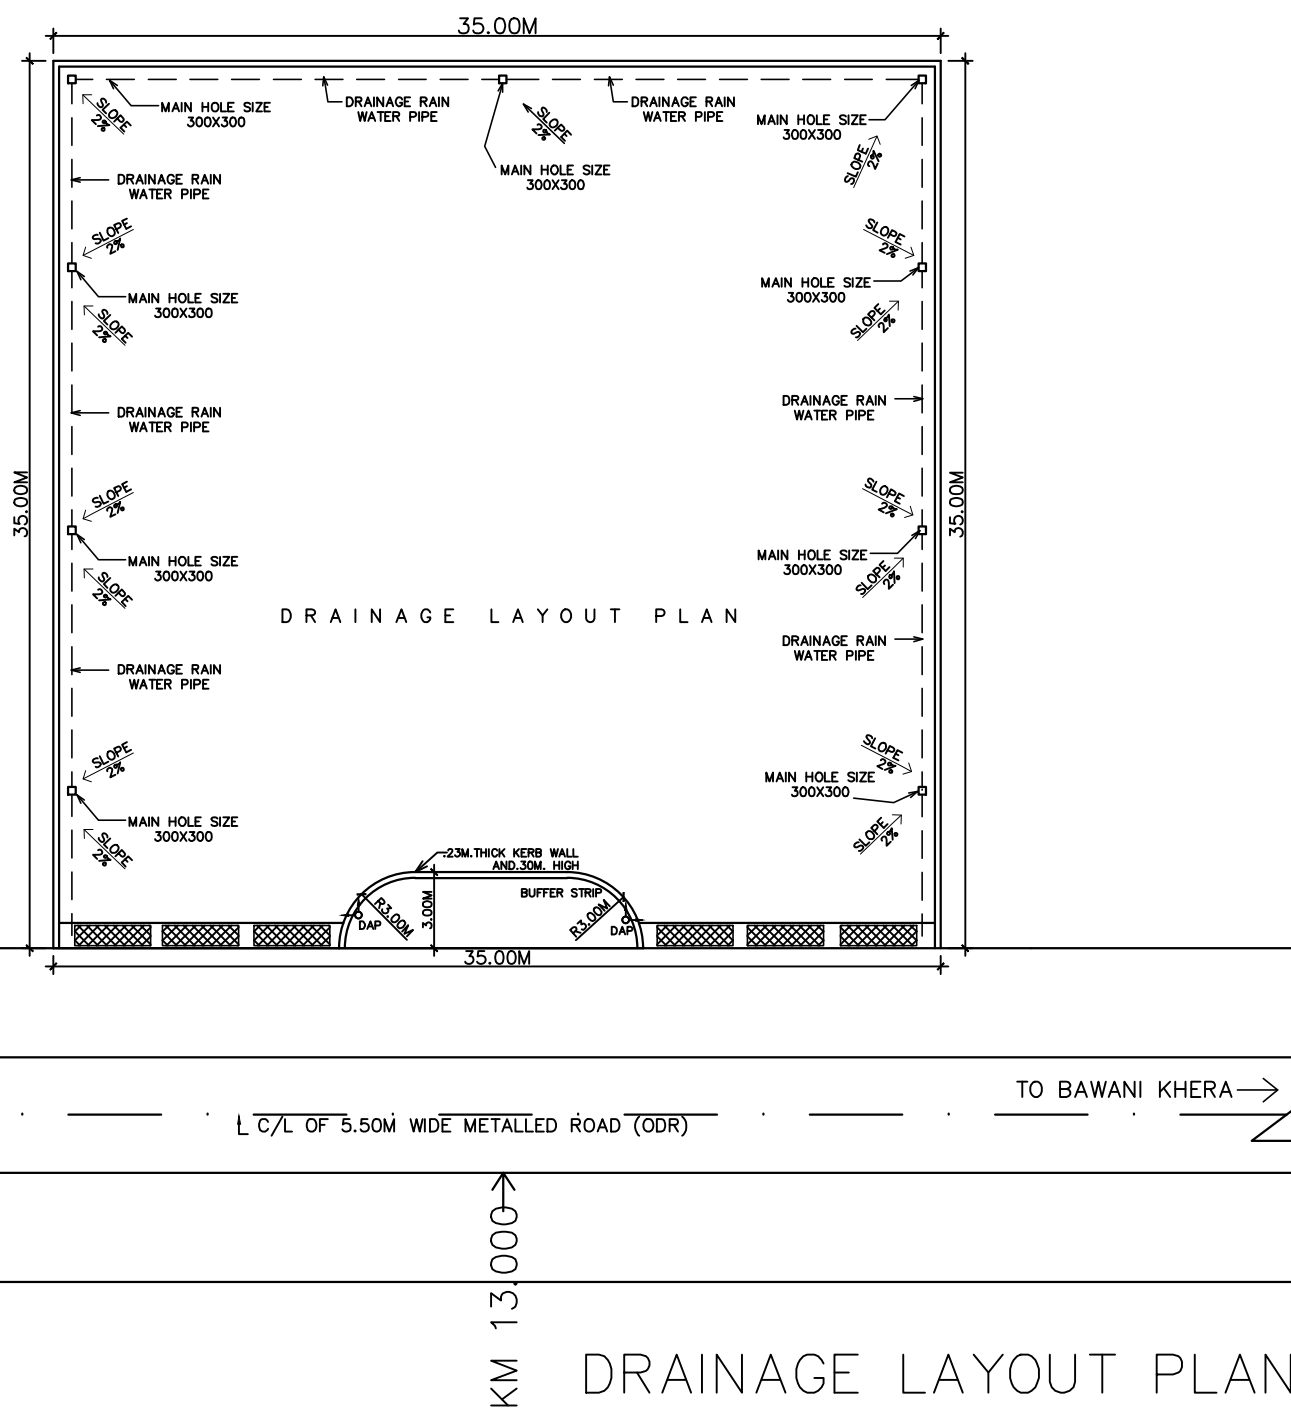

DRAINAGE LAYOUT PLAN

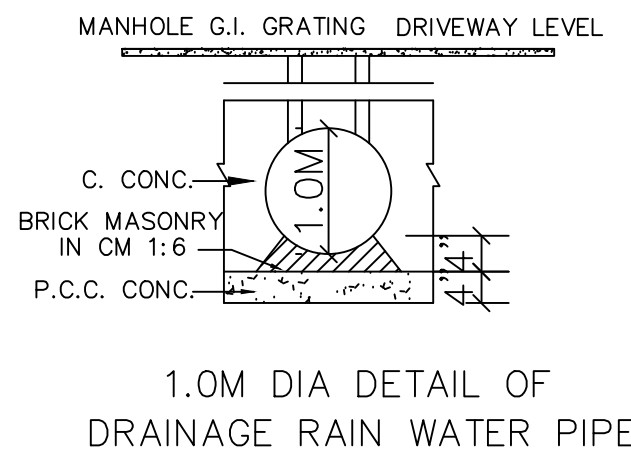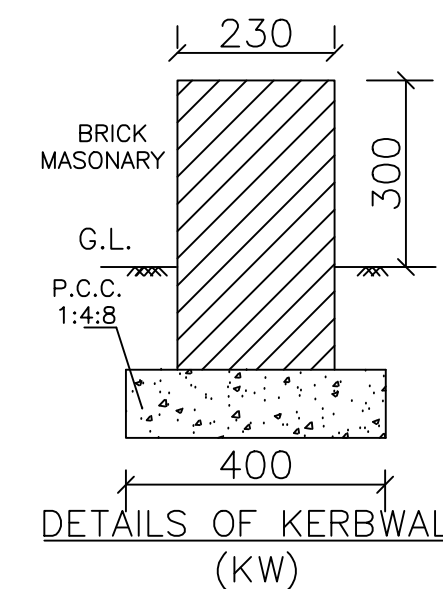

GENERAL NOTES:-


1. NO ROAD CROSSING WITHIN 300M ON EITHER SIDES OF THE PLOT.
2. NO DRAIN SEWER OR STRUCTURE WITHIN 1.5M FROM THE UNDER GROUND TANKS.
3. SUCTION, FILL & VENT PIPES UNDER THE DRIVEWAY TO BE HOUSED UNDER PIPE SLEEVE.
4. VENT PIPE 40MM DIA AND 4.0M HIGH FROM THE GROUND LEVEL AND 4.00MTR. CLEAR ALL ROUND WITHIN THE PLOT FITTED WITH INVERTED 'U' TYPE VENT HOOD COVERED WITH TWO LAYERS OF NON CORRODIBLE METAL WIRE GAUGE OF 11 MESH PER LINEAR CENTIMETER AT ITS OPEN ENDS.
5. D.P.S. BOARD FIXED ON THE WALL OF ROOM 1.50MTR. HIGH. FROM ITS FLOOR LEVEL AND SHALL NOT BE KEPT UNDER LOCK AND KEY.
6. FILL POINTS ARE KEPT 3.65M. CLEAR AROUND.
7. "NO SMOKING" SIGN SHALL BE DISPLAYED AT THE PETROL PUMP.
8. 04 Nos. 10 Kg DCP type fire extinguisher, 01 no. 4.5 Kg Co2 type fire extinguisher and 06 Nos. sand buckets, 10 Kg each.
9. TANKS, FED BY TANK LORRY.
10. BOTH THE TANKS NOT BE REPLENISHED AT THE SAME TIME.
11. FILL PIPE AND DIP PIPES ARE FITTED WITH LOCKING CAP
12. ALL ELECTRIC FITTING CONFORM TO IS CODE NO. 2148.

SPECIFICATIONS

CERTIFIED THAT THE TANK SHALL BE TO FABRICATED AS PER APPROVED SPECIFICATION AS BSI CODE 10978

NOTE:-

1. CERTIFIED THAT THIS IS A NEW RETAIL OUTLET & NOT RESITEMENT CASE.
2. CERTIFIED THAT NO COURT CASE PENDING IN ANY COURT OF INDIA AGAINST THIS SITE/DEALERSHIP.
3. CERTIFIED THAT ALL THE CLEARANCES/APPROVALS FROM MCP/IRC AND OTHER RELEVANT GOVT. DEPTT. SHALL BE OBTAINED.
4. CERTIFIED THAT M.S. CANOPY OF MEASURING 12.0 M X 15.00 M SHALL CONFIRM TO SOUND ENGG. SPEC. AND THERE IS NO CHANCE OF ITS EVER CAVING-IN UNDER NORMAL CIRCUMSTANCES. STEEL CANOPY APPROVAL NO. CCE G-40(NC) P-CANOPY DT.26.07.89
4. CERTIFIED THAT ALL FACILITIES AS SHOWN IN THE DRAWING ARE INSTALLED \ PROVIDED AT ABOVE R/O.

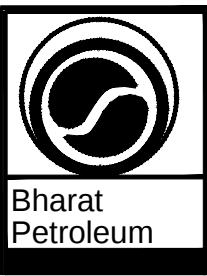AREA STATEMENT 1. Total Area of Plot.	1225 sq. mt.	 BHARAT PETROLEUM CORPORATION LIMITED
2. KHASRA NO.	201/1/2/2	
3. VILLAGE	KUNGAR	
4. PIN CODE	127041	
5. NEAREST POLICE STATION	BAWANI KHERA	
6. NEAREST RAILWAY STATION	BAWANI KHERA	PROPOSED LAYOUT & SITE PLAN FOR NEW RETAIL OUTLET OF B.P.C.L. AT KM.13.000 (RHS) ON BAWANI KHERA-SORKHI ROAD (ODR), AT VILLAGE KUNGAR, TEHSIL BAWANI KHERA, DISTT.-BHIWANI (HARYANA).
7. TEHSIL	BAWANI KHERA	
8. DISTRICT	BHIWANI	
9. STATE	HARYANA	
PREPARED BY:-		
 B.R.K Group of Engineers MO. No. 94162-66173, 98122-31598 Email : brk.gov.in@gmail.com # 273, OPP. GURUDAWARA, MODEL TOWN, HISAR.		Drawn: RAJ RANI Checked BY : Ar. Birbal Swami Approved BY : Drg No. :- BPCL/BRK/Hisar/276 Dated. :- 25/08/2020 Scale. :- as shown

TERRITORY MANAGER