

SITE PLAN FOR PROP. LAYING OF 450 MM I/D RCC PIPE LINE FROM POINT A TO POINT B AT JANDWALA SOTTER ROAD IN VILL. NURKI AHLI DISTT. FATEHABAD




No. H43P6

Scale 1:50,000

Edirha PUNJAB H43P1	Musa PUNJAB H43P5	Sargh PUNJAB H43P9
Siba HARYANA H43P2	H43P6	Fatehabad HARYANA H43P10
H43P3	H43P7	H43P11

भारतीय सर्वेक्षण विभाग
SURVEY OF INDIA
1st Edition 2008
Page No. 150/1
CONVENTIONAL SYMBOLS

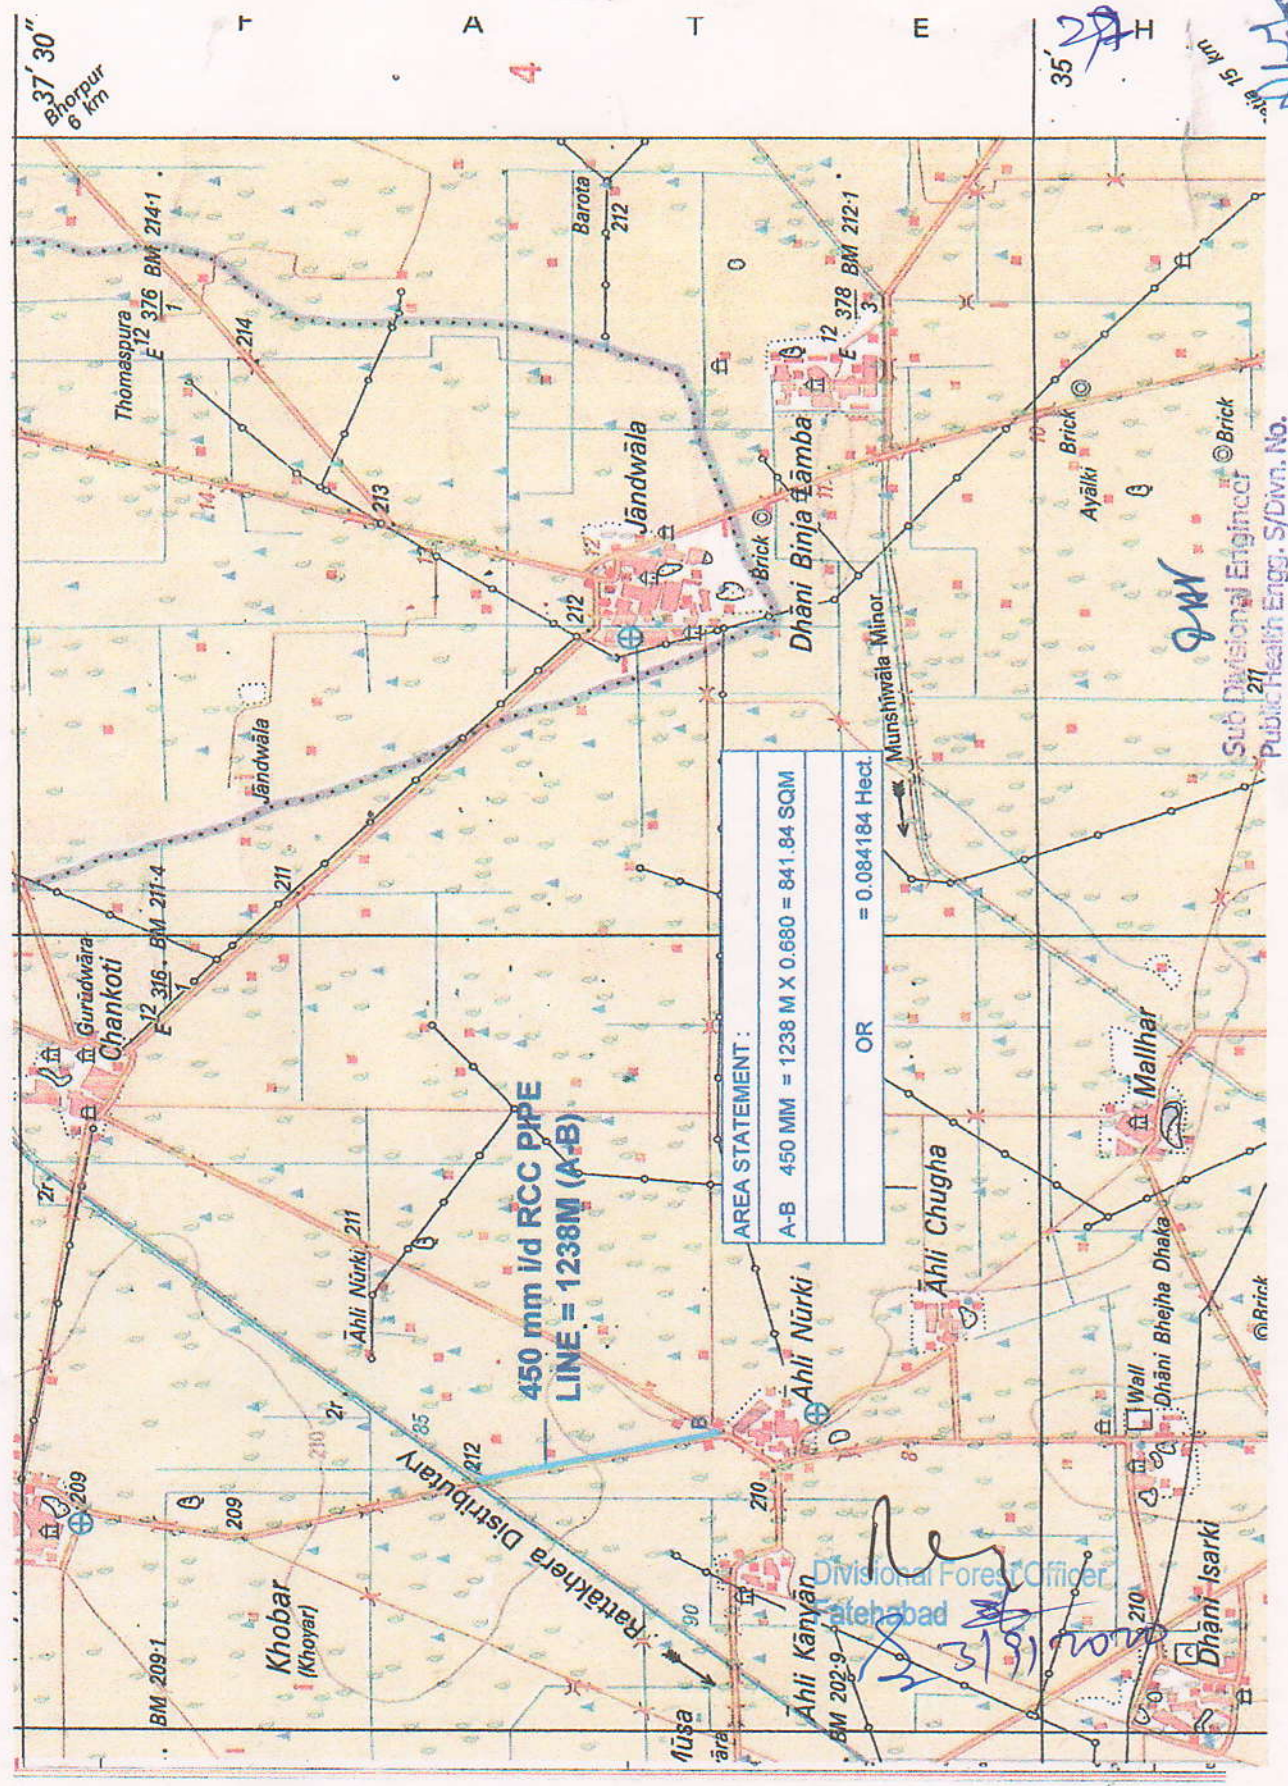

Sub Divisional Engineer
Public Health Engg. S/Dwn. No. 211
Fatehabad

F A T E H A B A D
 37' 30" Bhorpur 6 Km
 35' 20" 15 Km